


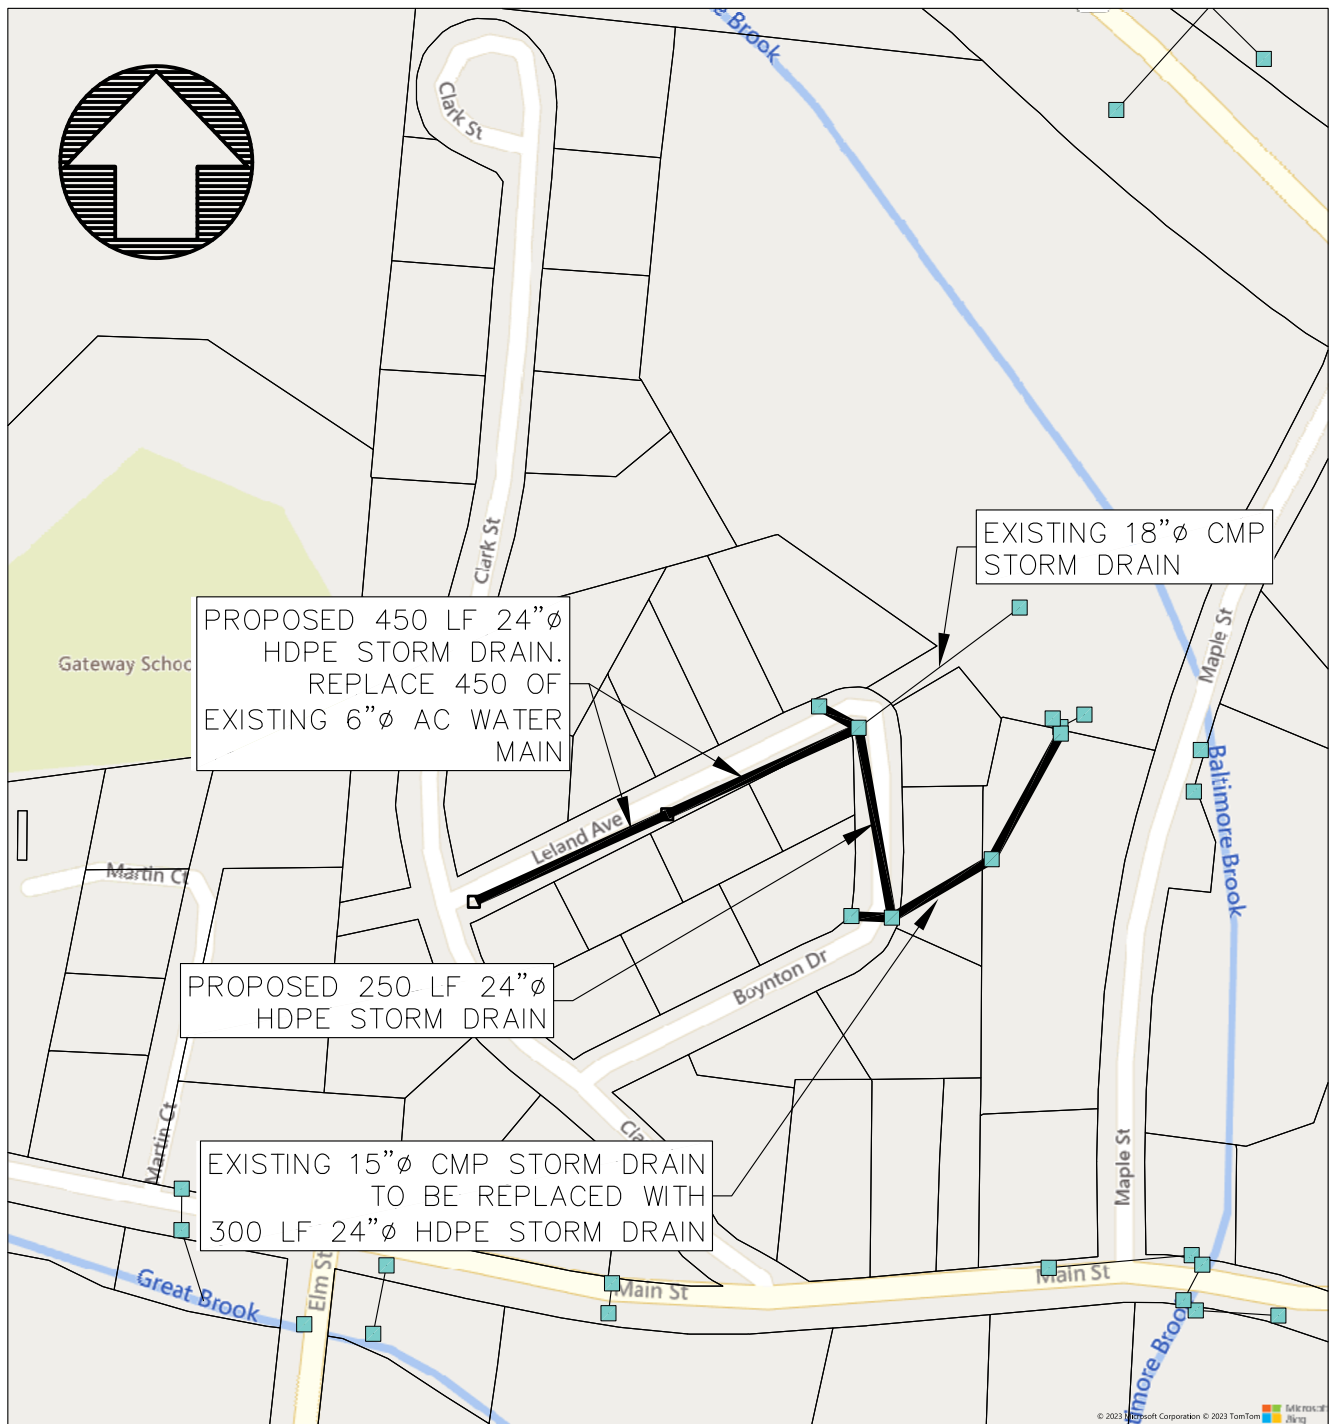

PROPOSED SITE PLAN

SCALE: 1"=200'

NOTES:

1. PIPING AND CATCH BASIN LAYOUT IS CONCEPTUAL AND MAY BE REVISED DURING DESIGN.



**DUFRESNE GROUP
CONSULTING ENGINEERS**

Suite 200, 56 Main Street
Springfield, Vermont 05156
Tel: (802) 674-2904 Fax: (802) 674-2913
E-mail: info@dufresnegroup.com
Home page: www.dufresnegroup.com

FIGURE 1

CONCEPTUAL IMPROVEMENTS LELAND AVENUE & BOYNTON DRIVE

SPRINGFIELD, VERMONT

PROJECT NO. 7123021

PROJECT MGR. NRJ

SCALE 1"=200'

DATE OCTOBER, 2023

DRAWING NO. LelandArea.dwg