

STATE OF VERMONT
AGENCY OF TRANSPORTATION



PROPOSED IMPROVEMENT
BRIDGE PROJECT


TOWN OF NORTH HERO – GRAND ISLE
COUNTY OF GRAND ISLE

ROUTE NO :US ROUTE 2 BRIDGE NO :8

PROJECT LOCATION : LOCATED ON US ROUTE 2, APPROXIMATELY 2,000 FEET NORTH OF THE
INTERSECTION OF US ROUTE 2 AND EAST SHORE NORTH OVER LAKE CHAMPLAIN.


PROJECT DESCRIPTION : INSTALL TEMPORARY TRAFFIC CONTROLS, REPLACE BRIDGE #8, AND REMOVE
TEMPORARY TRAFFIC CONTROLS.

LENGTH OF STRUCTURE : 260 FEET.
LENGTH OF ROADWAY : 875 FEET.
LENGTH OF PROJECT : 875 FEET.

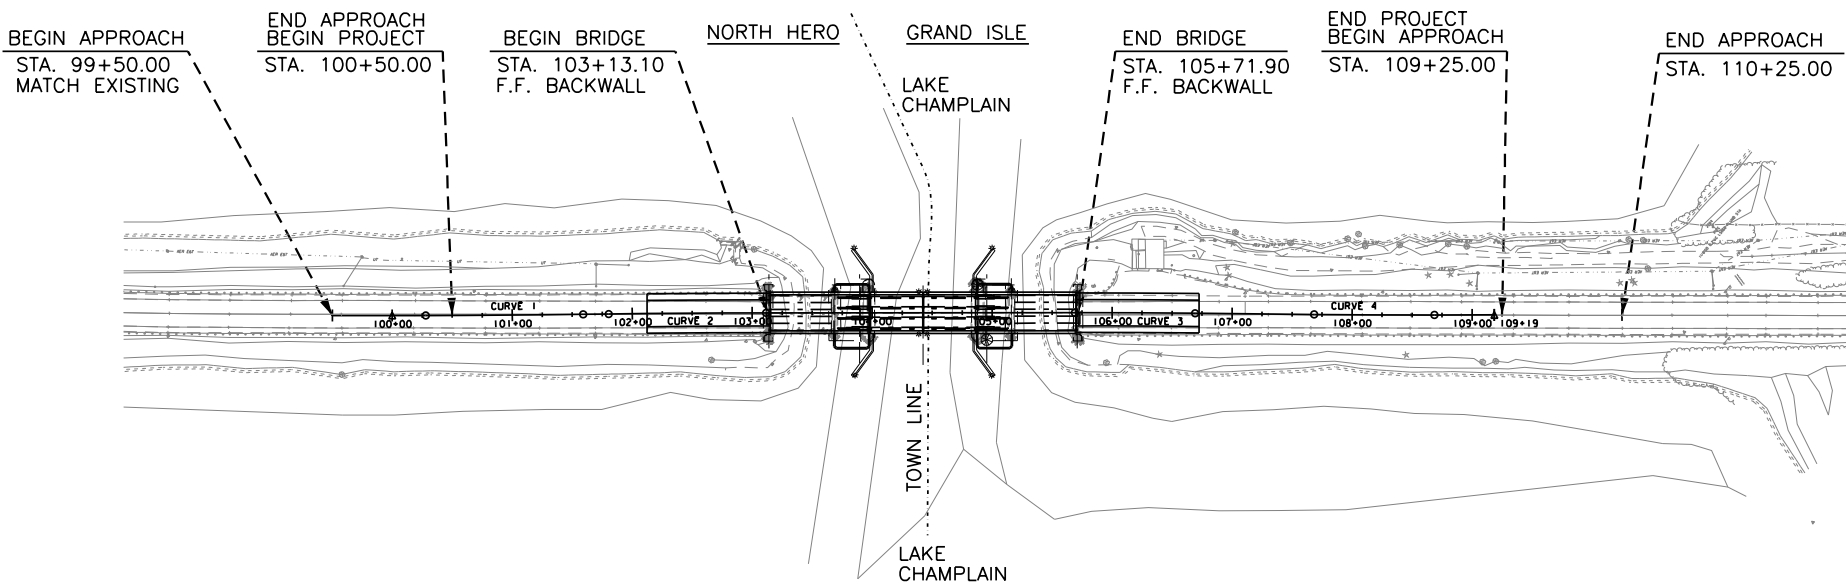

THESE PLANS ARE SUBJECT TO SUCH ENGINEERING
CHANGES AS MAY BE REQUIRED BY THE FEDERAL HIGHWAY
ADMINISTRATION OR THE DIRECTOR OF PROGRAM
DEVELOPMENT.
CONSTRUCTION IS TO BE CARRIED ON IN ACCORDANCE
WITH THESE PLANS AND THE STANDARD SPECIFICATIONS
FOR CONSTRUCTION DATED 2011, AS APPROVED BY THE
FEDERAL HIGHWAY ADMINISTRATION ON JULY 20, 2011
FOR USE ON THIS PROJECT, INCLUDING ALL SUBSEQUENT
REVISIONS AND SUCH REVISED SPECIFICATIONS AND
SPECIAL PROVISIONS AS ARE INCORPORATED IN THESE
PLANS.

QUALITY ASSURANCE PROGRAM : LEVEL
SURVEYED BY :
SURVEYED DATE :
DATUM
VERTICAL
HORIZONTAL

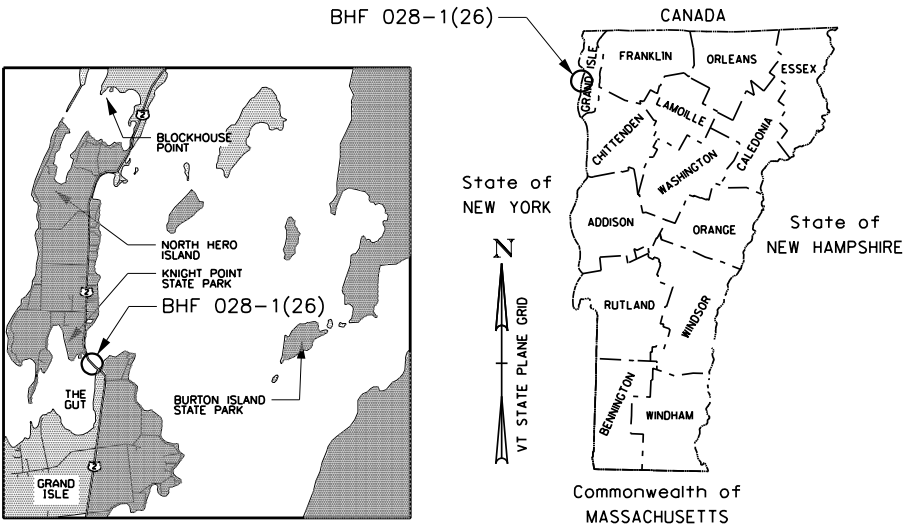


DEPARTMENT OF TRANSPORTATION FEDERAL HIGHWAY ADMINISTRATOR
APPROVED _____ DATE _____
DIRECTOR OF PROGRAM DEVELOPMENT
APPROVED _____ DATE _____
PROJECT MANAGER :
PROJECT NAME :
PROJECT NUMBER :
SHEET 1 OF 30 SHEETS

PRELIMINARY INFORMATION SHEET (BRIDGE)

LRFD

[illegible]

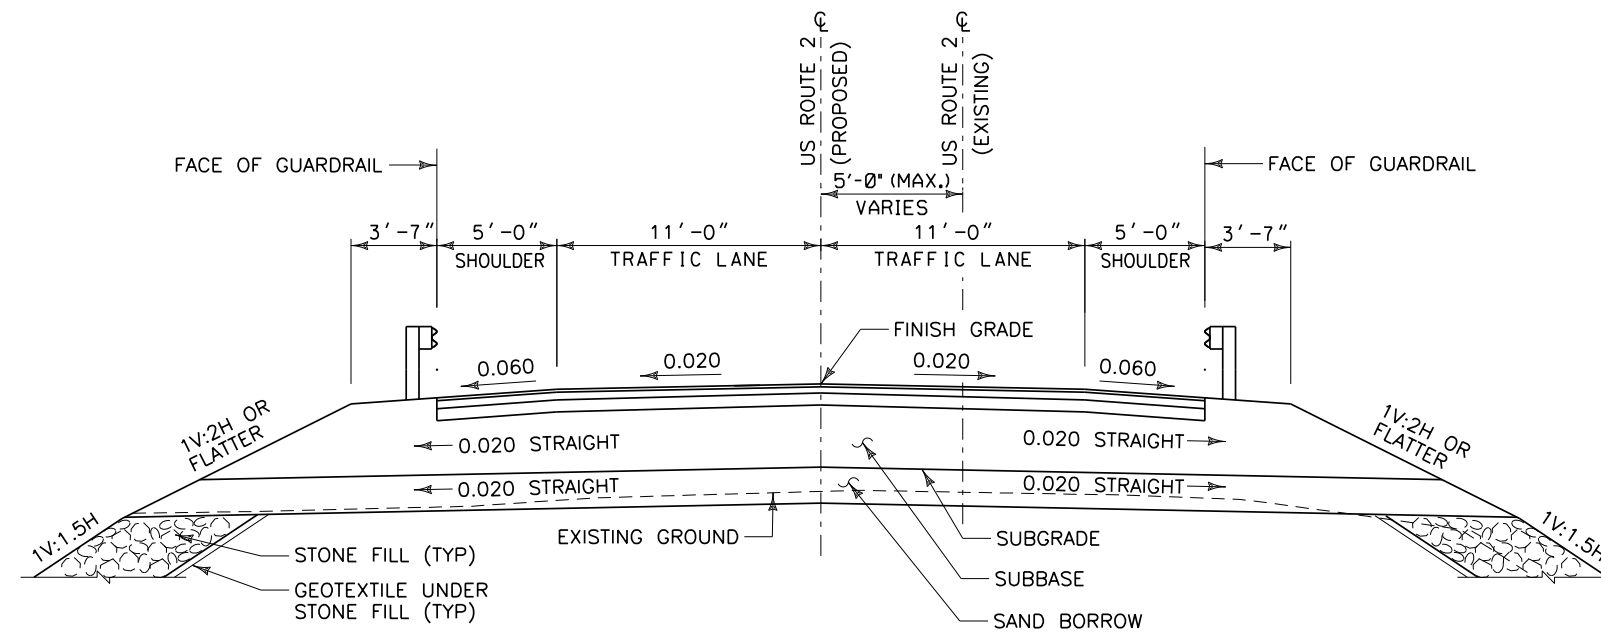

TYPICAL CAUSEWAY BRIDGE APPROACH SECTION


SCALE: 1"=8'-0"

CONCEPTUAL PLANS

SCALE 1" = 20'-0"
20 0 20



PROJECT NAME: NORTH HERO GRAND ISLE BRIDGE	
PROJECT NUMBER: BHF 028-1(26)	
FILE NAME: Z12b142typ_sec1.dgn	PLOT DATE: 07/28/2015
PROJECT LEADER: C. SWANSON	DRAWN BY: D. DOUGHERTY
DESIGNED BY: C. SWANSON	CHECKED BY: C. SWANSON
TYPICAL BRIDGE SECTIONS 1	SHEET 3 OF 30

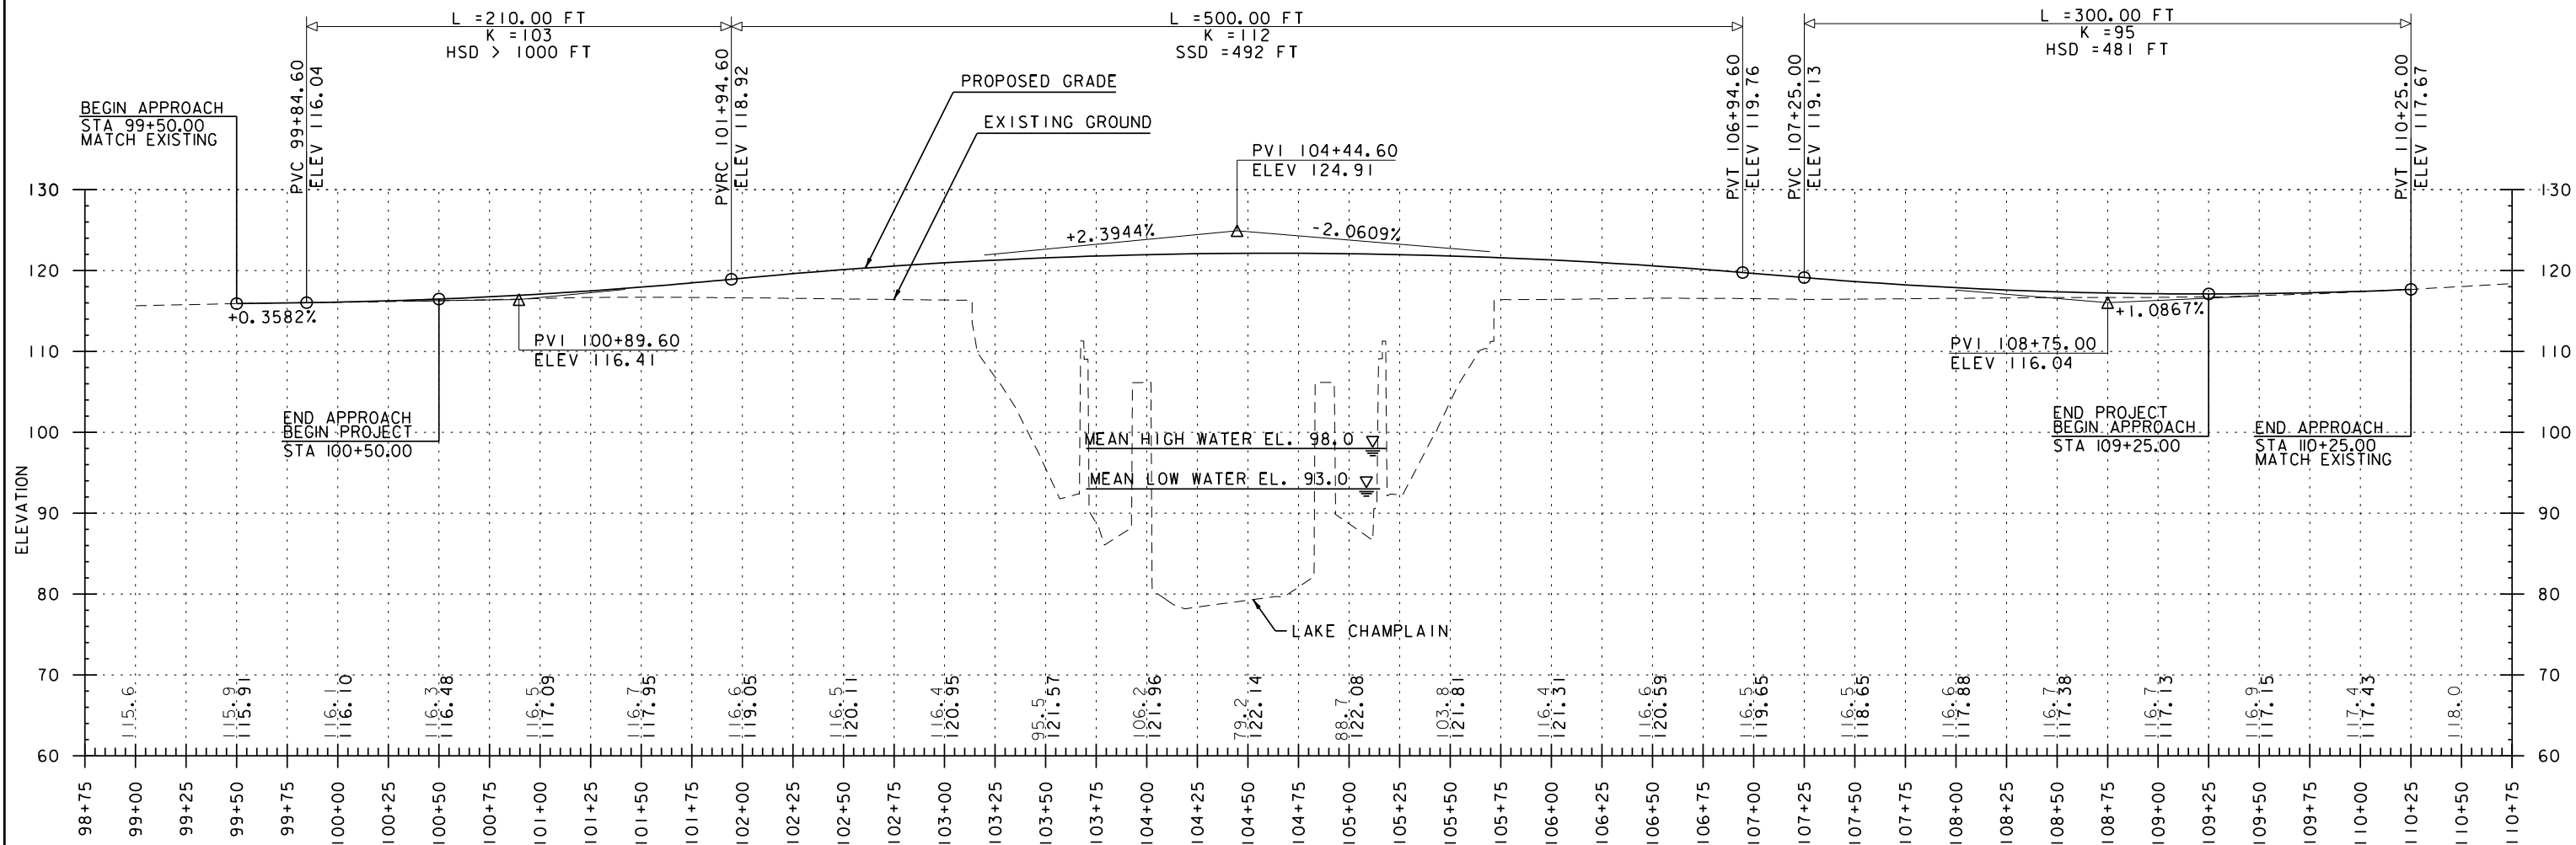


US ROUTE 2 PROFILE

CONCEPTUAL PLANS




NOTE:

1. THE GRADES SHOWN TO THE NEAREST TENTH ARE THE EXISTING GROUND ELEVATIONS ALONG CENTERLINE. THE GRADES SHOWN TO THE NEAREST HUNDREDTH ARE THE PROPOSED GRADES ALONG CENTERLINE.

FILE NAME = 9FILES
DATE/TIME = 9/23/2015
USER = 8NTUSER\$

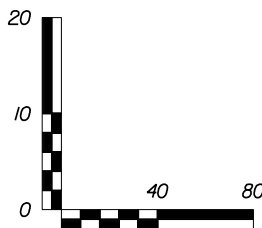


PROJECT NAME:	NORTH HERO GRAND ISLE BRIDGE		
PROJECT NUMBER:	BHF 028-11261		
FILE NAME:	z12b142p00001.dgn	PLOT DATE:	7/28/2015
PROJECT LEADER:	D.E.G.	DRAWN BY:	A.R.K.
DESIGNED BY:	J.L.S.	CHECKED BY:	J.P.S.
EXISTING AND PROPOSED PROFILE		SHEET 4	OF 30

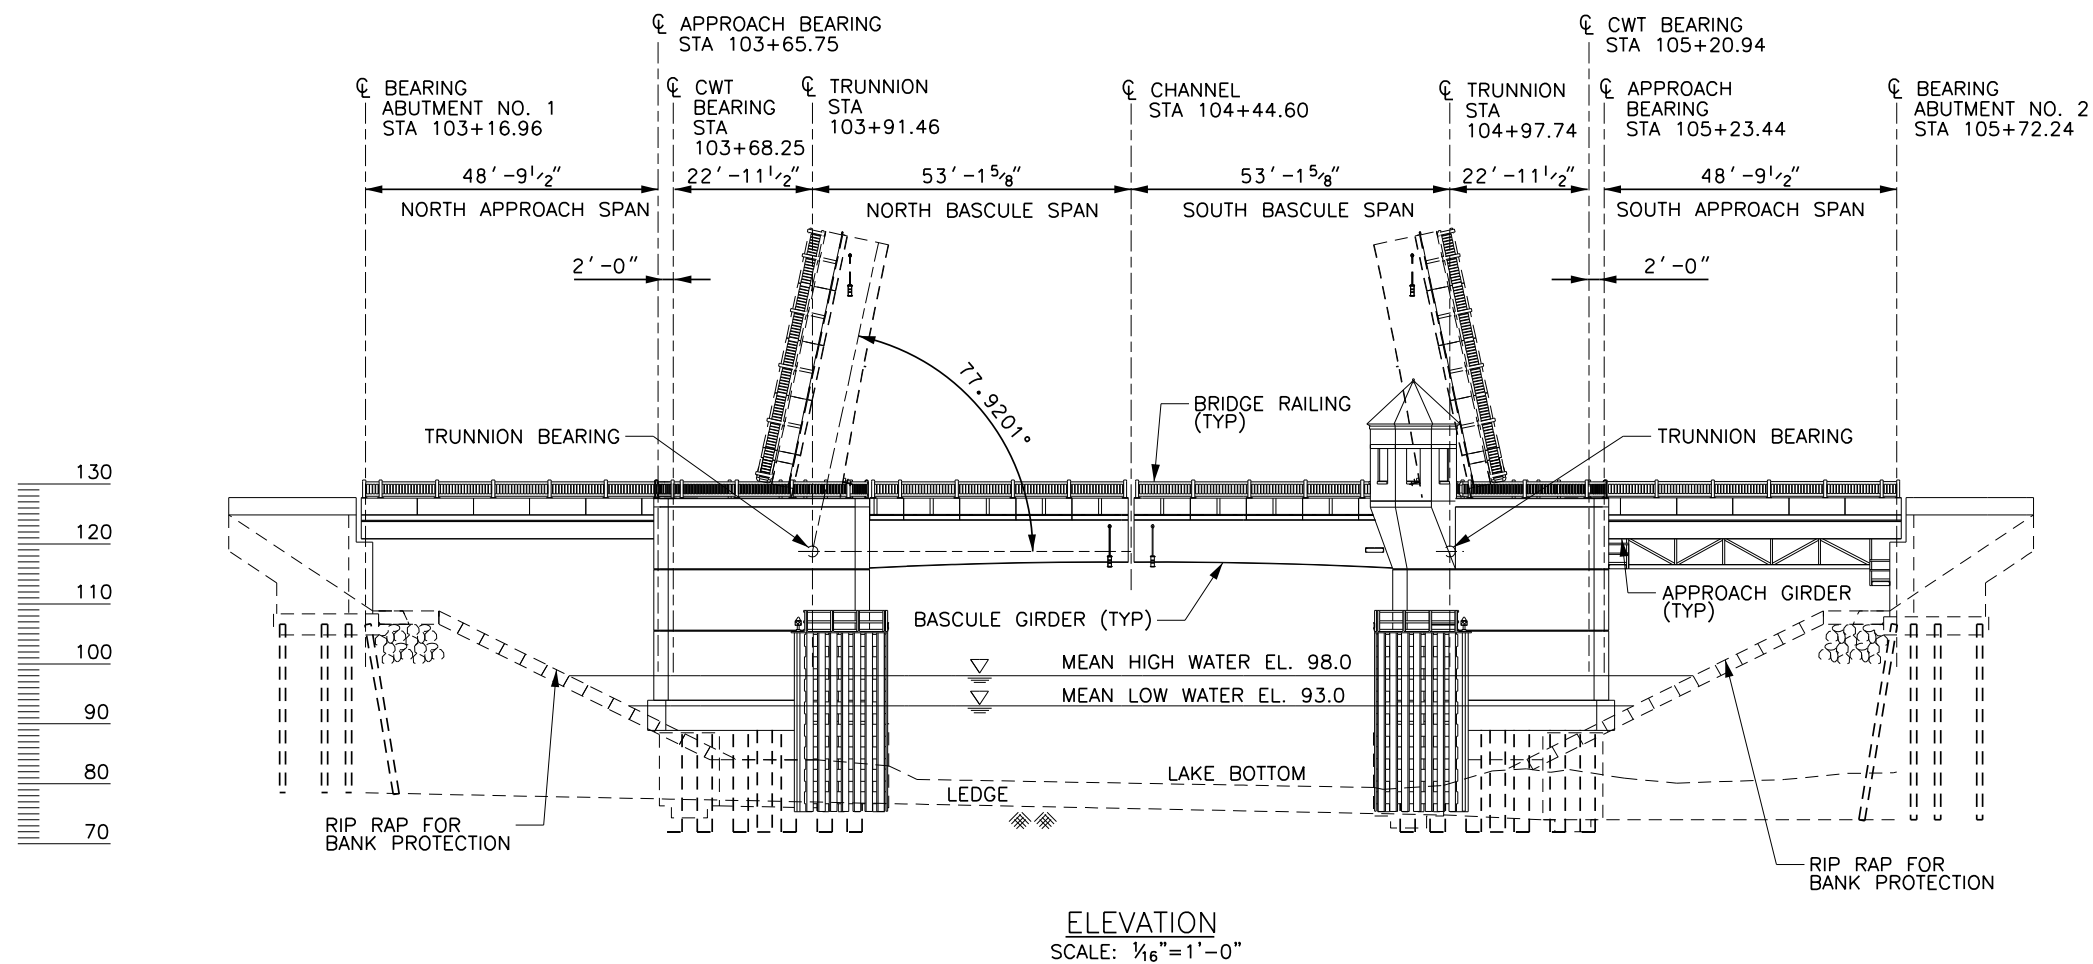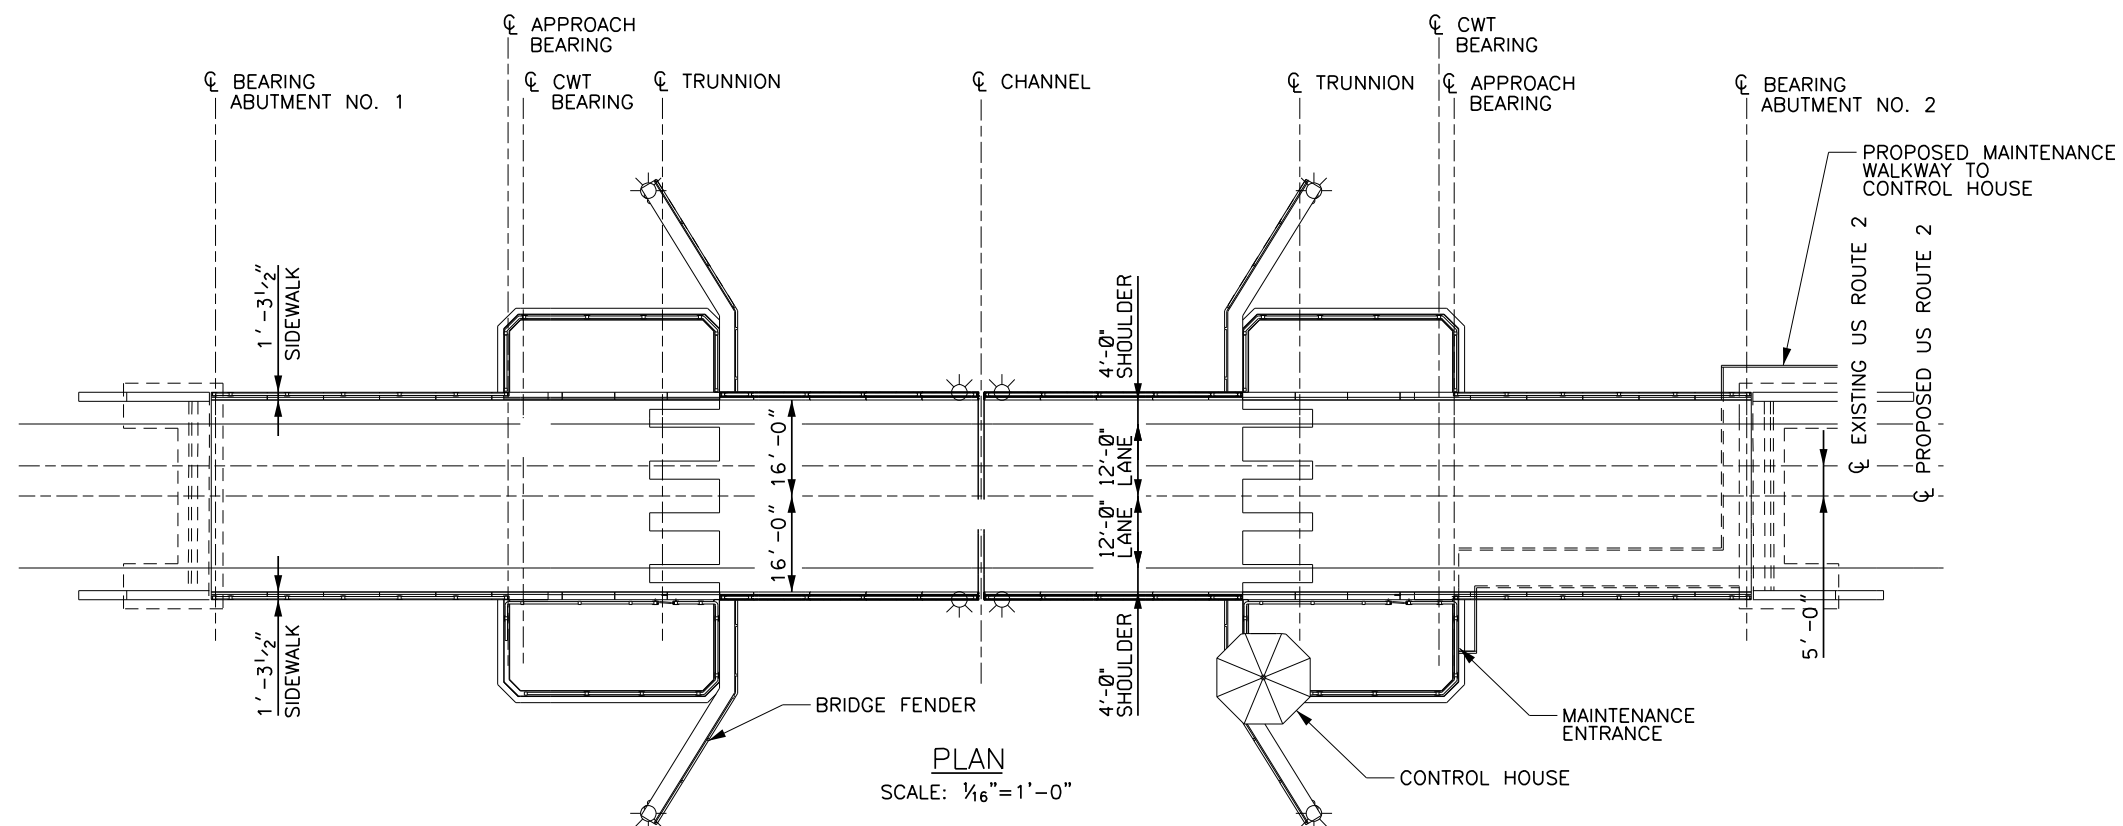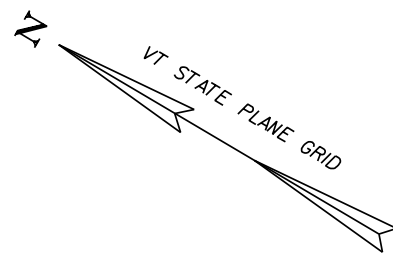

CONCEPTUAL PLANS

PROJECT NAME:	NORTH HERO GRAND ISLE BRIDGE
PROJECT NUMBER:	BHF 028-1(26)
FILE NAME:	z12b142bdr_pe.dgn
PROJECT LEADER:	C. SWANSON
DESIGNED BY:	H. PROTIN
PLAN & ELEVATION	
PLOT DATE:	7/28/2015
DRAWN BY:	P. MONTICCILOLO
CHECKED BY:	X. XXX
SHEET	5 OF 30



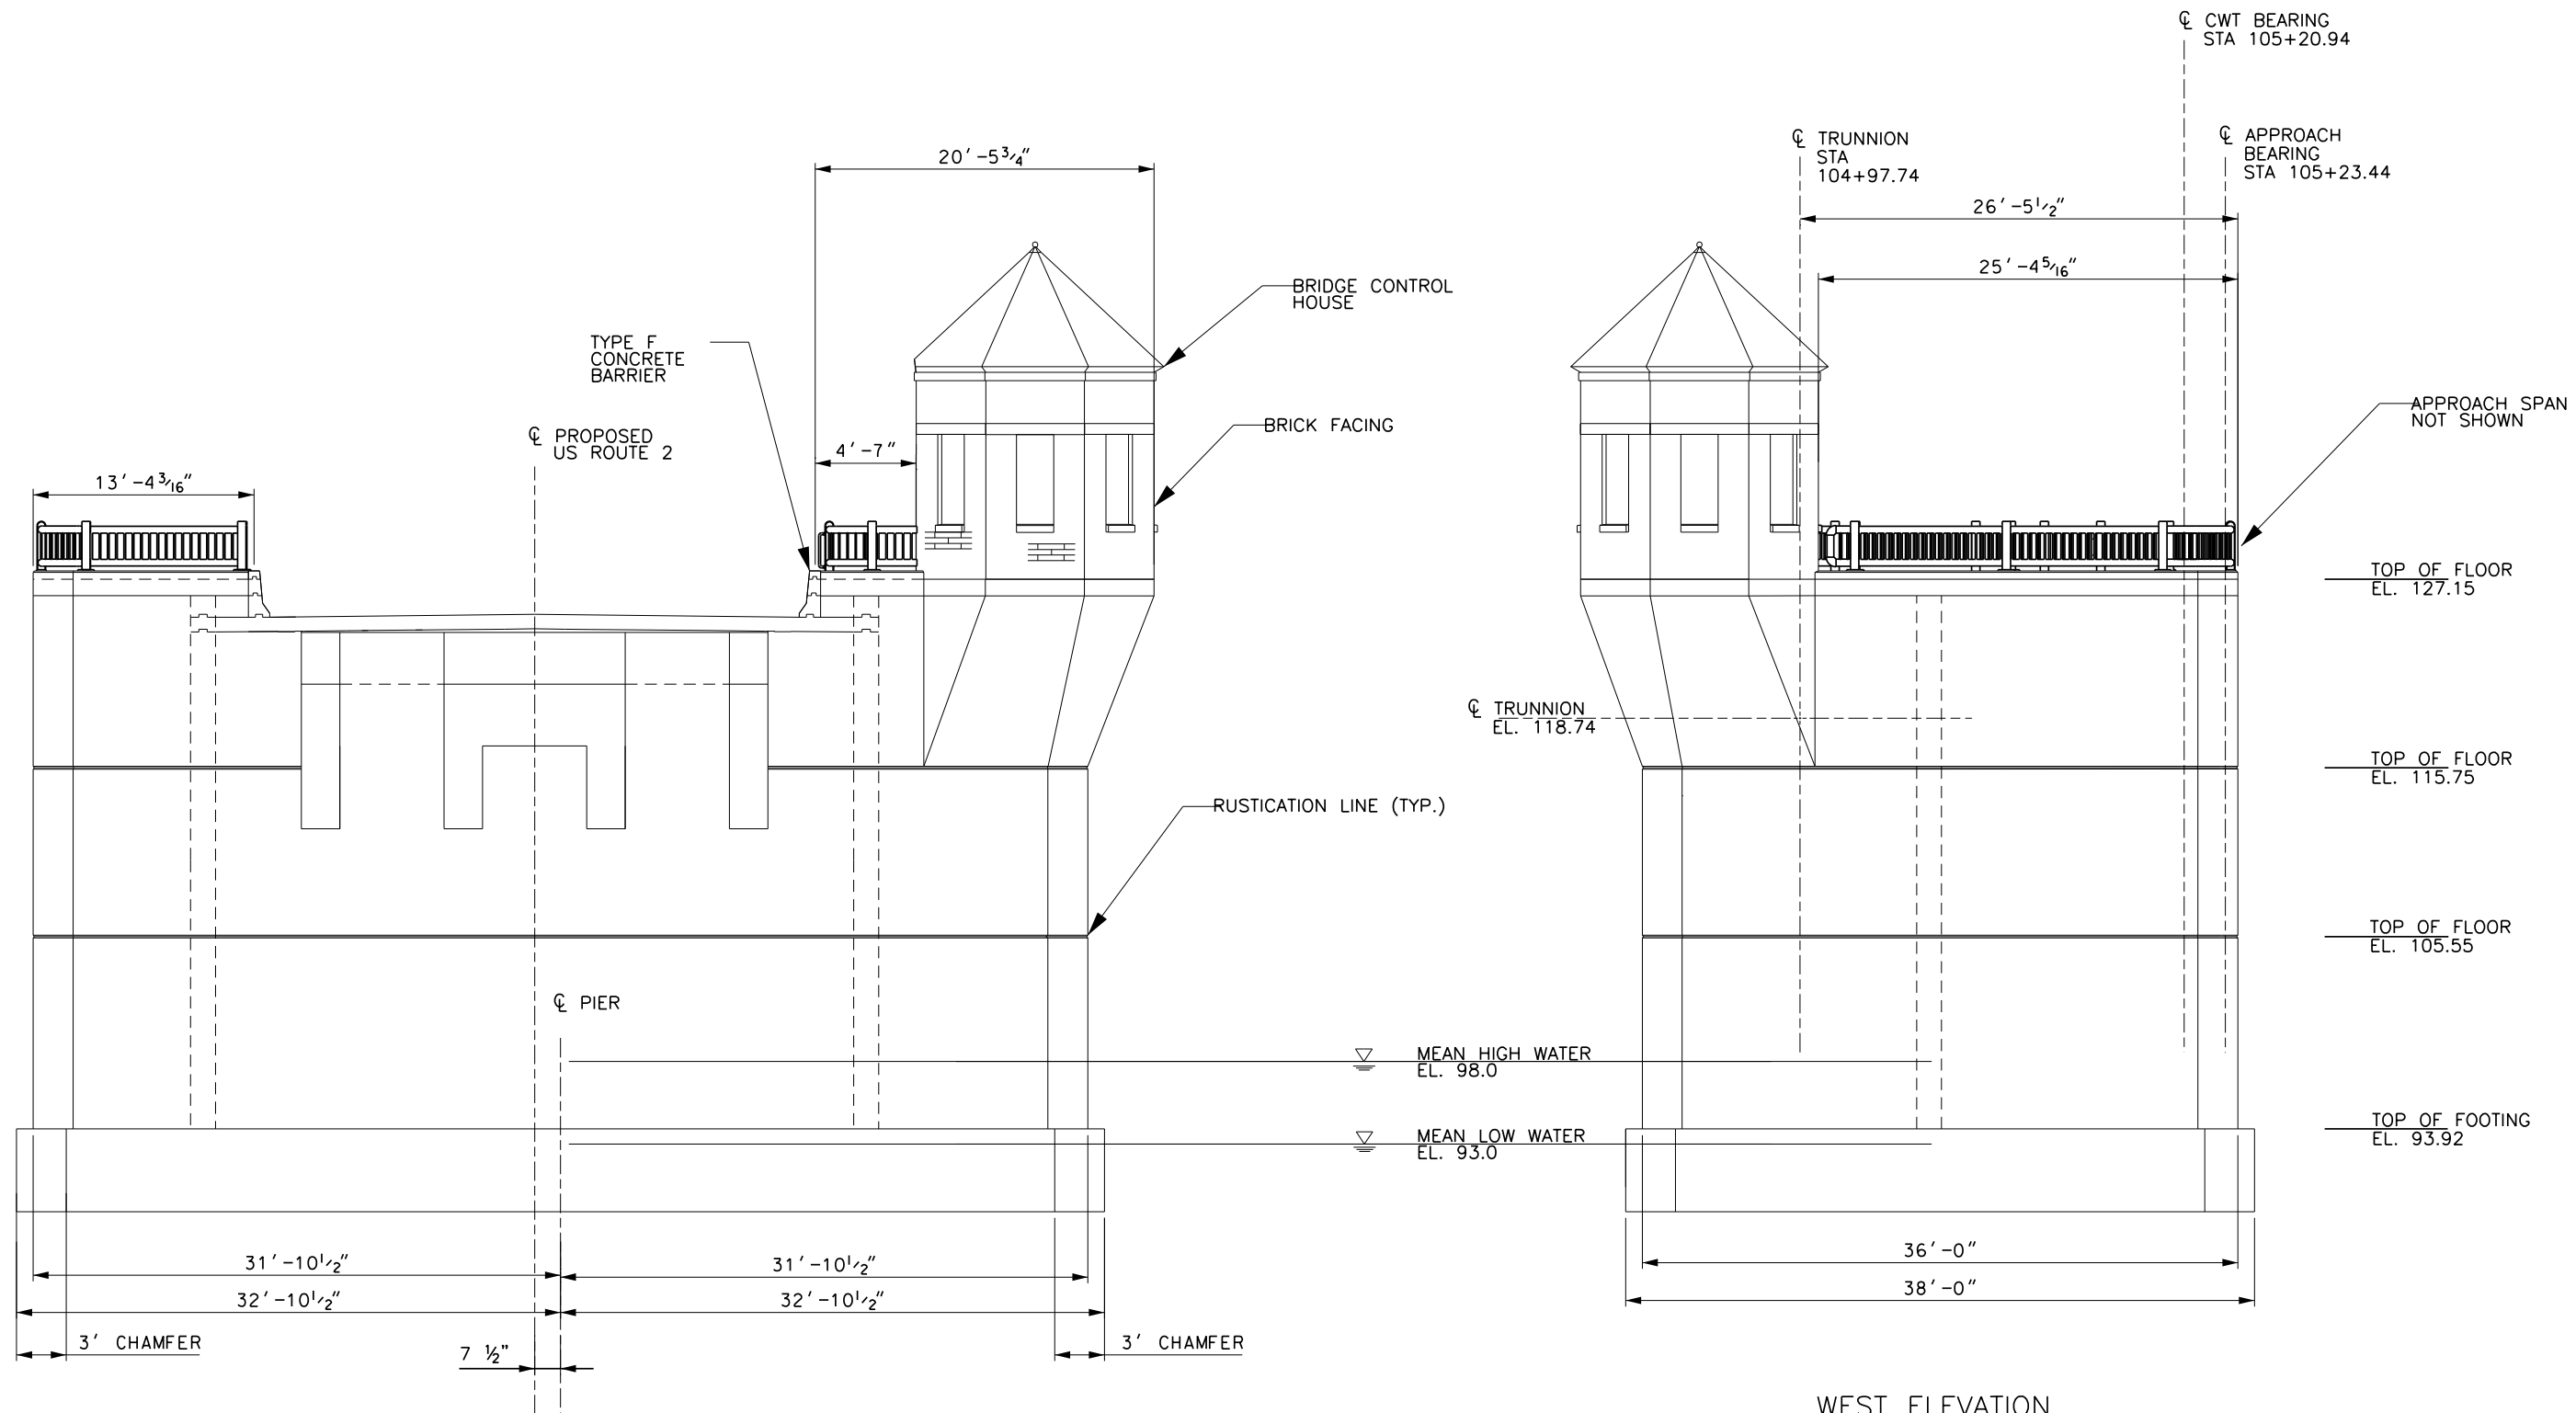

NORTH ELEVATION
SCALE: $\frac{3}{16}$ "=1'-0"


WEST ELEVATION
SCALE: $\frac{3}{16}$ "=1'-0"

NOTE:
1. FENDER SYSTEM, DRILLED SHAFTS AND
MAINTENANCE WALKWAY NOT SHOWN FOR CLARITY

CONCEPTUAL PLANS



PROJECT NAME: NORTH HERO GRAND ISLE BRIDGE	
PROJECT NUMBER: BHF 028-I(26)	
FILE NAME: Z12b142bdr_pier_elev1.dgn	PLOT DATE: 07/28/2015
PROJECT LEADER: C. SWANSON	DRAWN BY: S. SANTRICH
DESIGNED BY: H. PROTIN	CHECKED BY: XXXXXX
South Pier Elevations I	SHEET 6 OF 30

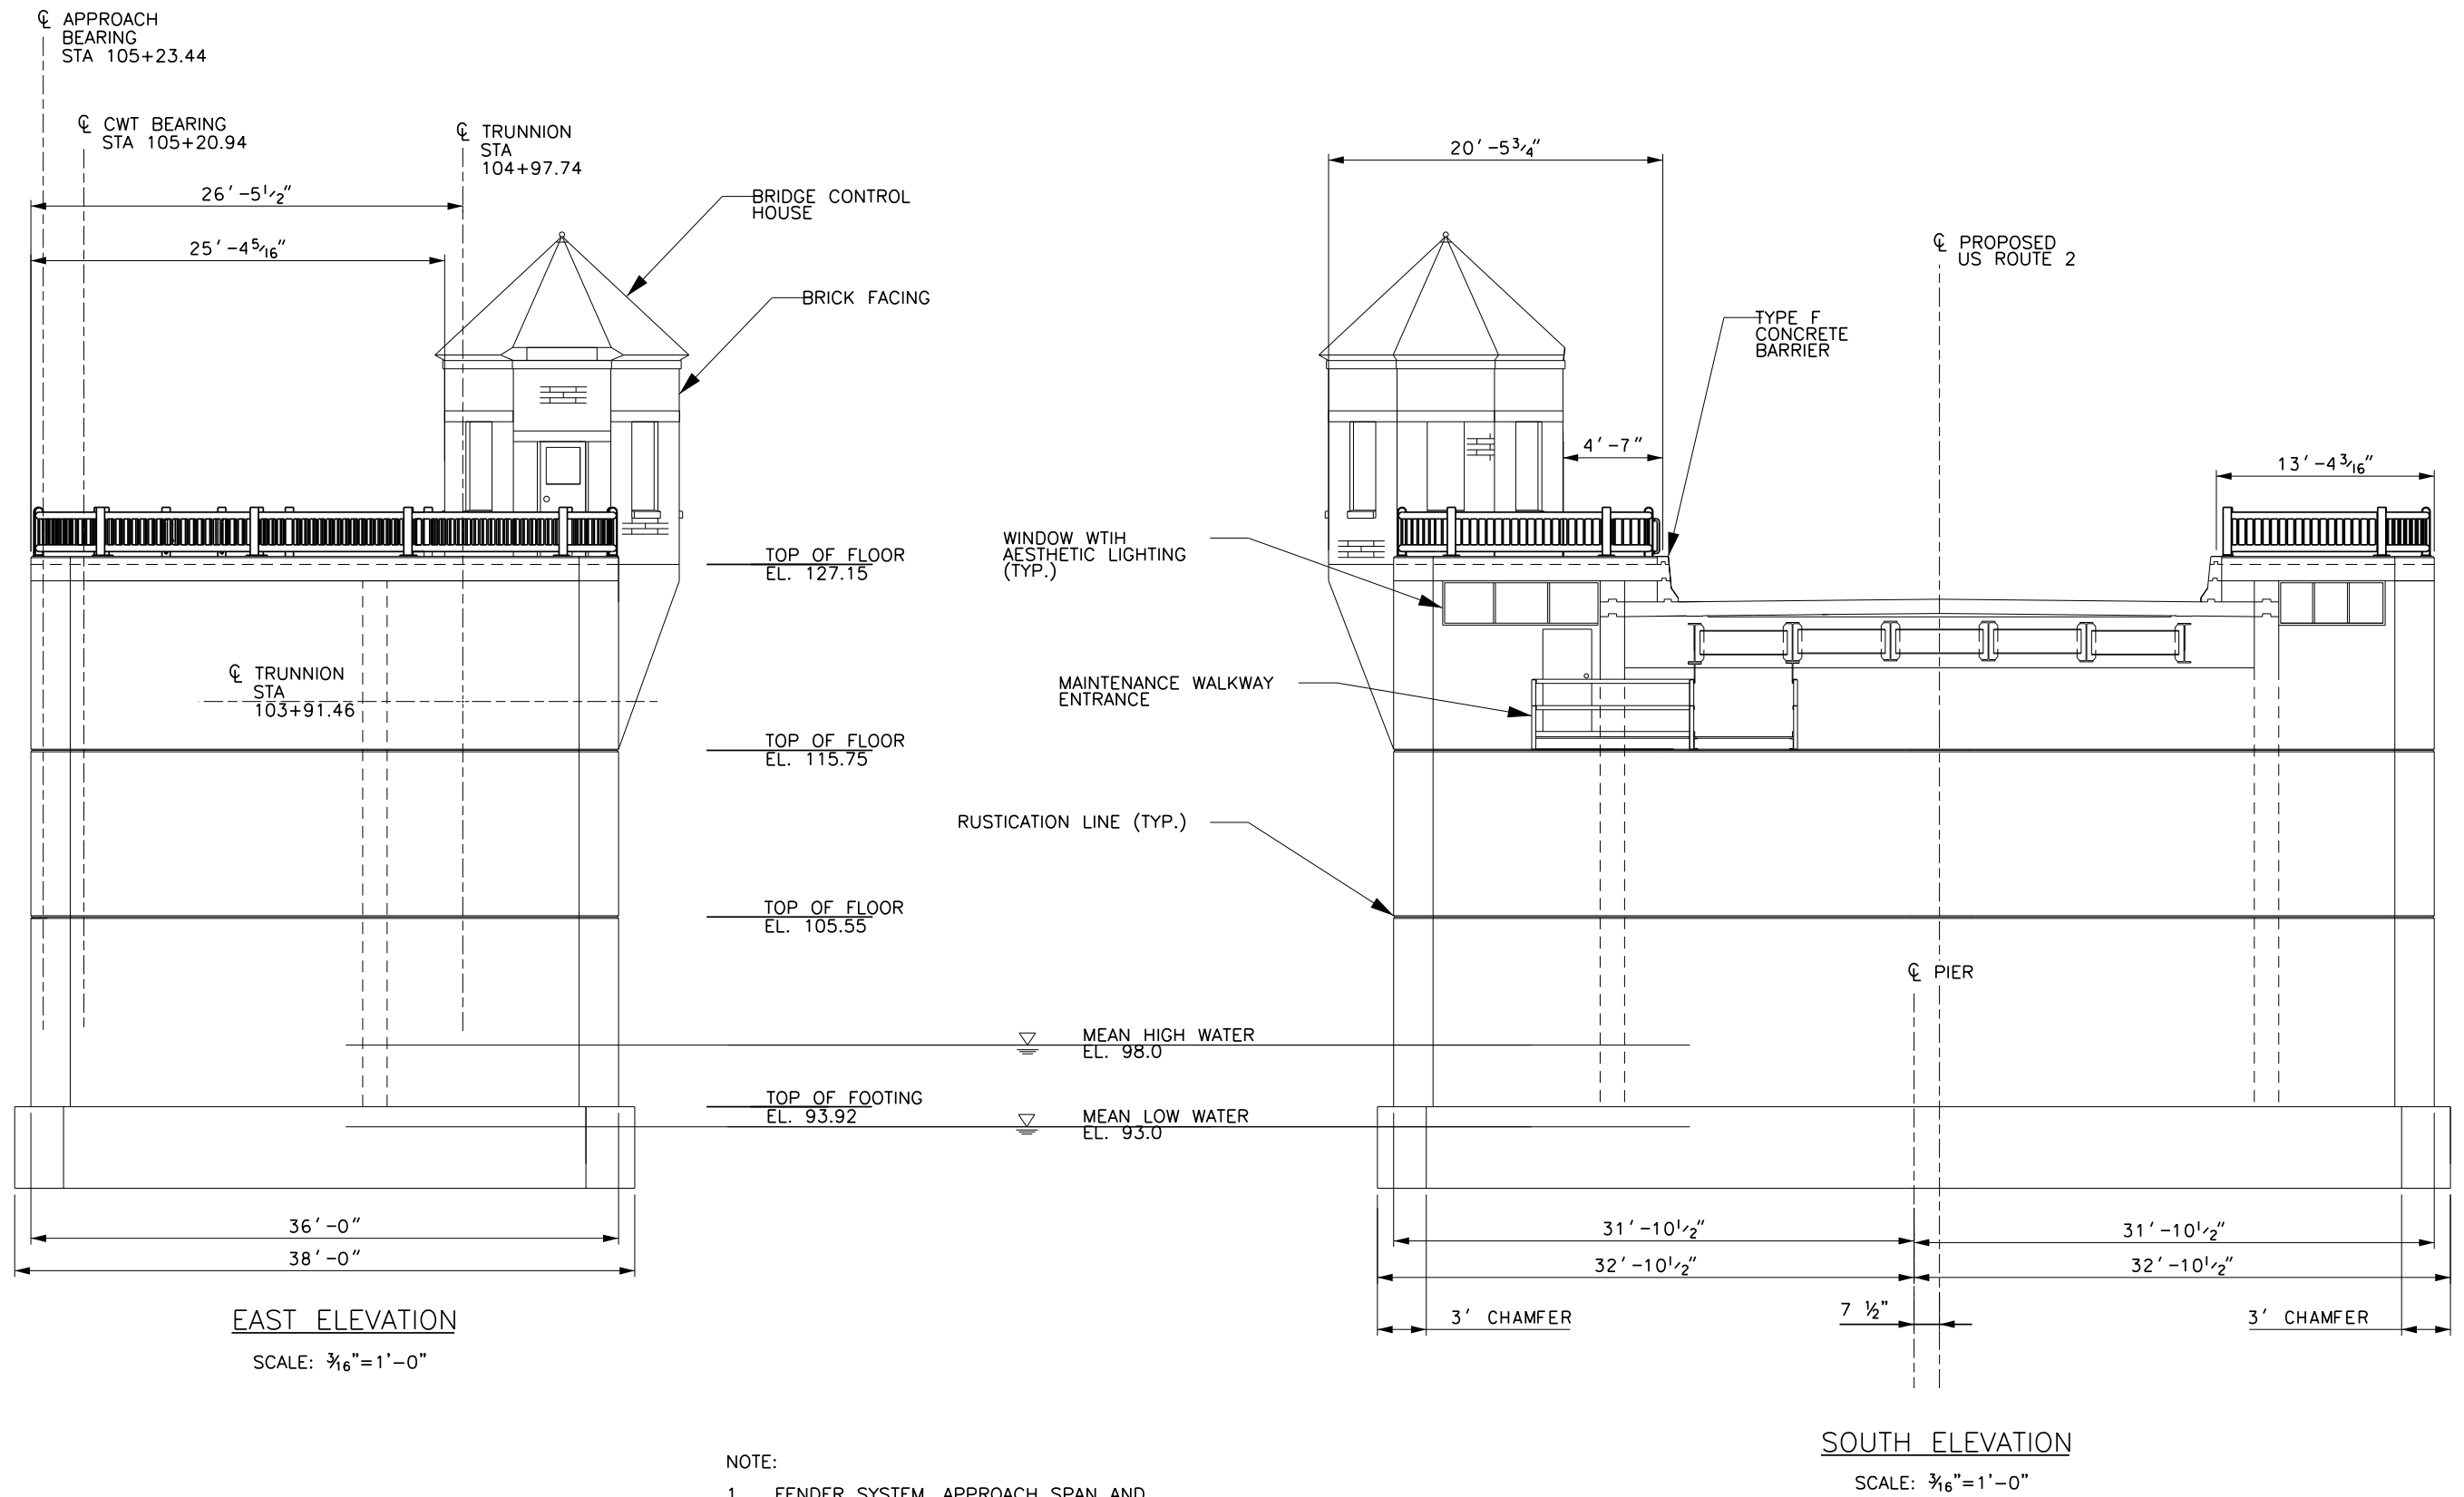


NOTE:

1. FENDER SYSTEM, APPROACH SPAN AND PILES NOT SHOWN FOR CLARITY.


CONCEPTUAL PLANS




PROJECT NAME: NORTH HERO GRAND ISLE BRIDGE	
PROJECT NUMBER: BHF 028-I(26)	
FILE NAME: Z12b142bdr_pier_elev2.dgn	PLOT DATE: 07/28/2015
PROJECT LEADER: C. SWANSON	DRAWN BY: S. SANTRICH
DESIGNED BY: H. PROTIN	CHECKED BY: XXXXXX
South Pier Elevations II	SHEET 7 OF 30

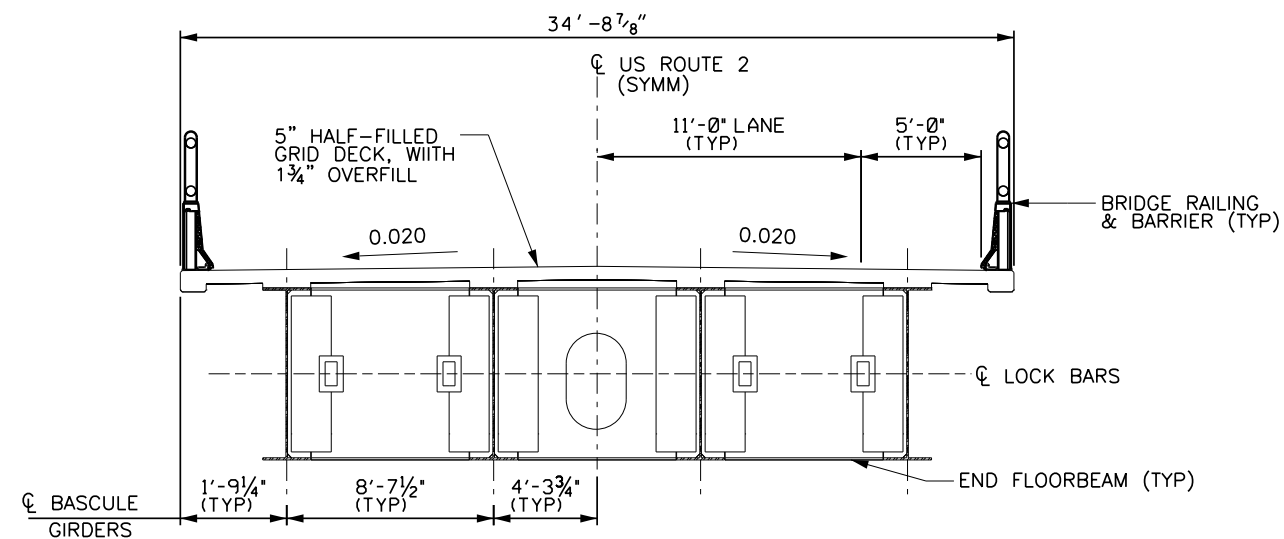

SECTION AT BASCULE SPAN
SCALE: 1/4"=1'-0"

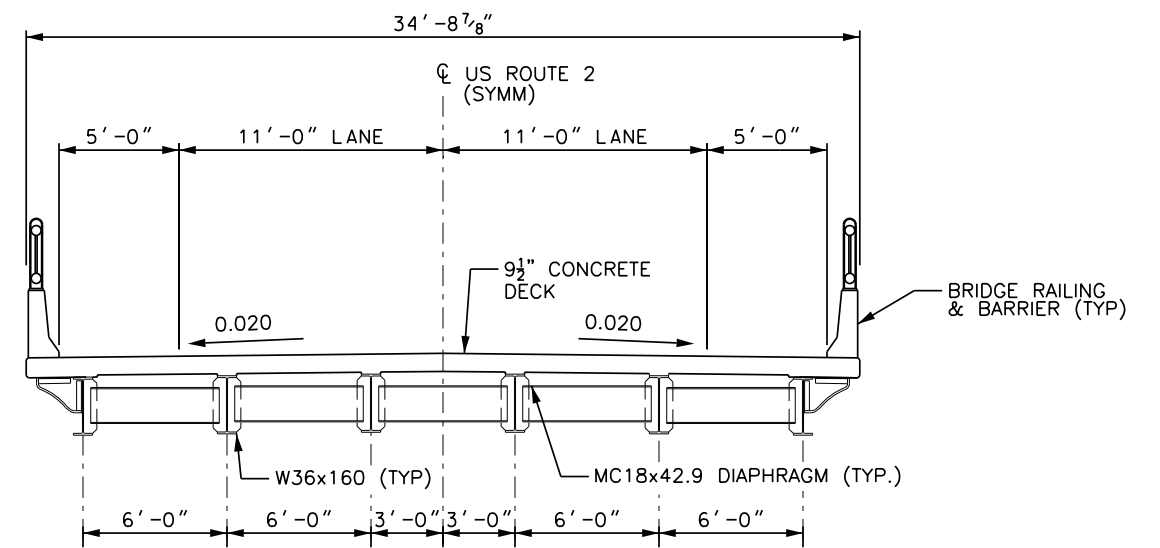

SECTION AT APPROACH SPAN
SCALE: 1/4"=1'-0"


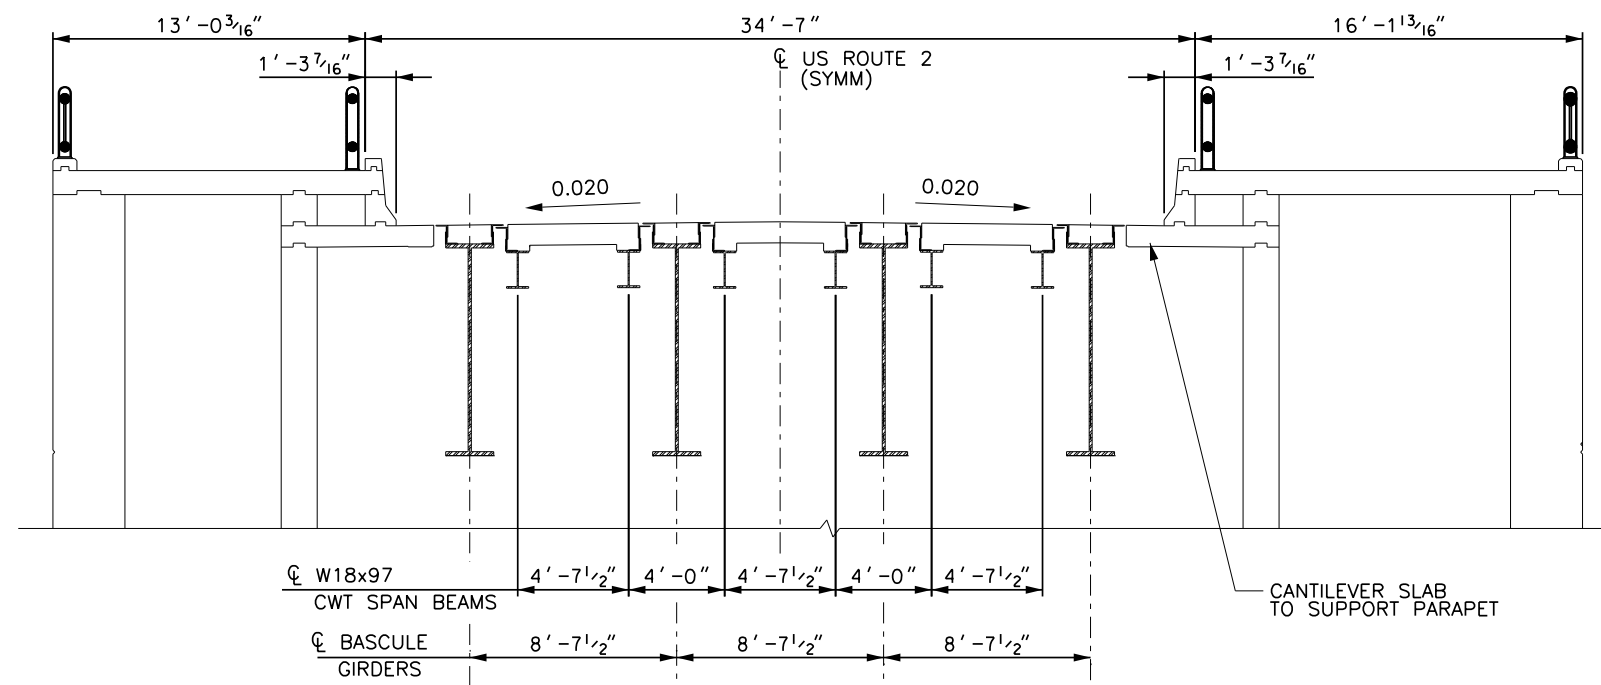


SECTION AT CWT SPAN
SCALE: 1/4"=1'-0"

CONCEPTUAL PLANS



PROJECT NAME: NORTH HERO GRAND ISLE BRIDGE	
PROJECT NUMBER: BHF 028-1(26)	
FILE NAME: z12b142bdr_detail1.dgn	PLOT DATE: 7/28/2015
PROJECT LEADER: C. SWANSON	DRAWN BY: C. D'AMBROSIO
DESIGNED BY: H. PROTIN	CHECKED BY: G. NICKELS
BRIDGE TYPICAL SECTIONS	SHEET 8 OF 30

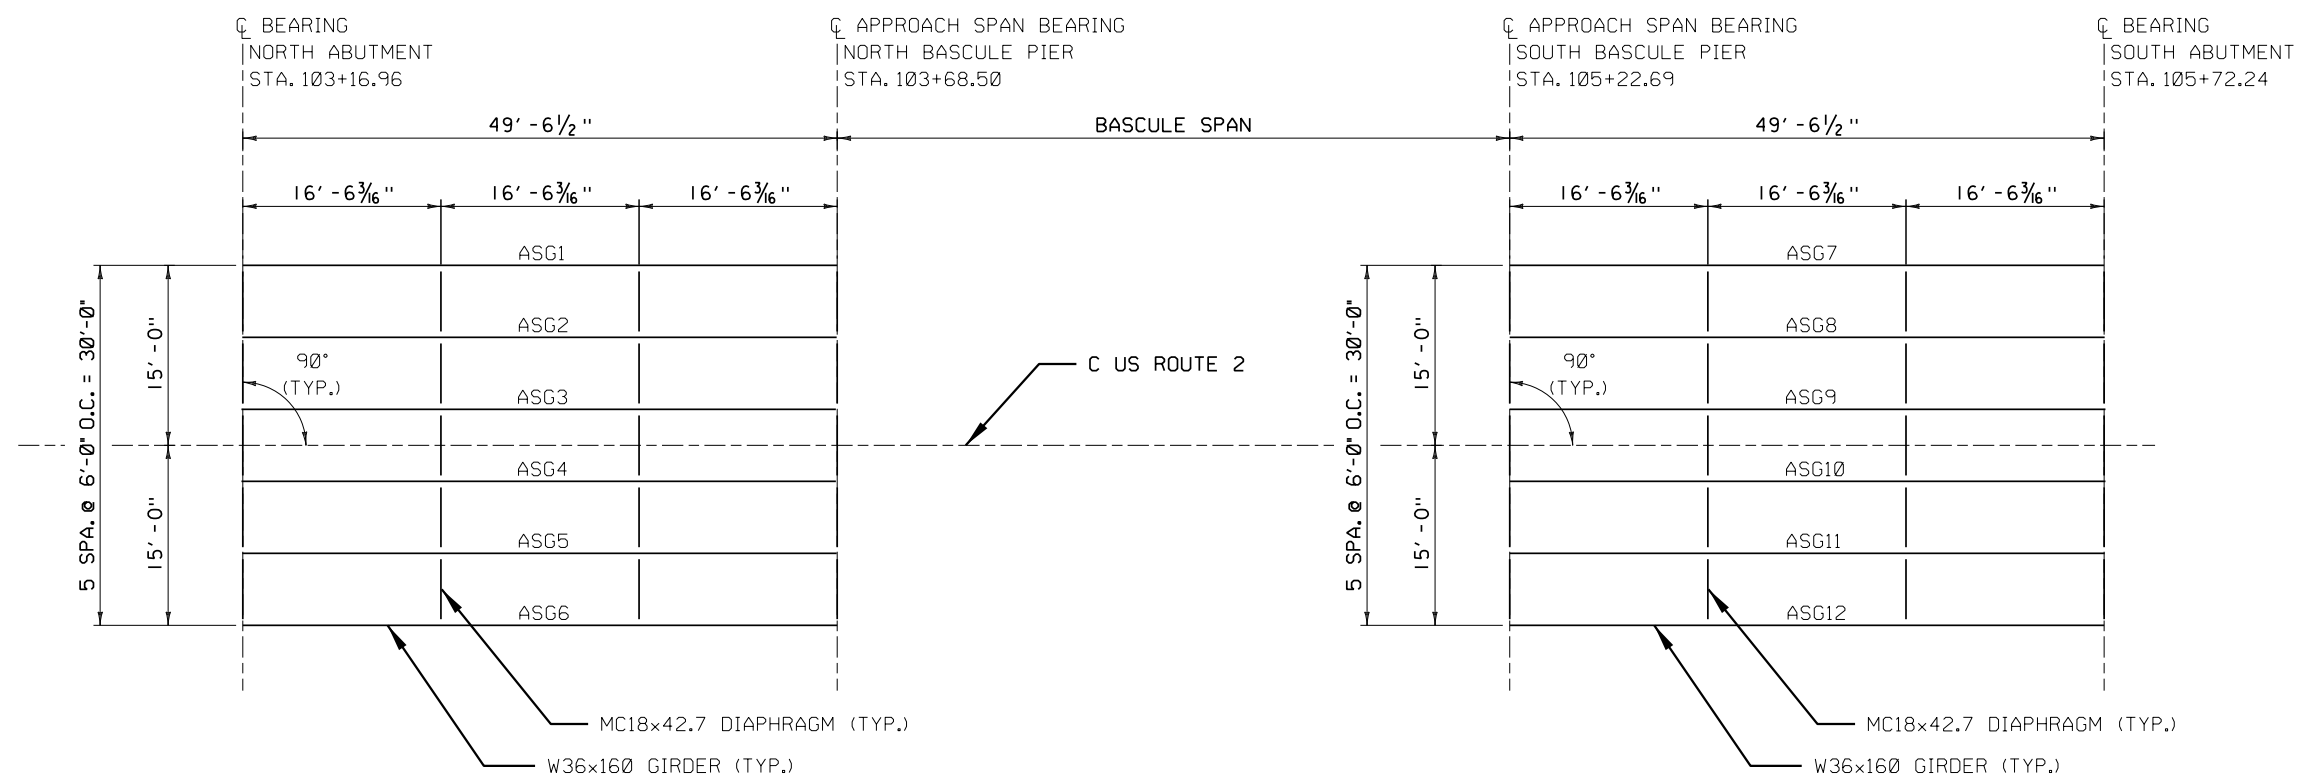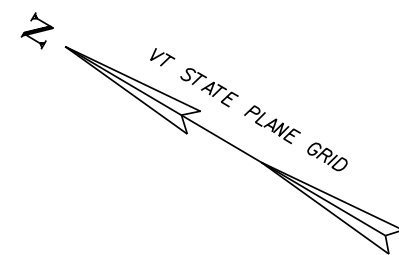

NORTH APPROACH SPAN FRAMING PLAN

SCALE $\frac{1}{8}'' = 1' - 0''$
1 0 2 4 6 8


SOUTH APPROACH SPAN FRAMING PLAN

SCALE $\frac{1}{8}'' = 1' - 0''$
1 0 2 4 6 8

CONCEPTUAL PLANS




PROJECT NAME: NORTH HERO GRAND ISLE BRIDGE	
PROJECT NUMBER: BHF 028-1(26)	
FILE NAME: Z12b142bdr_ pl2.dgn	PLOT DATE: 7/28/2015
PROJECT LEADER: C. SWANSON	DRAWN BY: K. KRETSCH
DESIGNED BY: C. SWANSON	CHECKED BY: C. SWANSON
APPROACH SPANS FRAMING PLAN	SHEET 9 OF 30

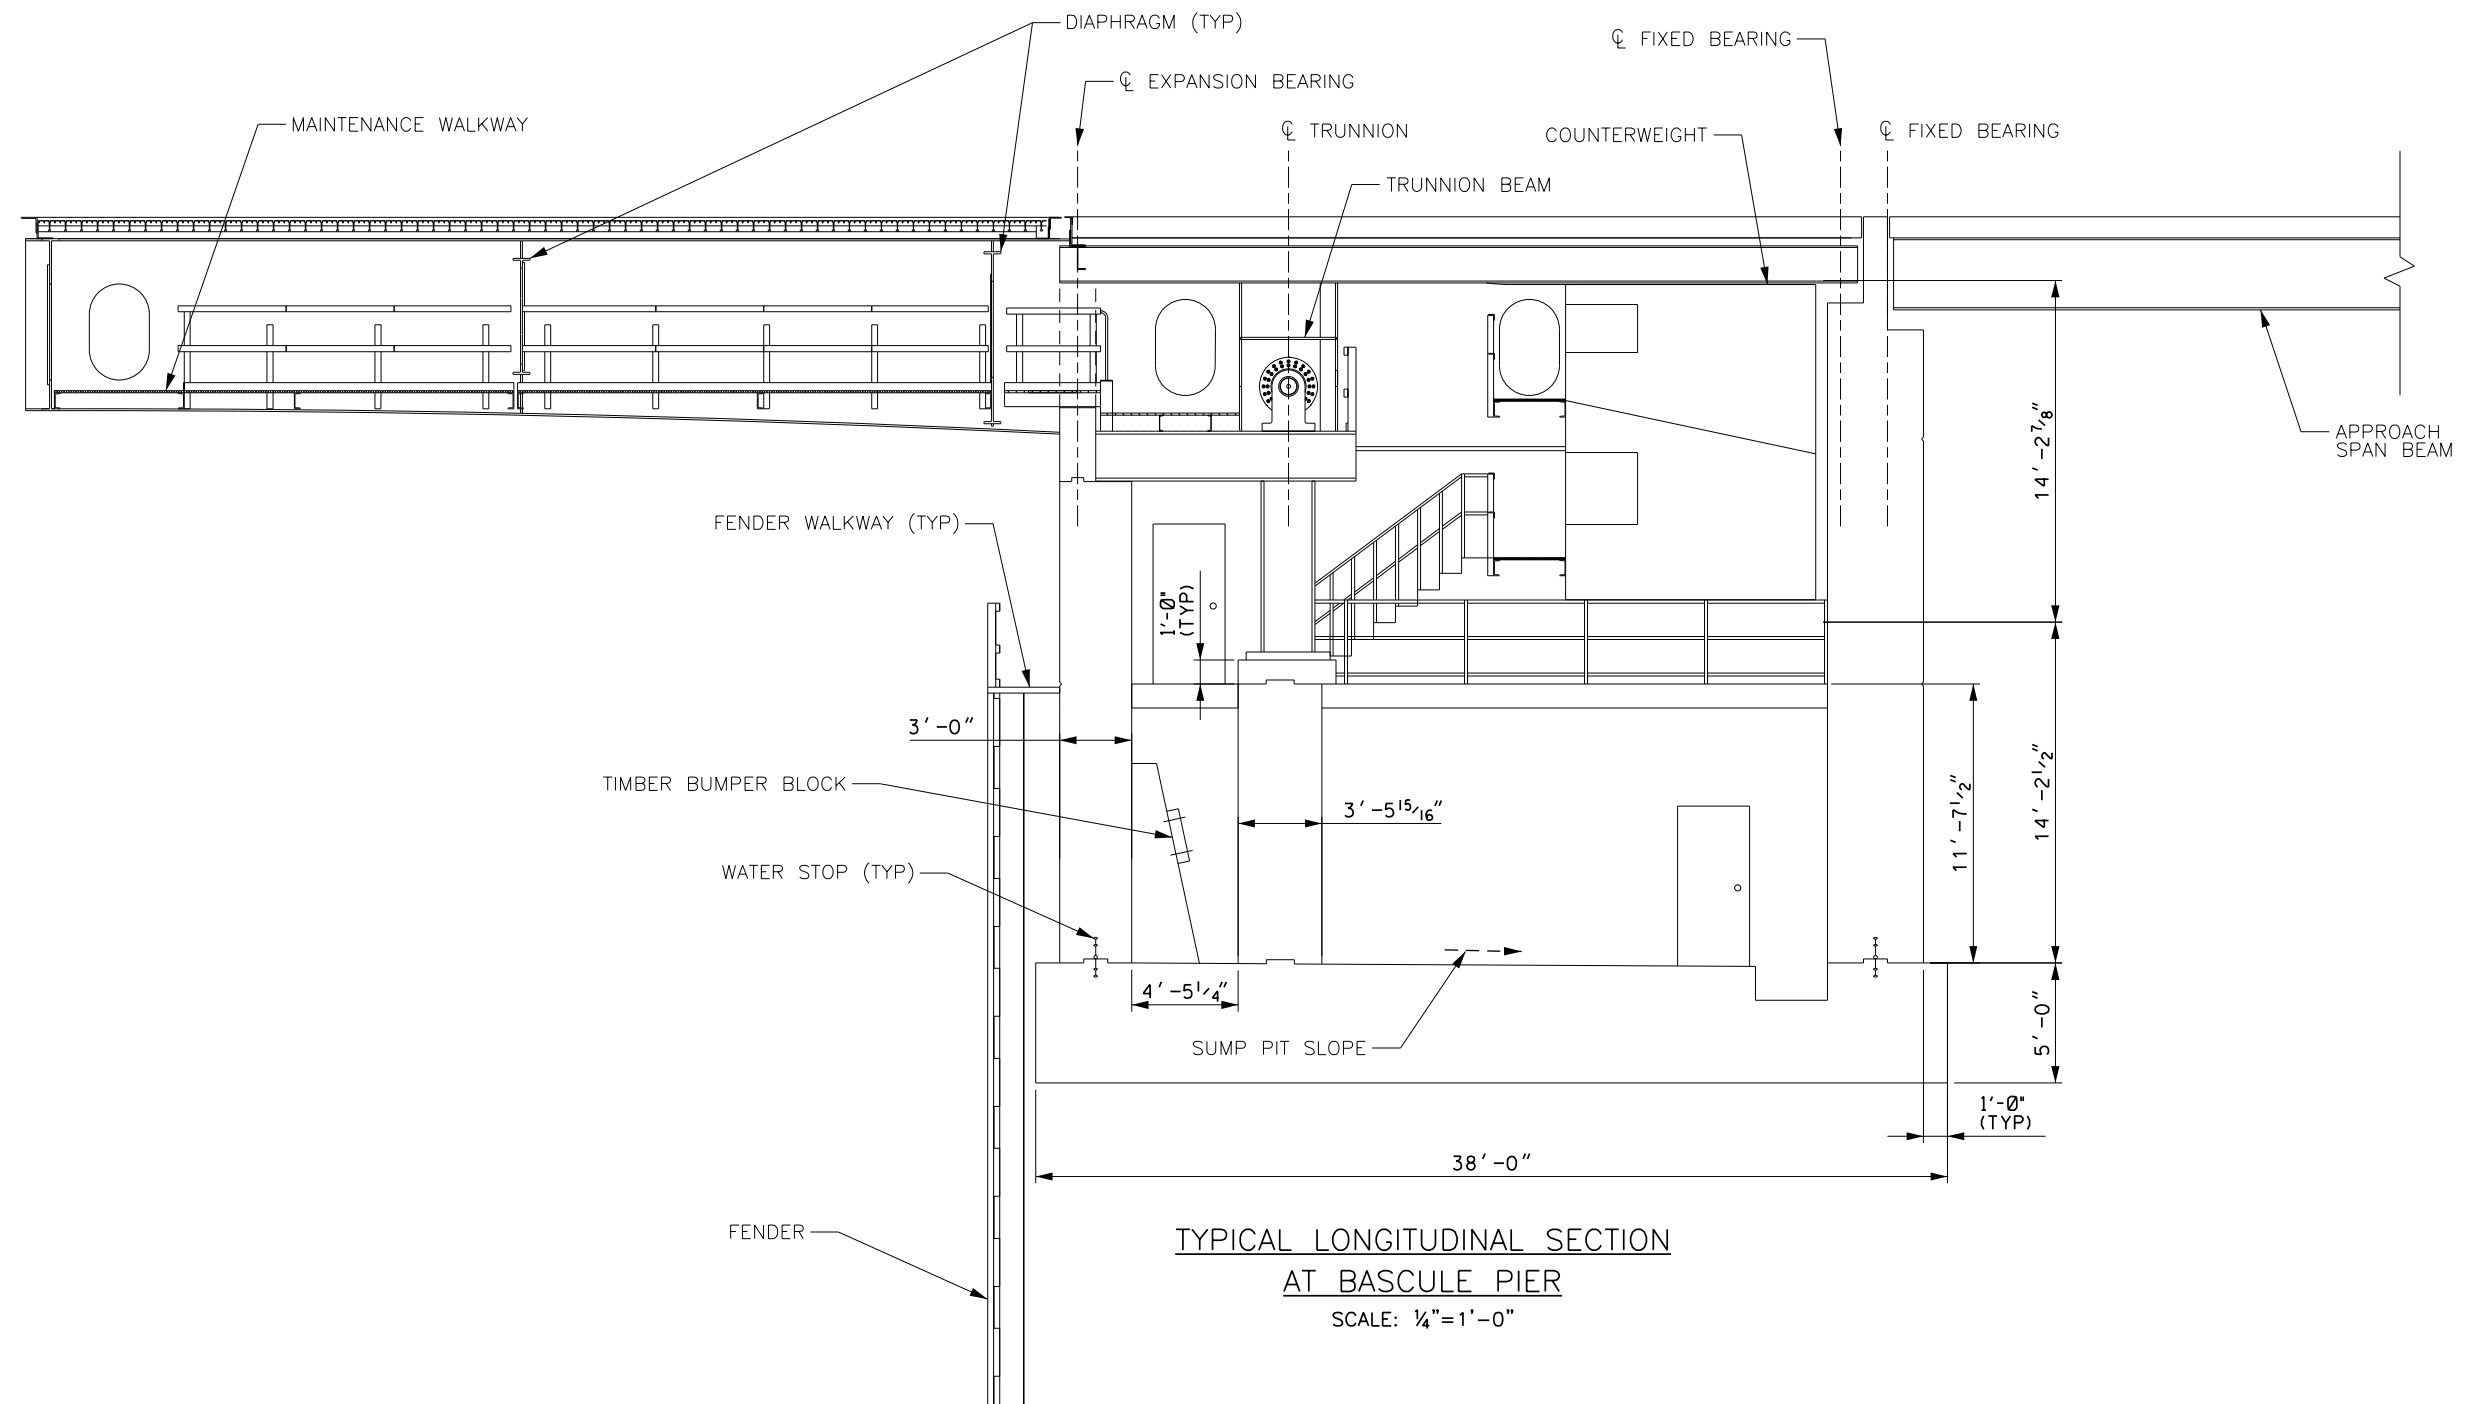

CONCEPTUAL PLANS



PROJECT NAME: NORTH HERO GRAND ISLE BRIDGE	
PROJECT NUMBER: BHF 028-1(26)	
FILE NAME: z12b142bdr_xs1.dgn	PLOT DATE: 07/28/2015
PROJECT LEADER: C. SWANSON	DRAWN BY: S. SANTRICH
DESIGNED BY: H. PROTIN	CHECKED BY: XXXXXX
BASCULE SPAN LONGITUDINAL SECTION	SHEET II OF 30

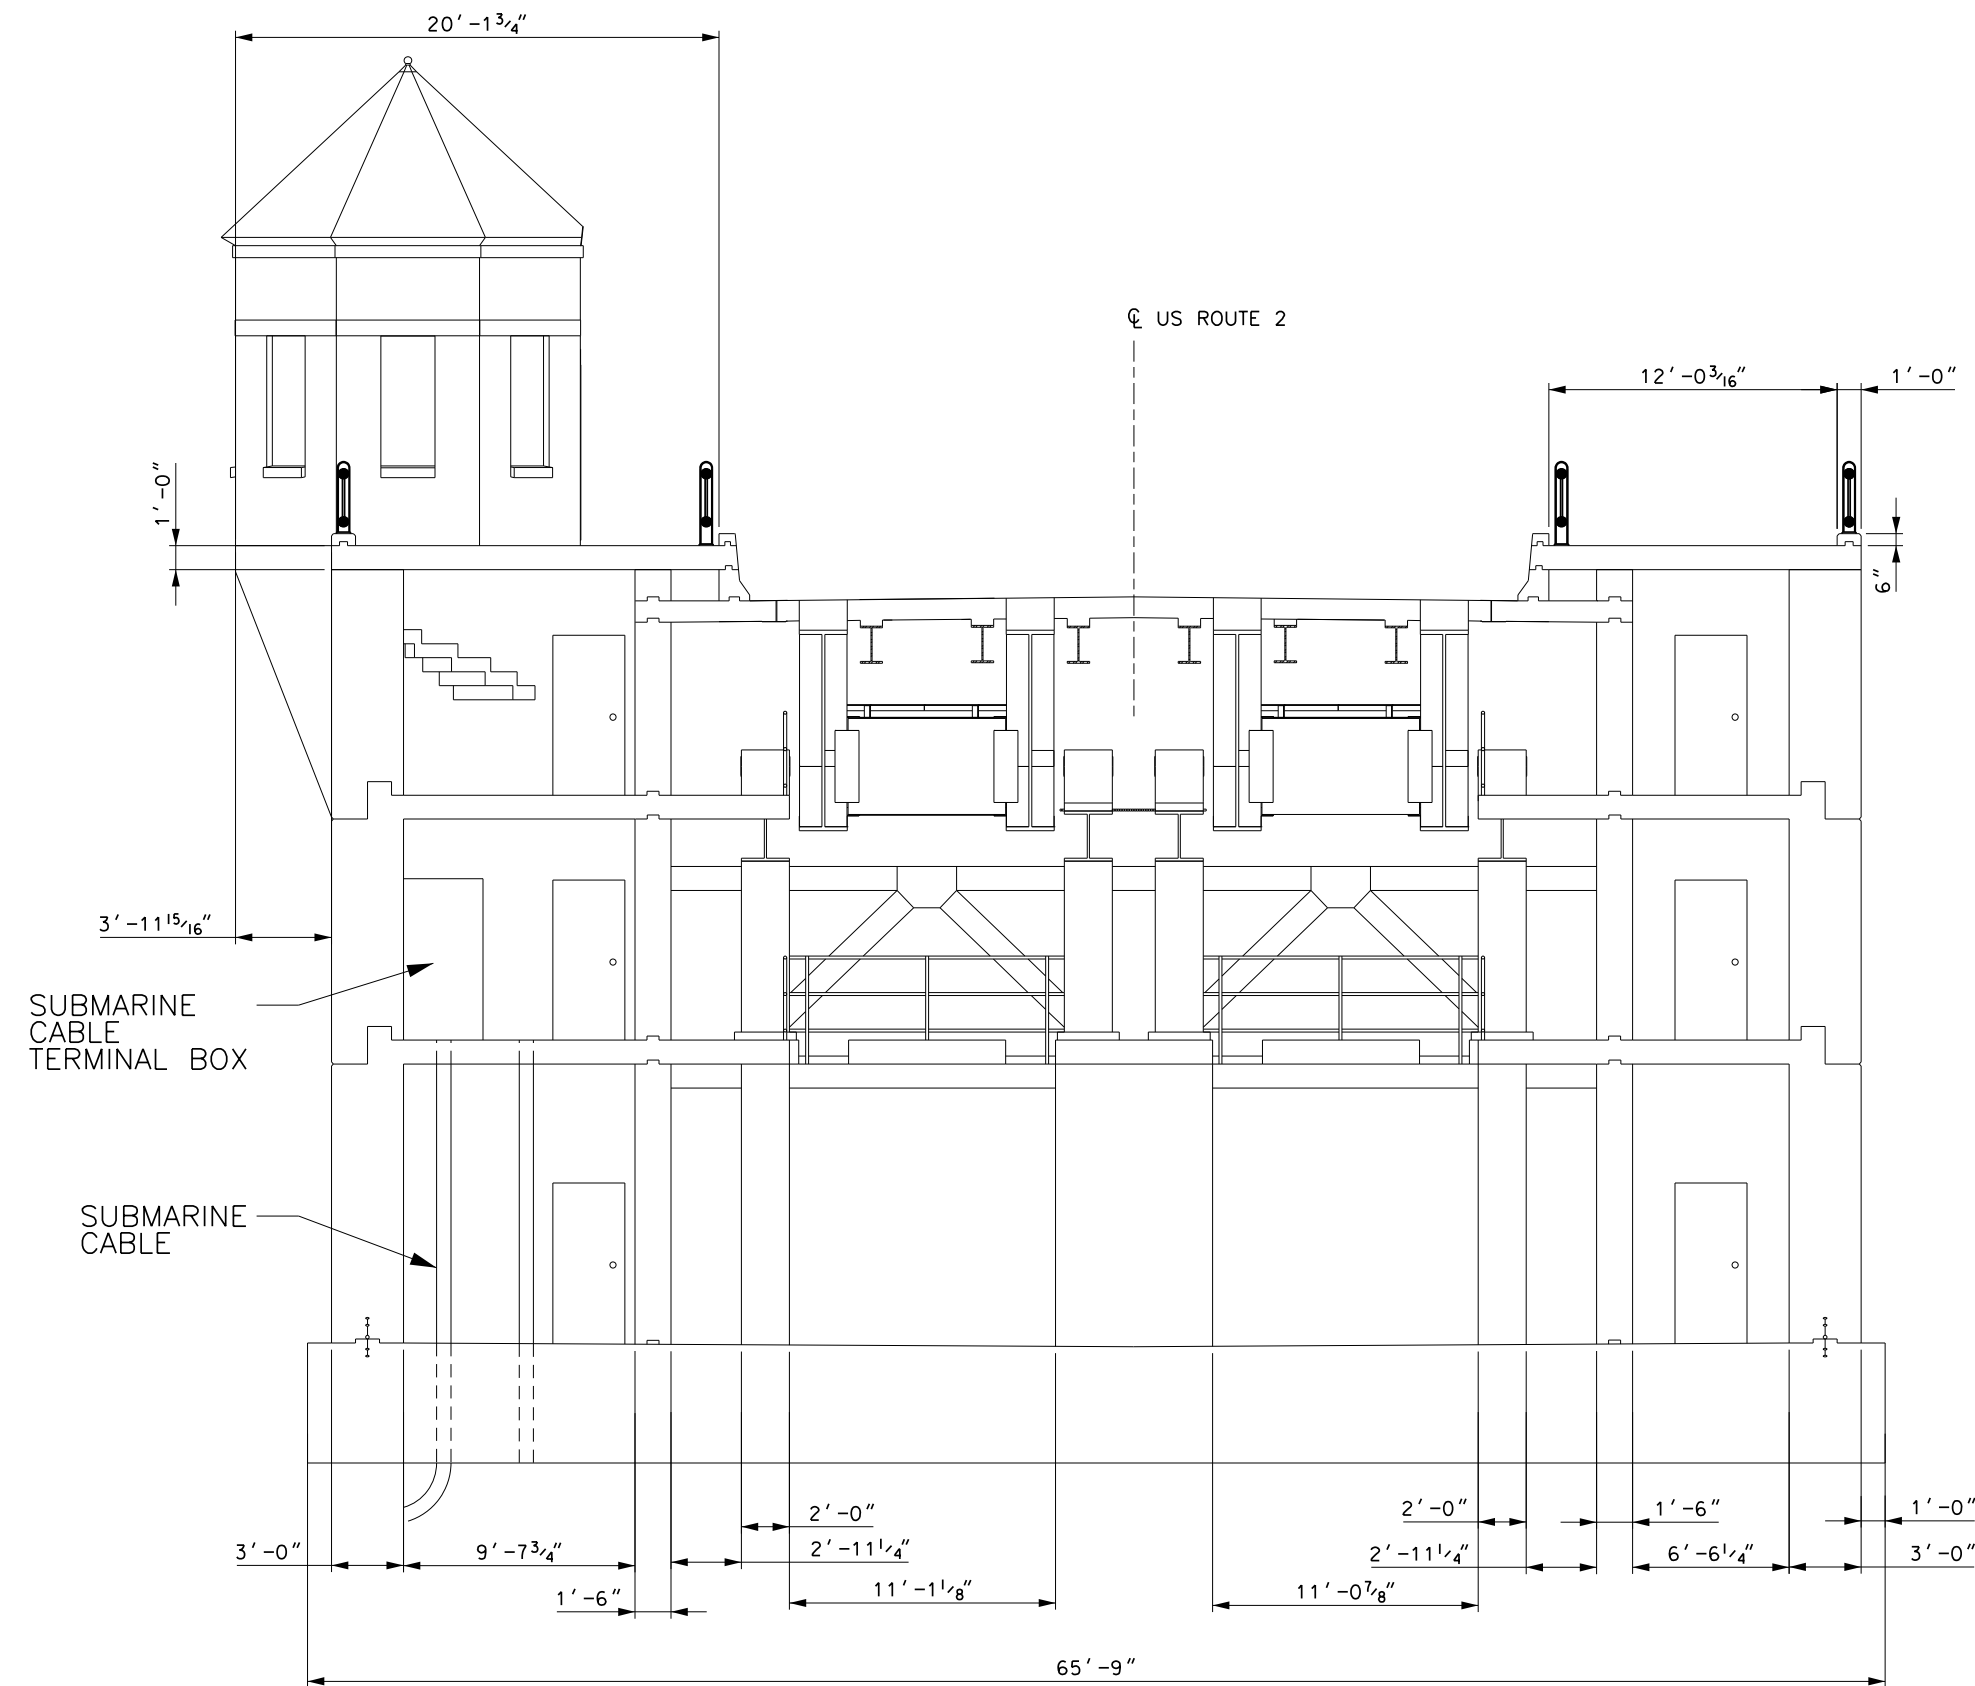


TYPICAL TRANSVERSE SECTION
AT BASCULE PIER
SCALE: 1/4"=1'-0"


CONCEPTUAL PLANS

PROJECT NAME:	NORTH HERO GRAND ISLE BRIDGE
PROJECT NUMBER:	BHF 028-1(26)
FILE NAME:	z12b142bdr_xs2.dgn
PROJECT LEADER:	C. SWANSON
DESIGNED BY:	H. PROTIN
BASCULE SPAN TRANSVERSE SECTION	
PLOT DATE:	7/28/2015
DRAWN BY:	S. SANTRICH
CHECKED BY:	XXXXX
SHEET	12 OF 30



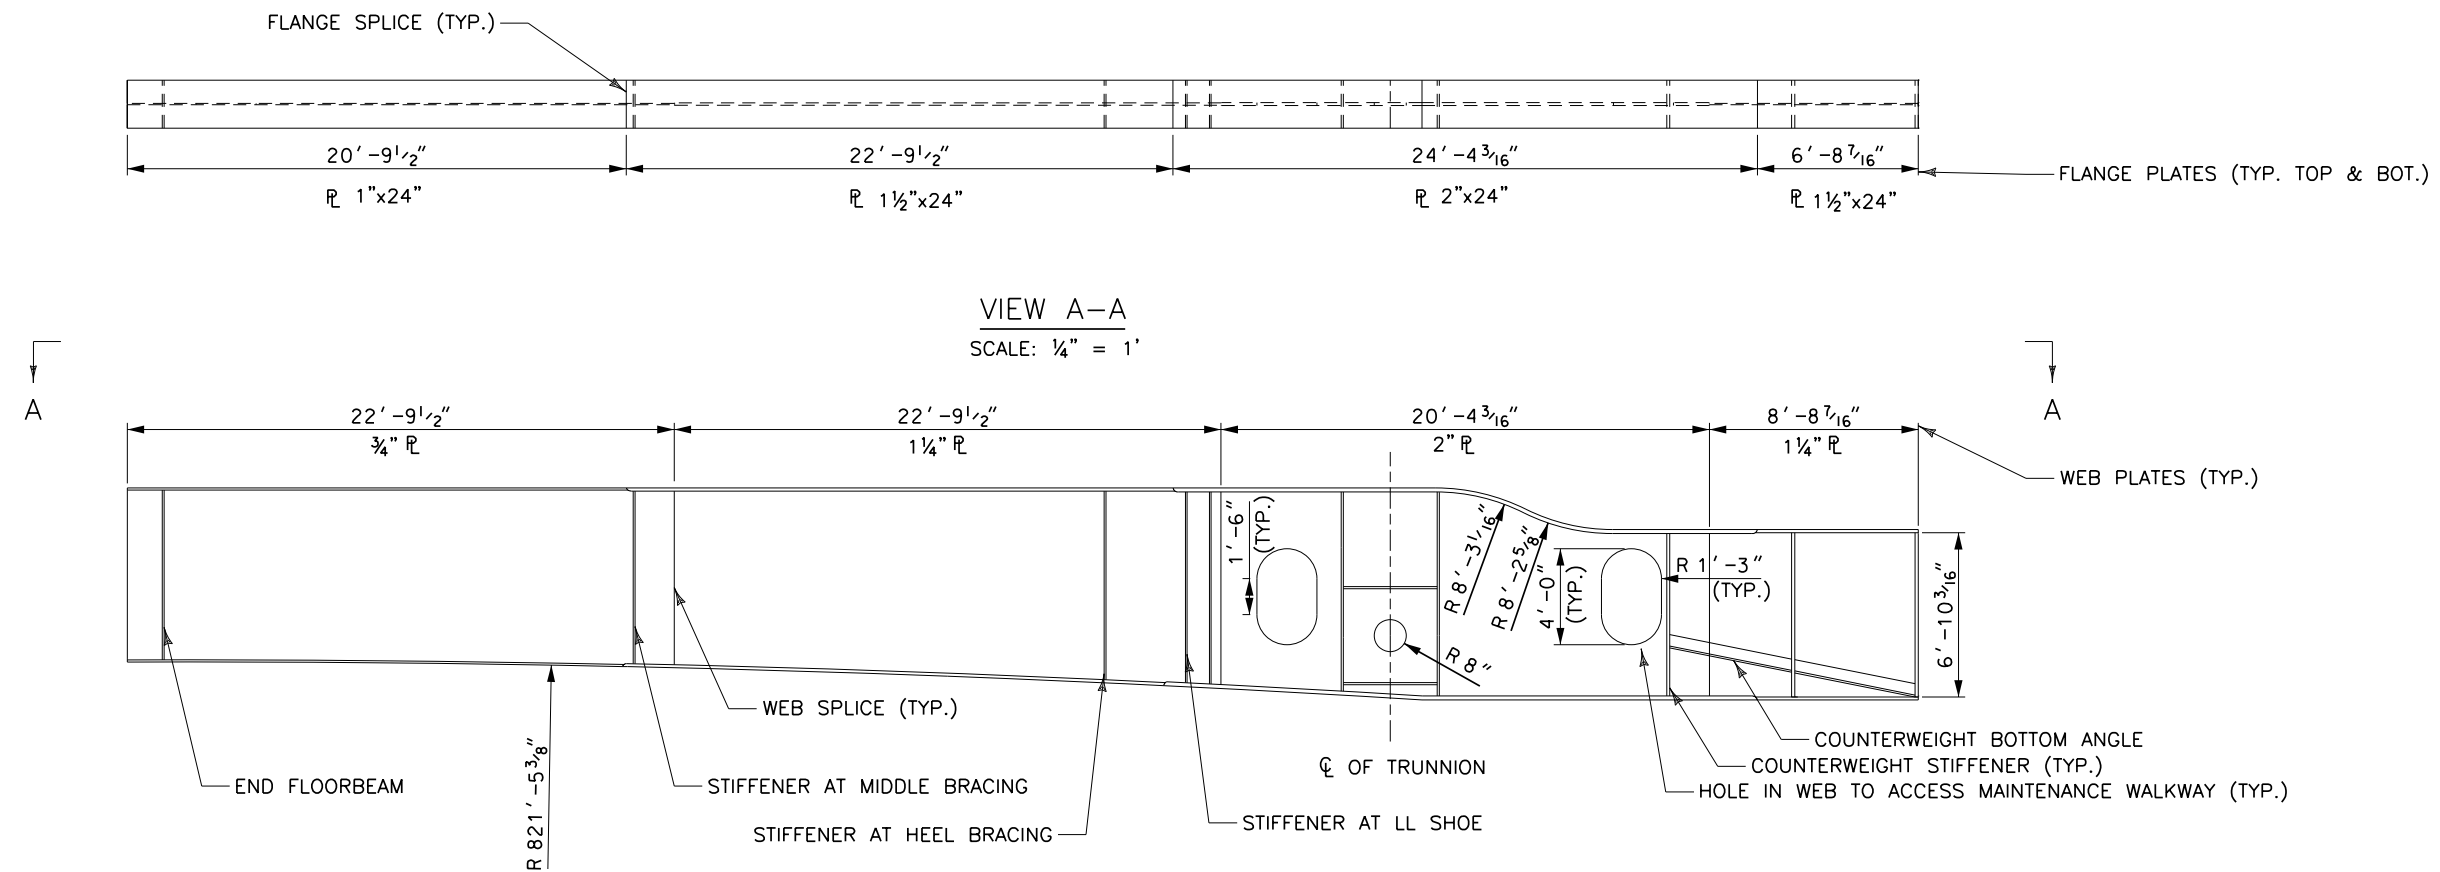


EXTERIOR BASCULE GIRDER ELEVATION
SCALE: 1/4" = 1'

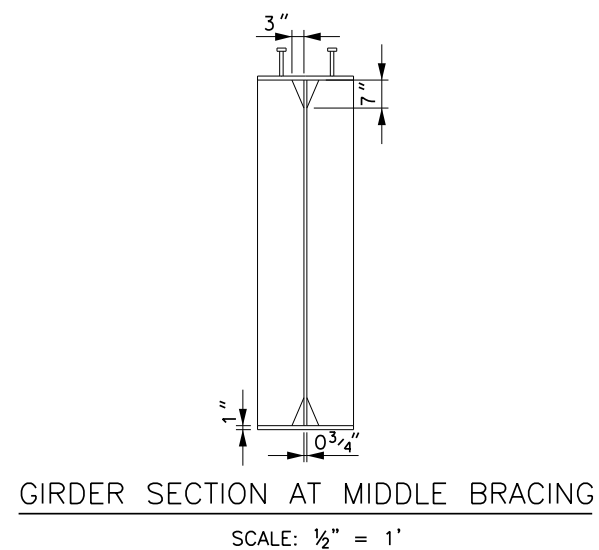

CONCEPTUAL PLANS


PROJECT NAME:	NORTH HERO GRAND ISLE BRIDGE
PROJECT NUMBER:	BHF 028-1(26)
FILE NAME:	z12b142bdr_girder_details1.dgn
PROJECT LEADER:	C. SWANSON
DESIGNED BY:	H. PROTIN
Bascule Span Girder Details (1 of 2)	
PLOT DATE:	7/28/2015
DRAWN BY:	K. PATEL
CHECKED BY:	C. SWANSON
SHEET	13 OF 30



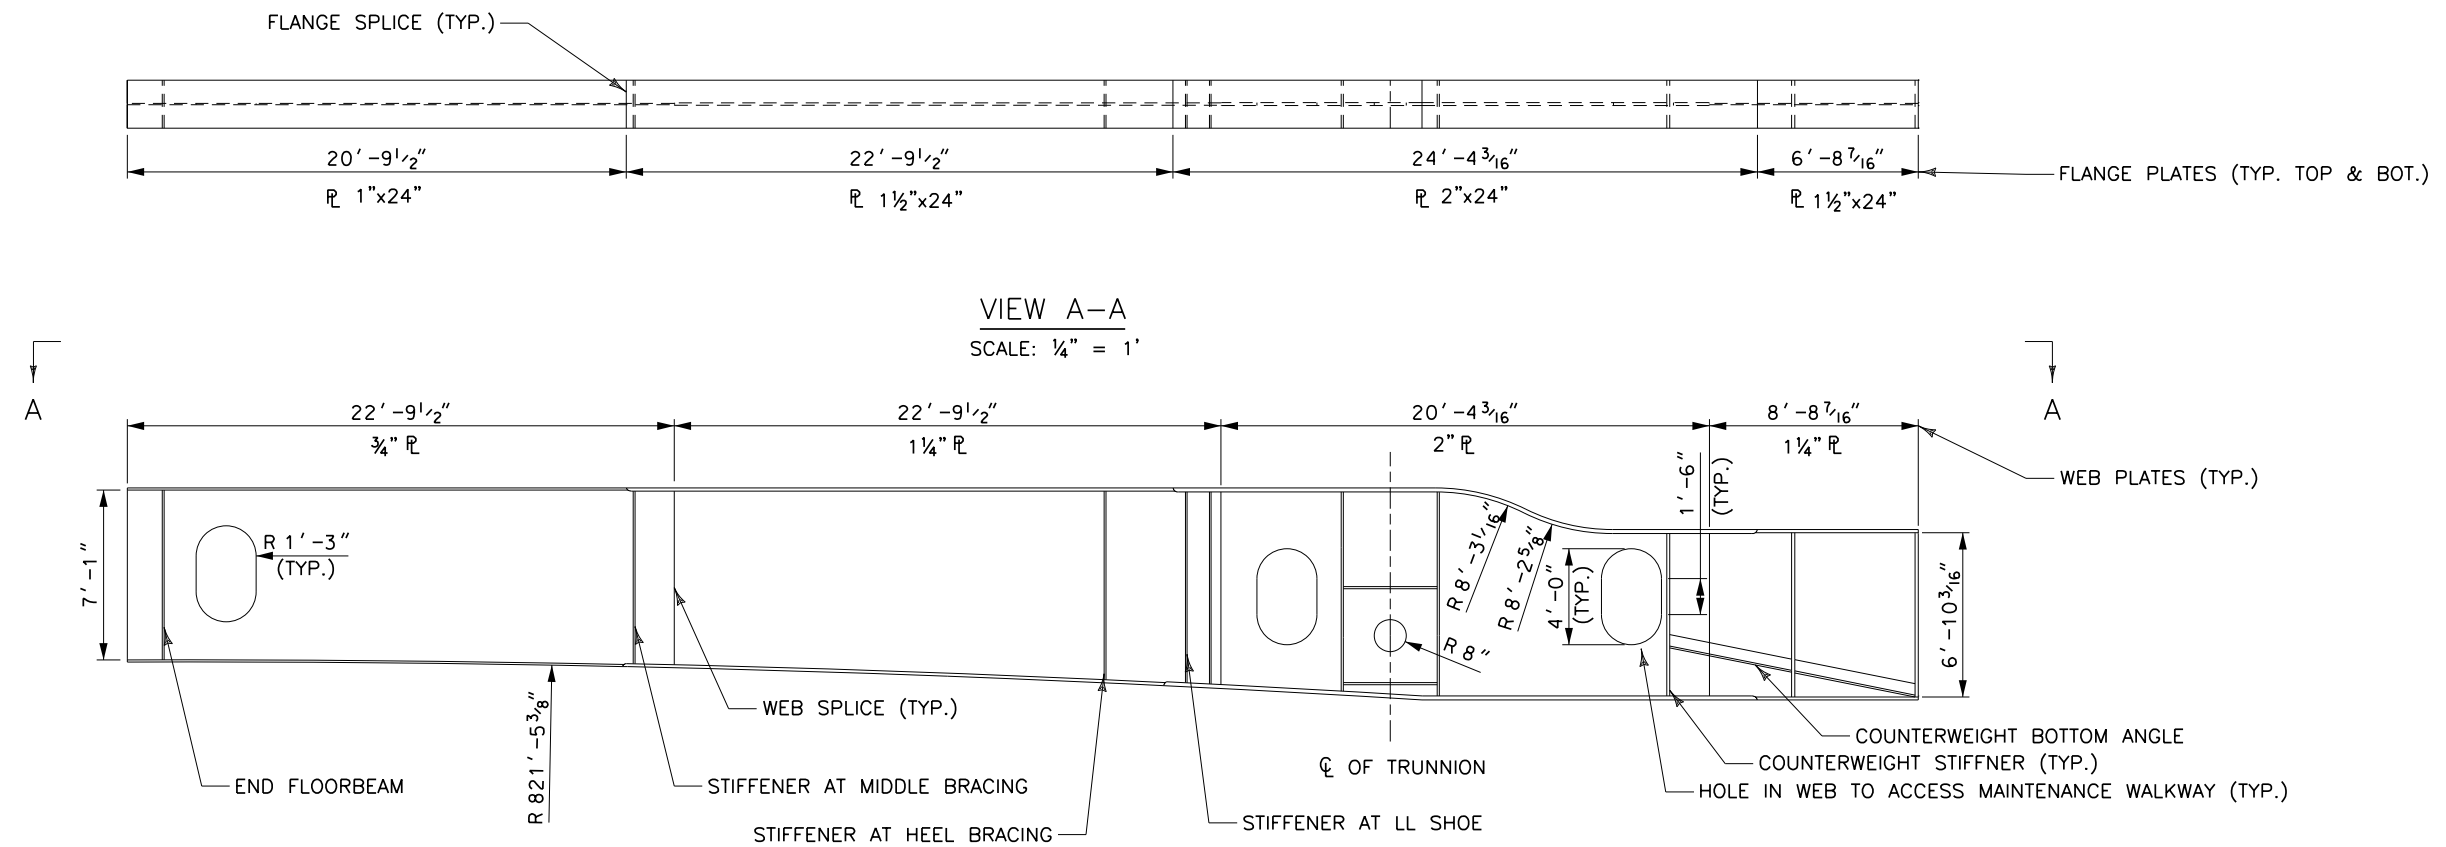

INTERIOR BASCULE GIRDER ELEVATION

SCALE: 1/4" = 1'

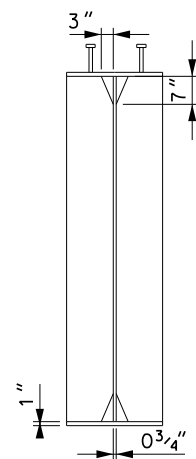

GIRDER SECTION AT MIDDLE BRACING



SCALE: 1/2" = 1'

CONCEPTUAL PLANS

PROJECT NAME: NORTH HERO GRAND ISLE BRIDGE
PROJECT NUMBER: BHF 028-1(26)

FILE NAME: z12b142bdr_girder_details2.dgn PLOT DATE: 7/28/2015
PROJECT LEADER: C. SWANSON DRAWN BY: K. PATEL
DESIGNED BY: H. PROTIN CHECKED BY: C. SWANSON
Bascule Span Girder Details (2 of 2) SHEET 14 OF 30



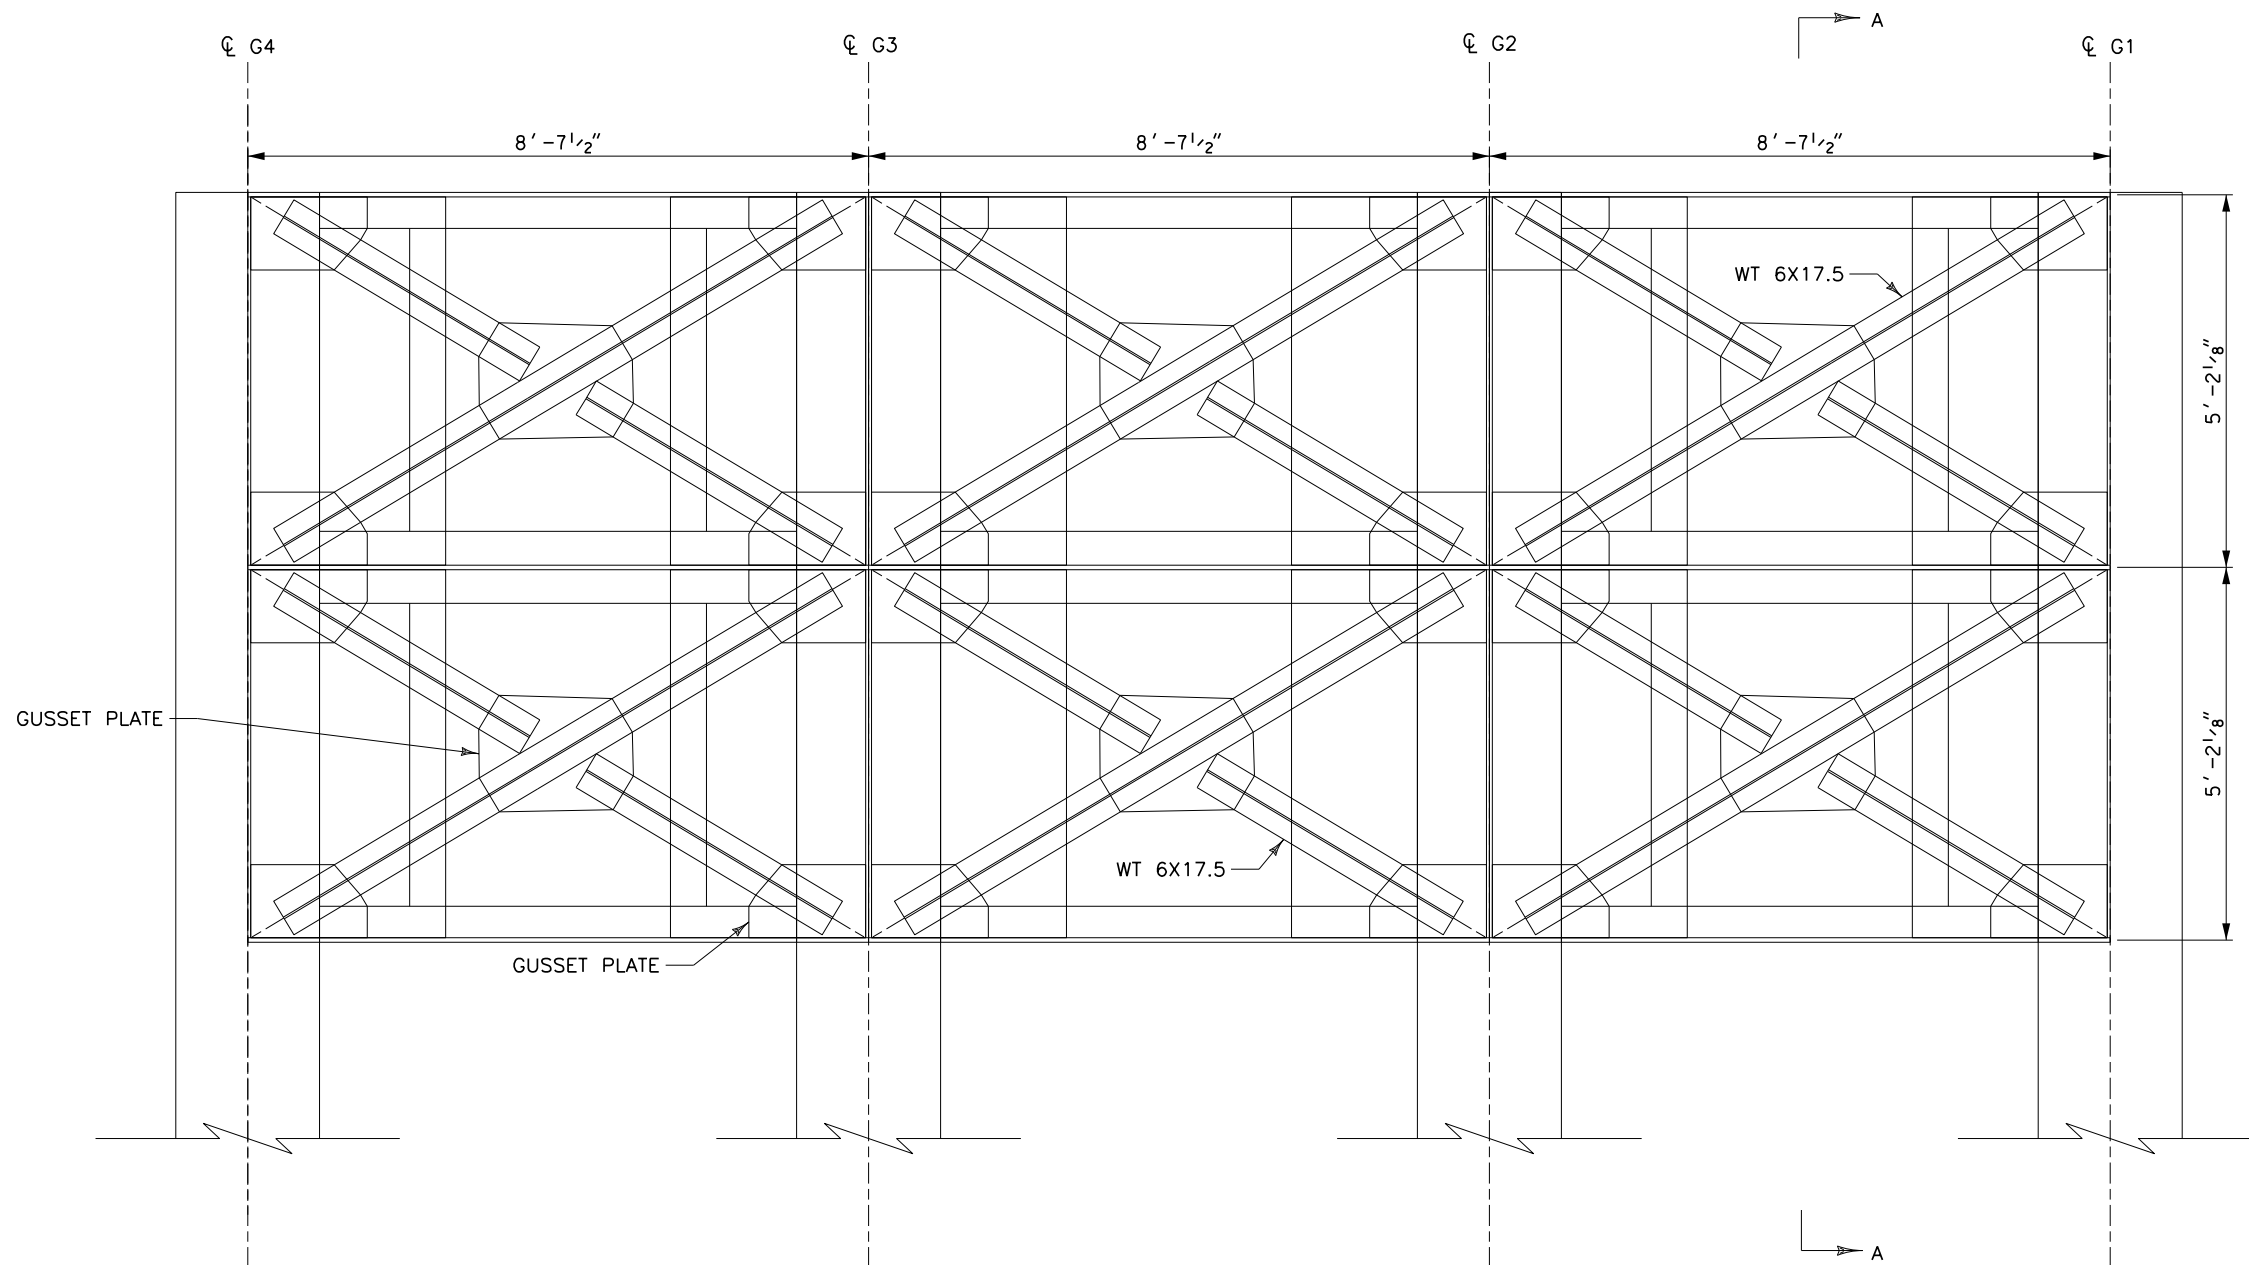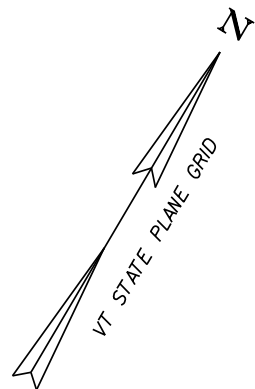


PLAN — UPPER COUNTERWEIGHT
(NORTH COUNTERWEIGHT SHOWN, SOUTH COUNTERWEIGHT OPPOSITE SIDE)
SCALE: $\frac{3}{4}$ " = 1'-0"

NOTES:
1. FOR SECTION A-A, SEE SHEET 16.


CONCEPTUAL PLANS



PROJECT NAME: NORTH HERO GRAND ISLE BRIDGE	
PROJECT NUMBER: BHF 028-1(26)	
FILE NAME: z12b142bdr_cwt_plan.dgn	PLOT DATE: 7/28/2015
PROJECT LEADER: C. SWANSON	DRAWN BY: K. PATEL
DESIGNED BY: H. PROTIN	CHECKED BY: C. SWANSON
Bascule Span Counterweight Plan	SHEET 15 OF 30

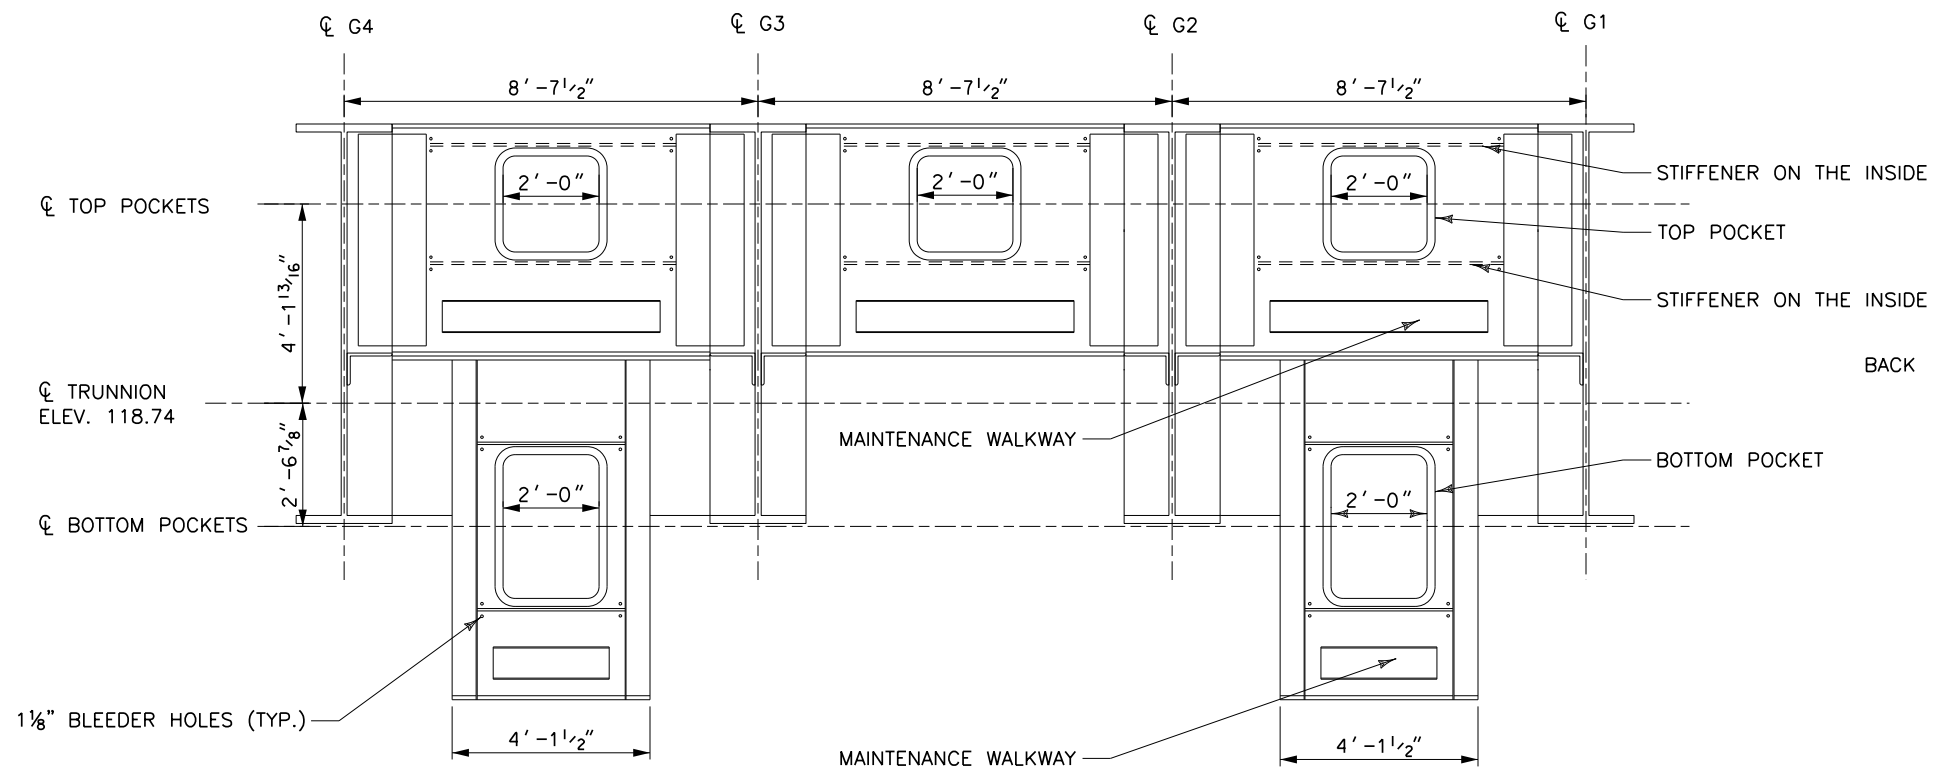

COUNTERWEIGHT ELEVATION
(NORTH COUNTERWEIGHT SHOWN, SOUTH COUNTERWEIGHT OPPOSITE SIDE)
SCALE: 1/2" = 1'-0"

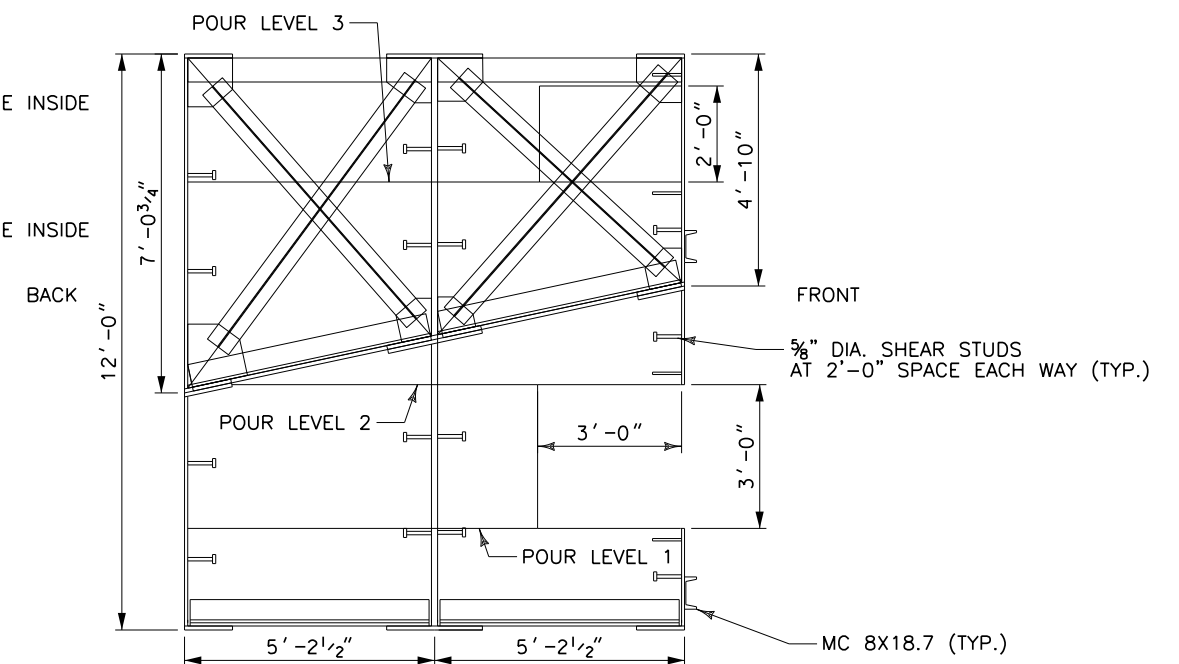


SECTION A-A
SCALE: 1/2" = 1'-0"

NOTES:
1. FOR LOCATION OF SECTION A-A, SEE SHEET 15.

CONCEPTUAL PLANS



PROJECT NAME:	NORTH HERO GRAND ISLE BRIDGE		
PROJECT NUMBER:	BHF 028-1(26)		
FILE NAME:	z12b142bdr_cwt_elev.dgn	PLOT DATE:	7/28/2015
PROJECT LEADER:	C. SWANSON	DRAWN BY:	K. PATEL
DESIGNED BY:	H. PROTIN	CHECKED BY:	C. SWANSON
Bascule Span Counterweight Elevation		SHEET	16 OF 30

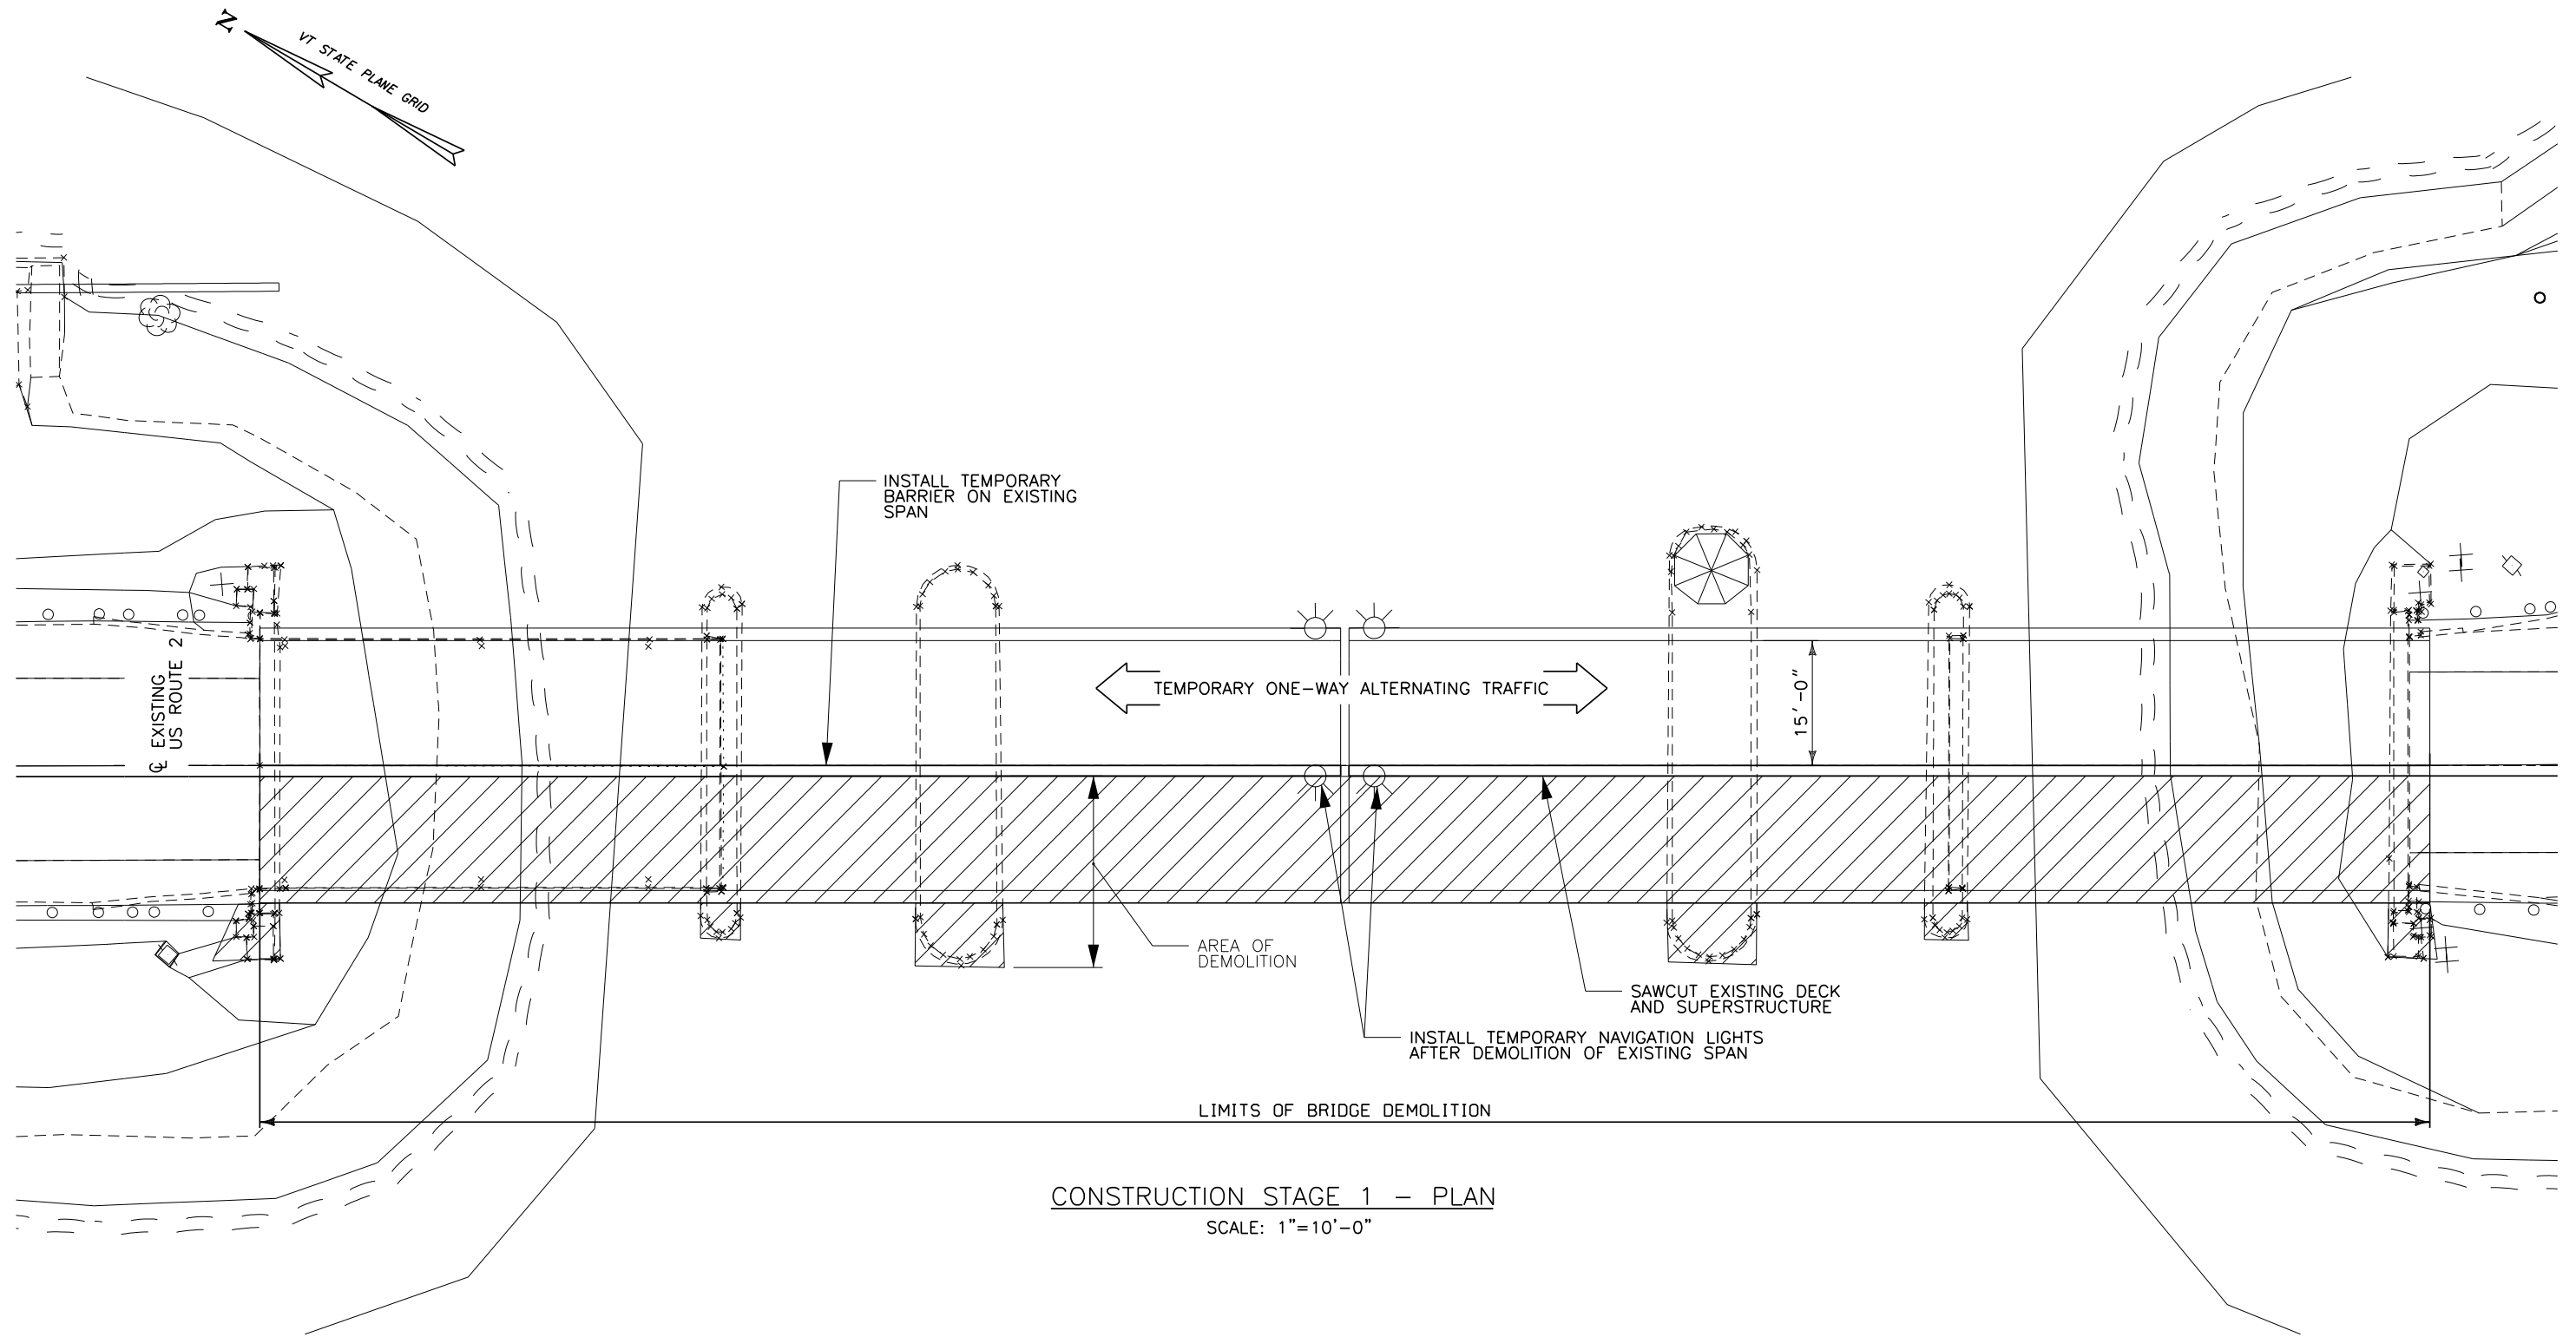


CONSTRUCTION STAGE 1 - PLAN
SCALE: 1"=10'-0"


CONCEPTUAL PLANS




PROJECT NAME: NORTH HERO GRAND ISLE BRIDGE	
PROJECT NUMBER: BHF 028-1(26)	
FILE NAME: z12b142bdr_cs1.dgn	PLOT DATE: 7/28/2015
PROJECT LEADER: C. SWANSON	DRAWN BY: P. MONTICCILOLO
DESIGNED BY: H. PROTIN	CHECKED BY: G. NICKELS
CONSTRUCTION STAGE I- PLAN	SHEET 17 OF 30

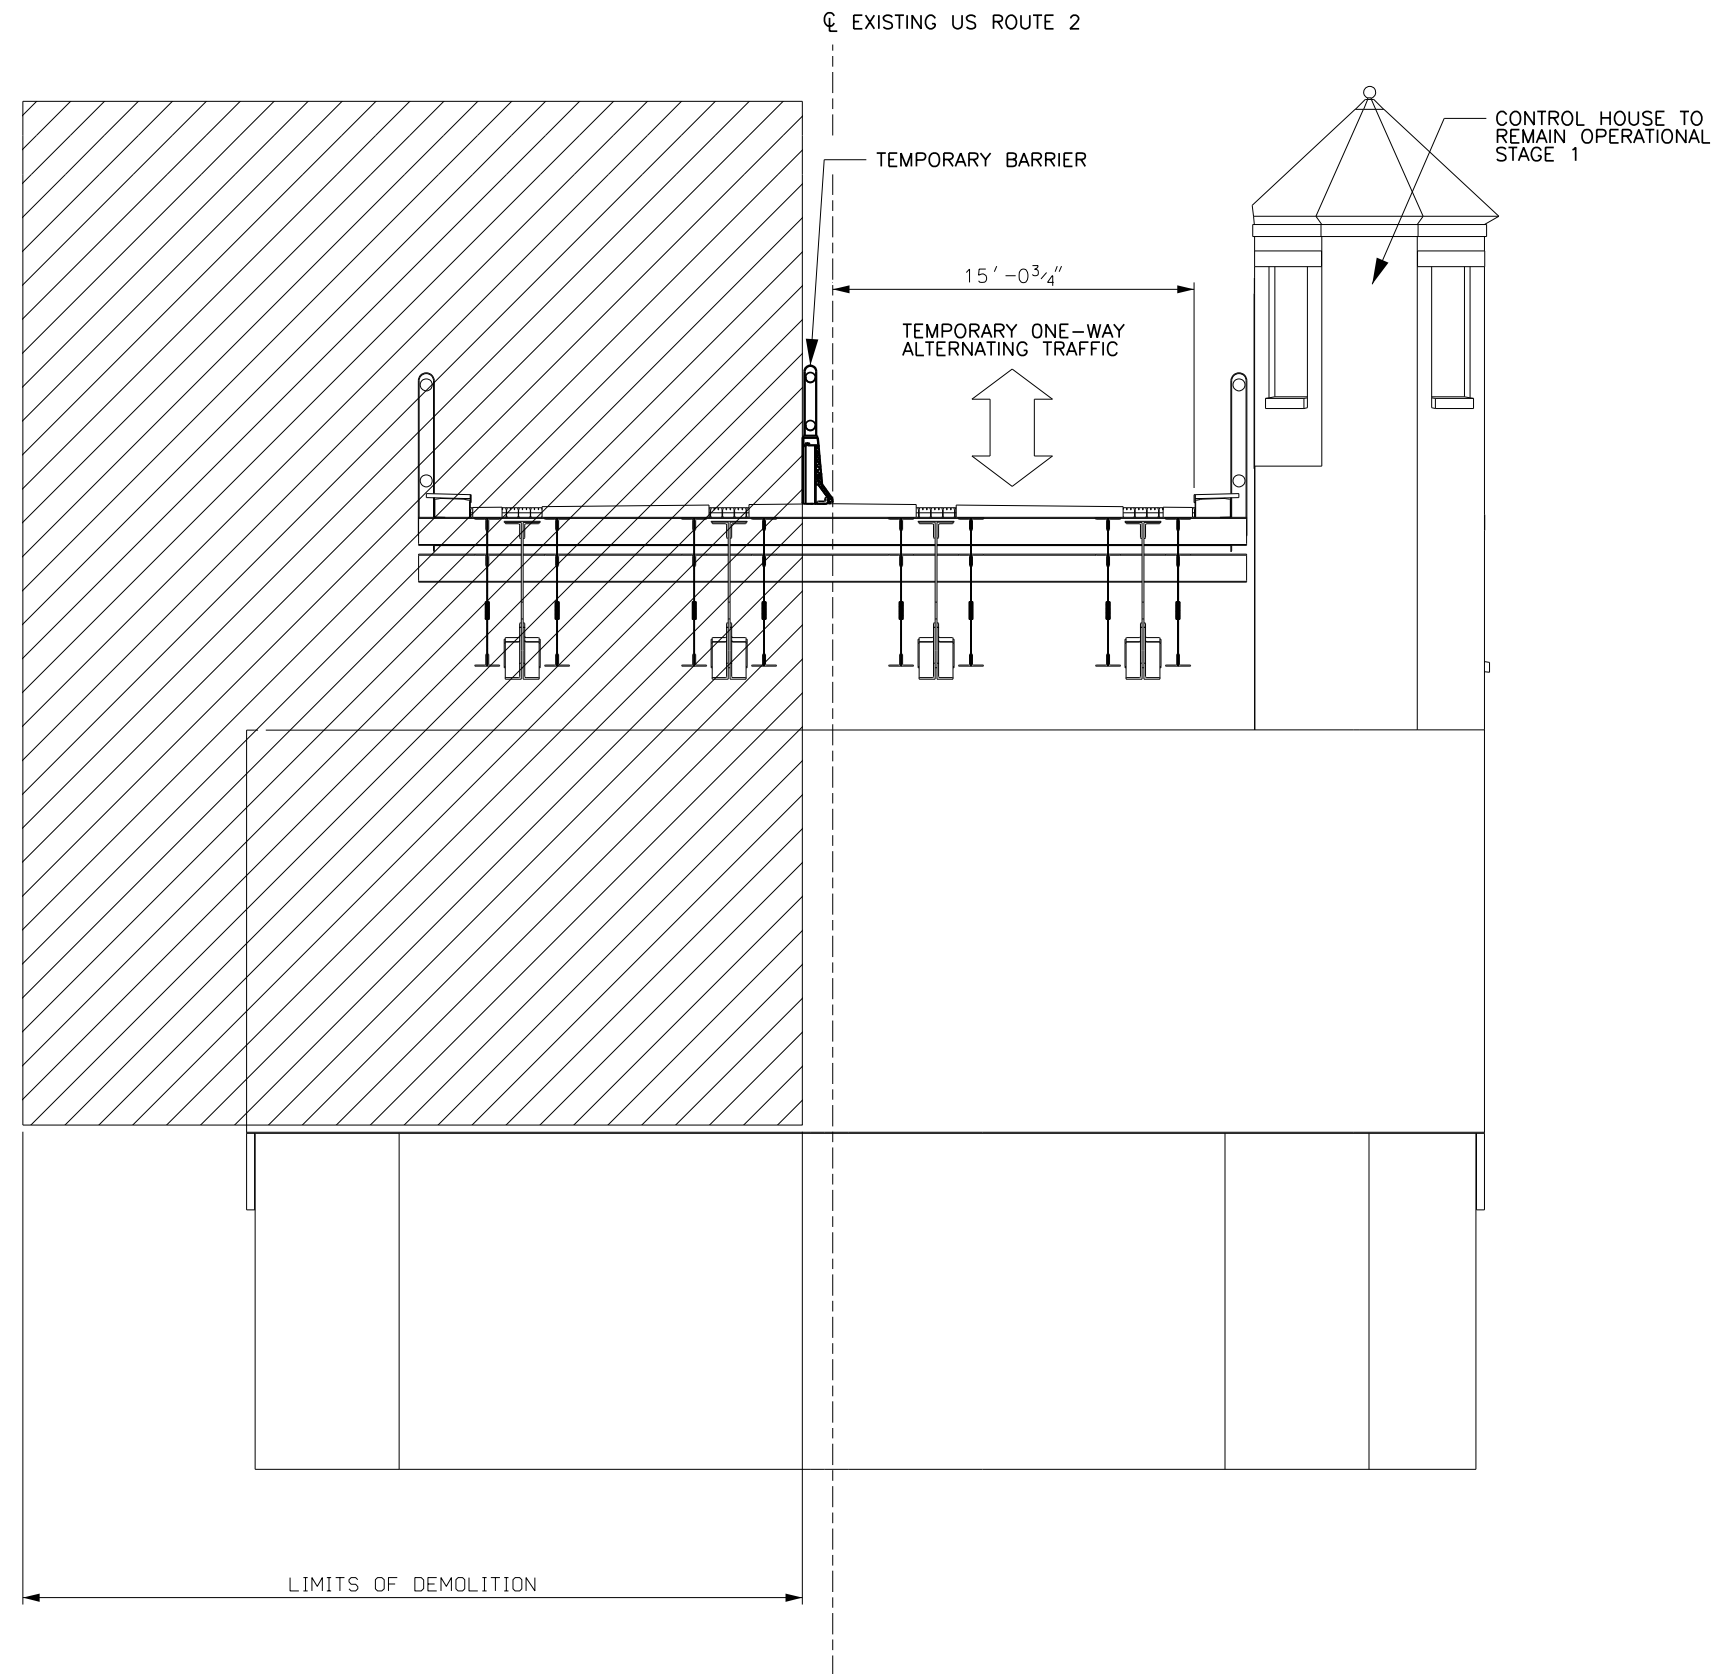

STAGE 1 – TYPICAL COUNTERWEIGHT SPAN SECTION
SCALE: 1/4"=1'-0"

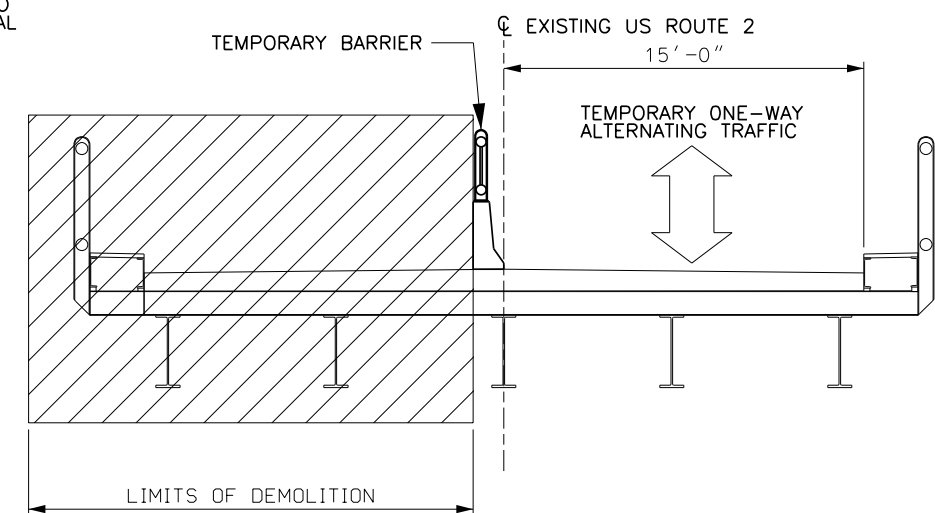

STAGE 1 – TYPICAL APPROACH SPAN SECTION
SCALE: 1/4"=1'-0"

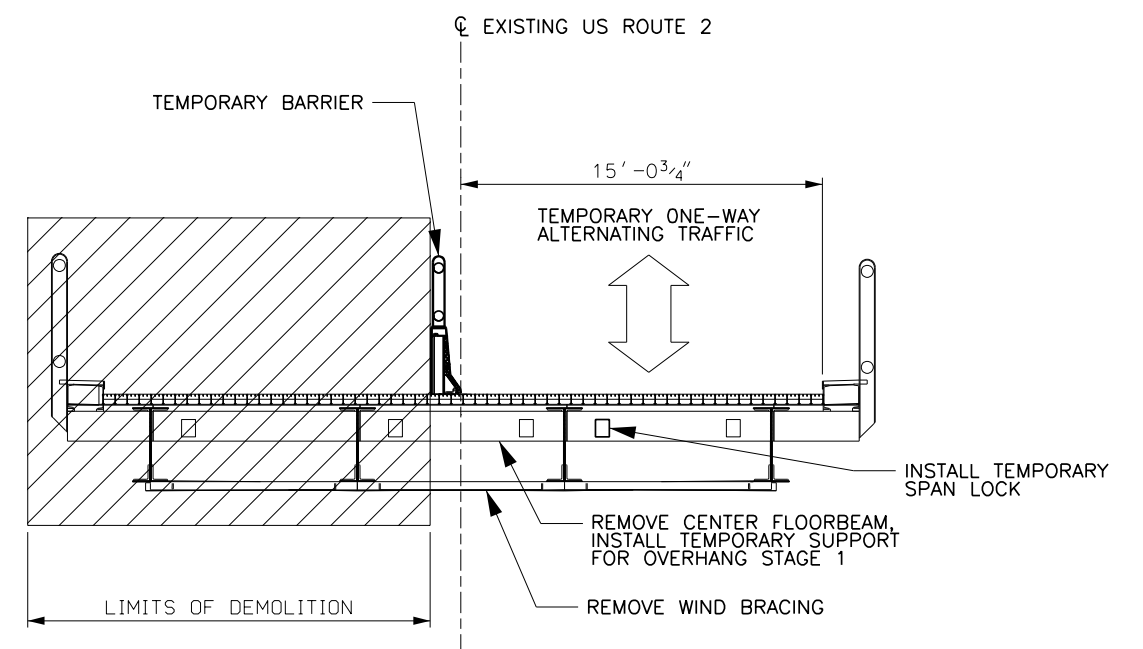


STAGE 1 – TYPICAL BASCULE SPAN SECTION
SCALE: 1/4"=1'-0"

CONCEPTUAL PLANS



PROJECT NAME: NORTH HERO GRAND ISLE BRIDGE	
PROJECT NUMBER: BHF 028-1(26)	
FILE NAME: z12b142bdr_xcs1.dgn	PLOT DATE: 7/28/2015
PROJECT LEADER: C. SWANSON	DRAWN BY: P. MONTICCIOLLO
DESIGNED BY: H. PROTIN	CHECKED BY: G. NICKELS
CONSTRUCTION STAGE I- SECTIONS	SHEET 18 OF 30


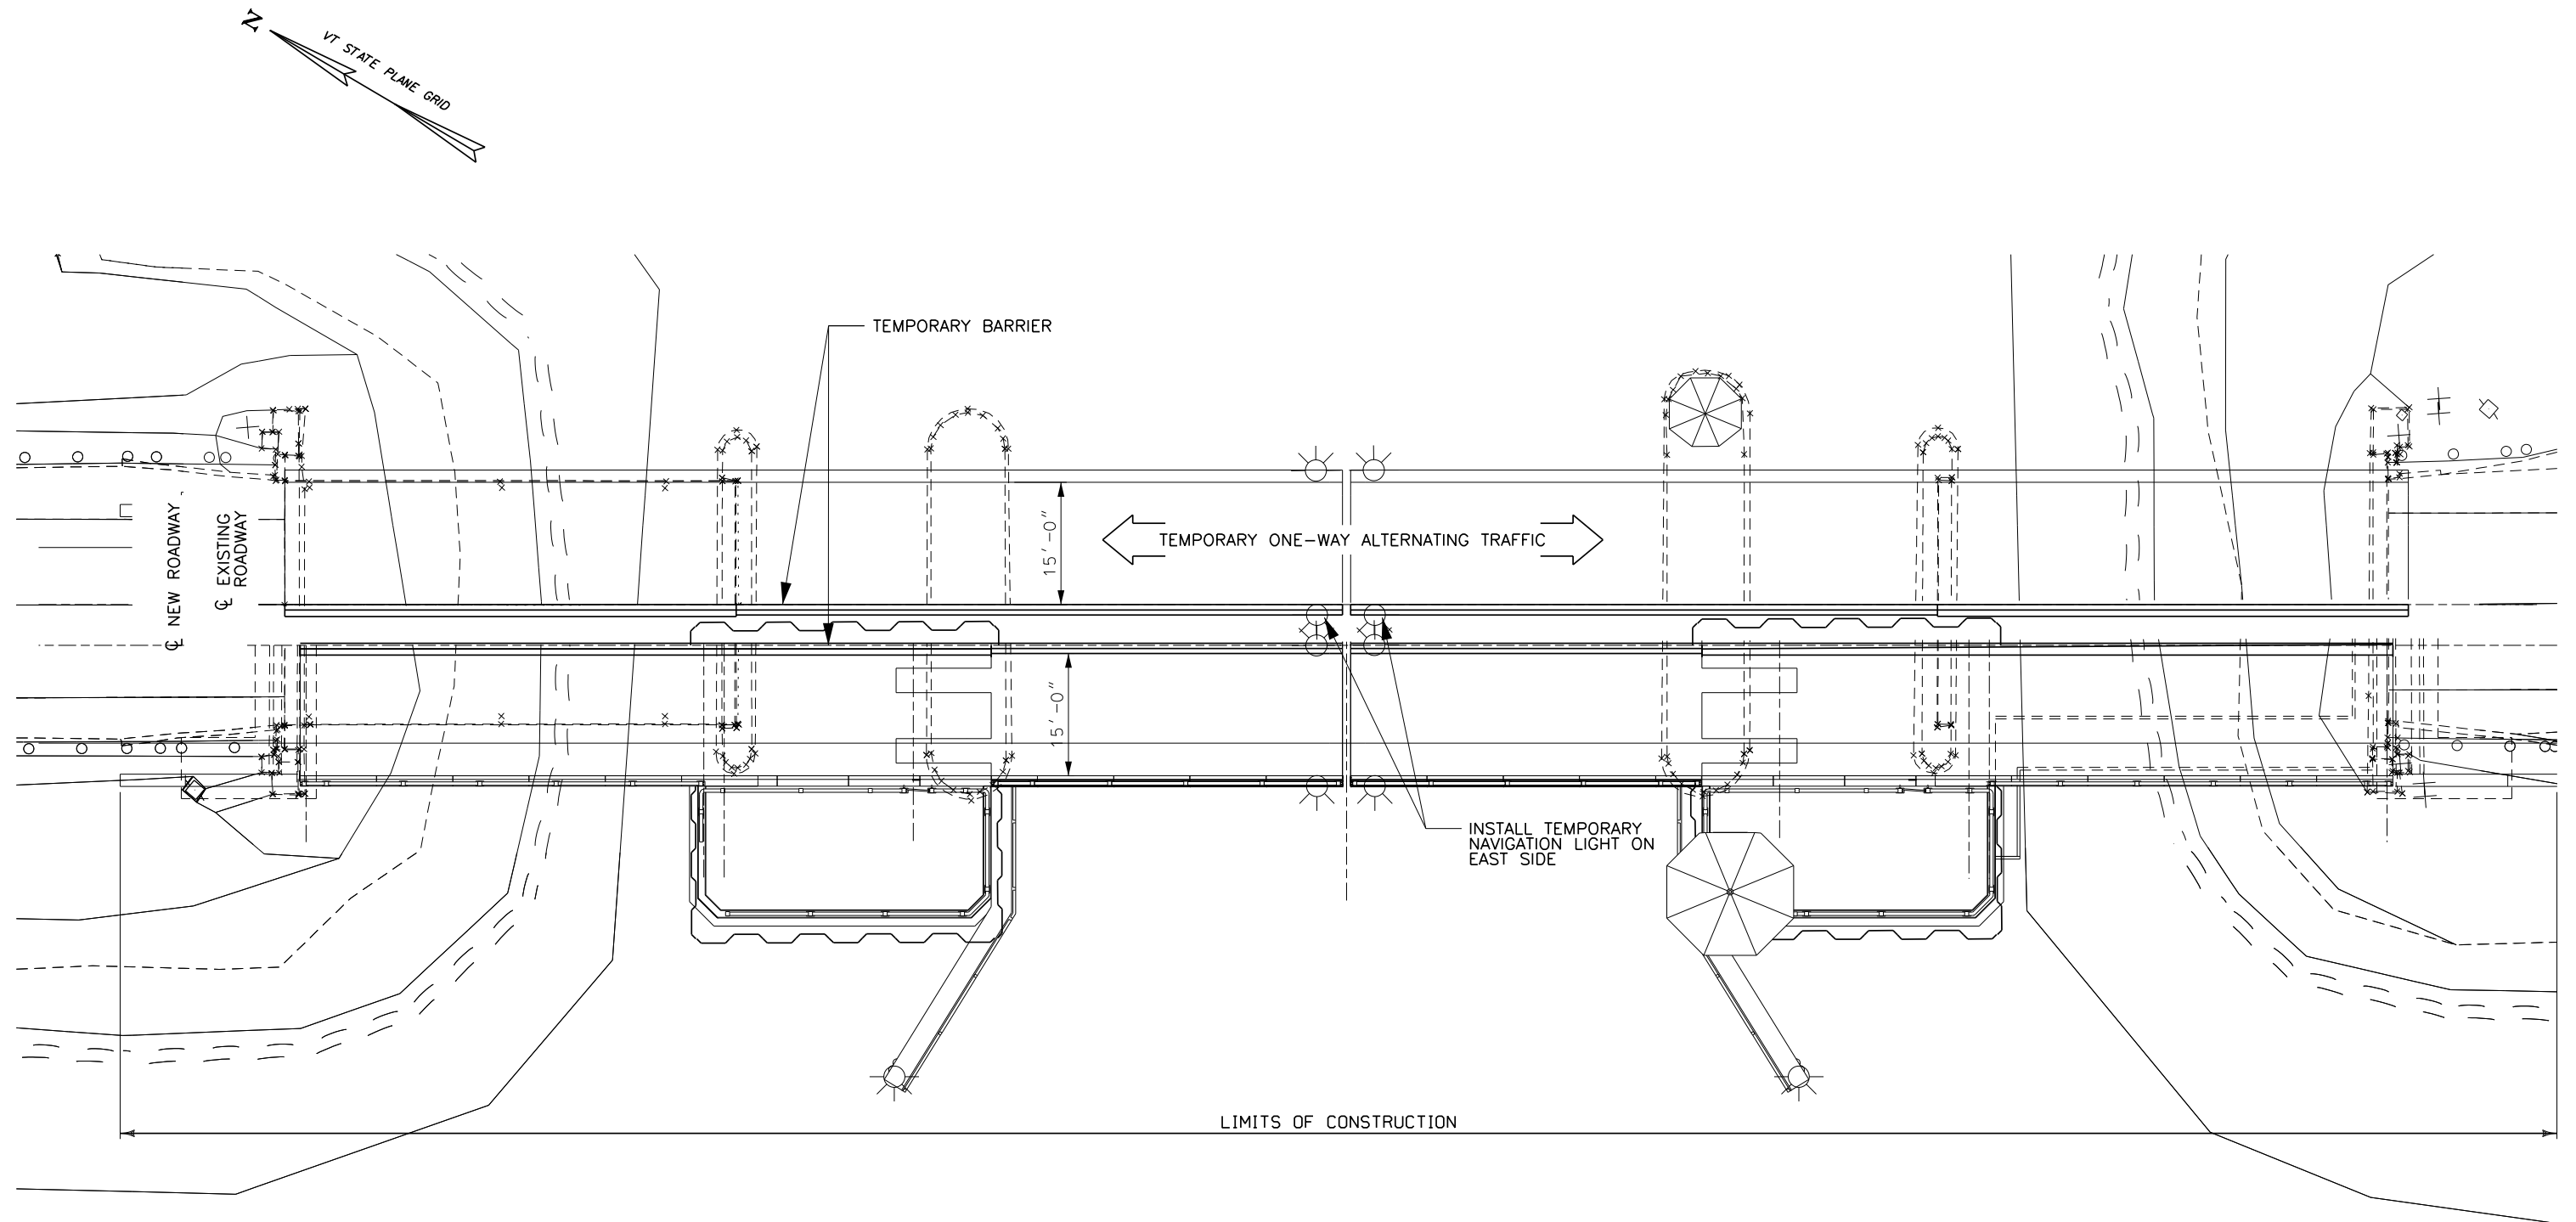


CONSTRUCTION STAGE 2 – PLAN
SCALE: 1"=10'-0"


CONCEPTUAL PLANS



PROJECT NAME: NORTH HERO GRAND ISLE BRIDGE	
PROJECT NUMBER: BHF 028-1(26)	
FILE NAME: z12b142bdr_cs2.dgn	PLOT DATE: 7/28/2015
PROJECT LEADER: C. SWANSON	DRAWN BY: D. DOUGHERTY
DESIGNED BY: C. SWANSON	CHECKED BY: C. SWANSON
CONSTRUCTION STAGE 2 - PLAN	SHEET 19 OF 30

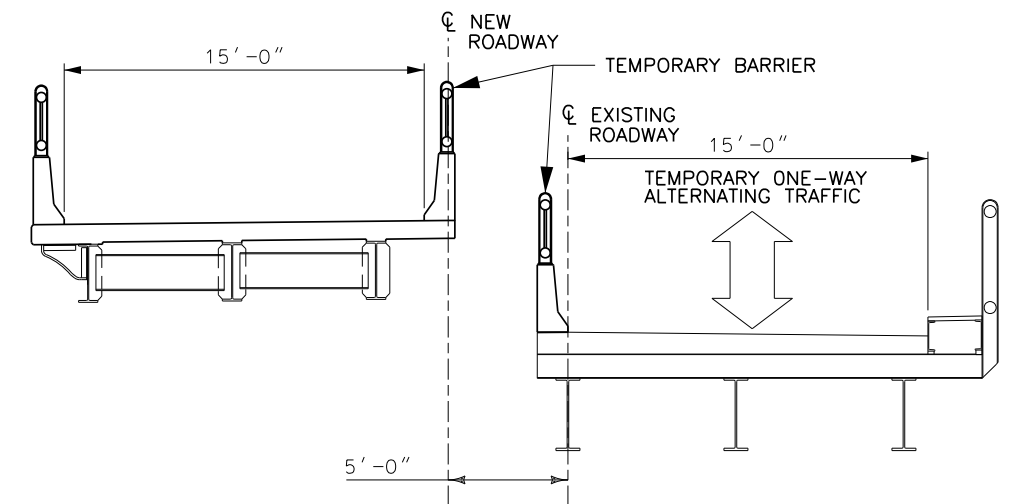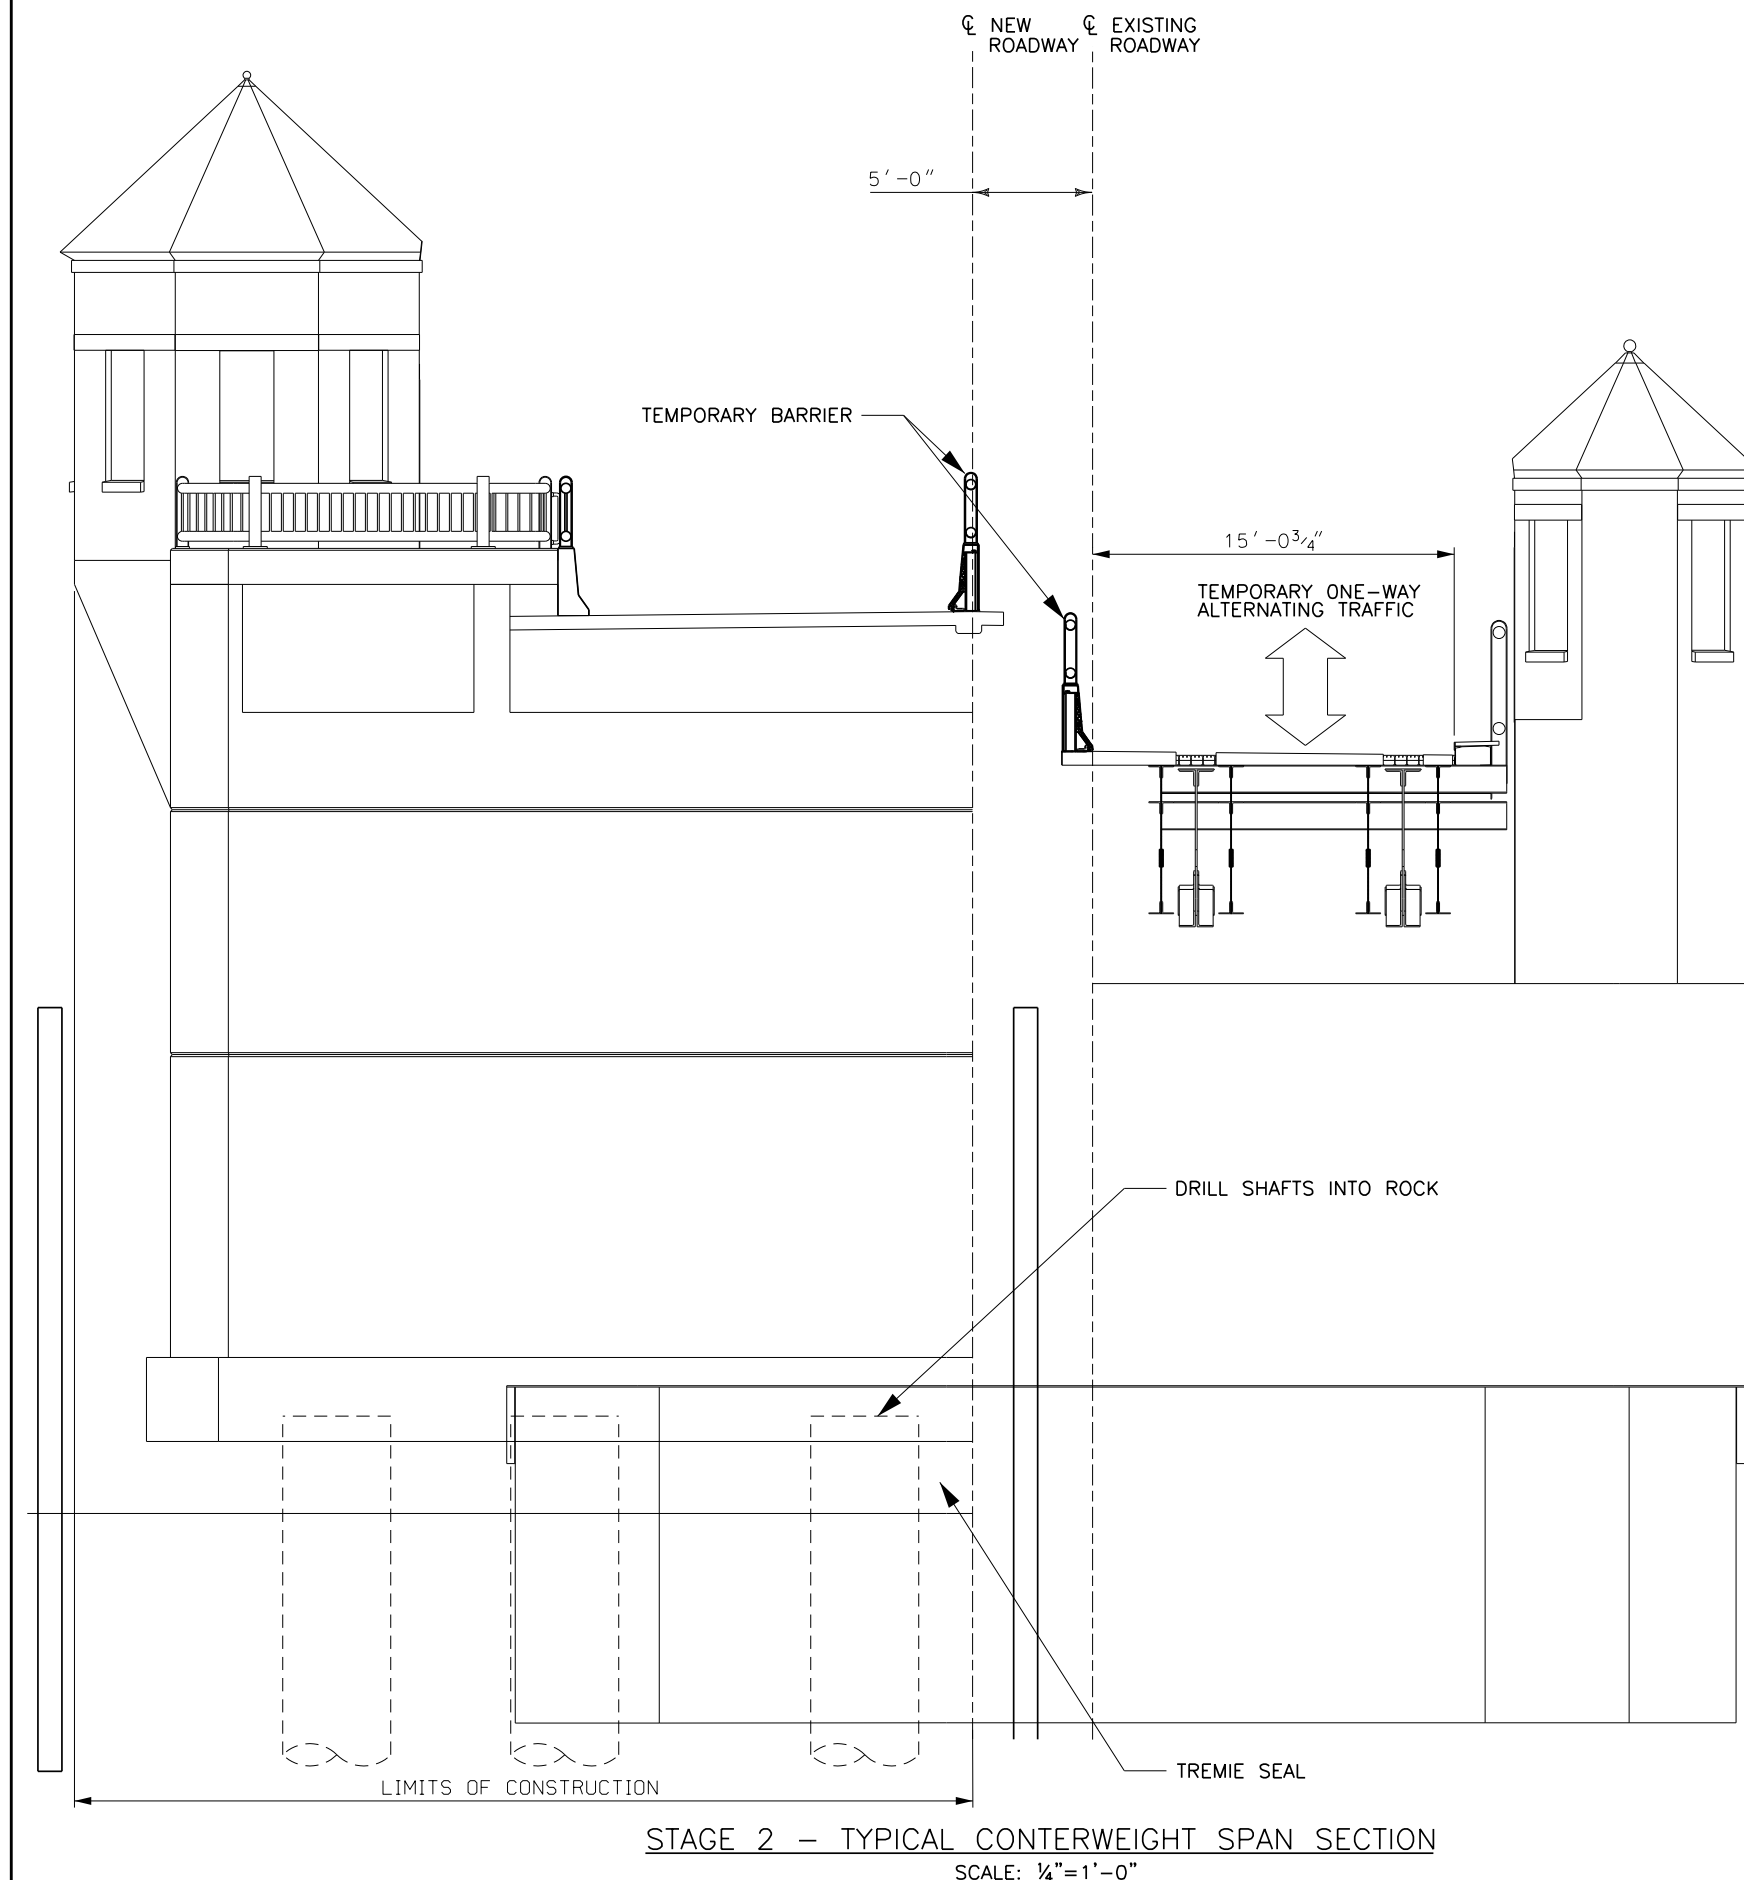

STAGE 2 - TYPICAL APPROACH SPAN SECTION
SCALE: 1/4"=1'-0"

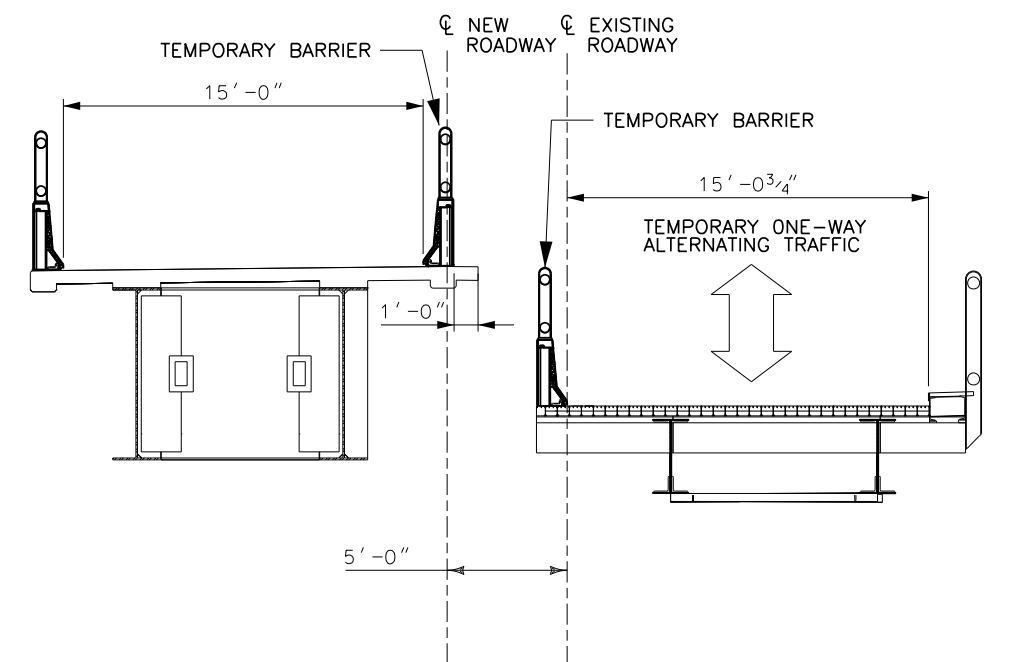


STAGE 2 - TYPICAL BASCULE SPAN SECTION
SCALE: 1/4"=1'-0"

CONCEPTUAL PLANS



PROJECT NAME: NORTH HERO GRAND ISLE BRIDGE	
PROJECT NUMBER: BHF 028-1(26)	
FILE NAME: z12b142bdr_xscs2.dgn	PLOT DATE: 7/28/2015
PROJECT LEADER: C. SWANSON	DRAWN BY: P. MONTICCILOLO
DESIGNED BY: H. PROTIN	CHECKED BY: G. NICKELS
CONSTRUCTION STAGE 2 - SECTIONS	SHEET 20 OF 30

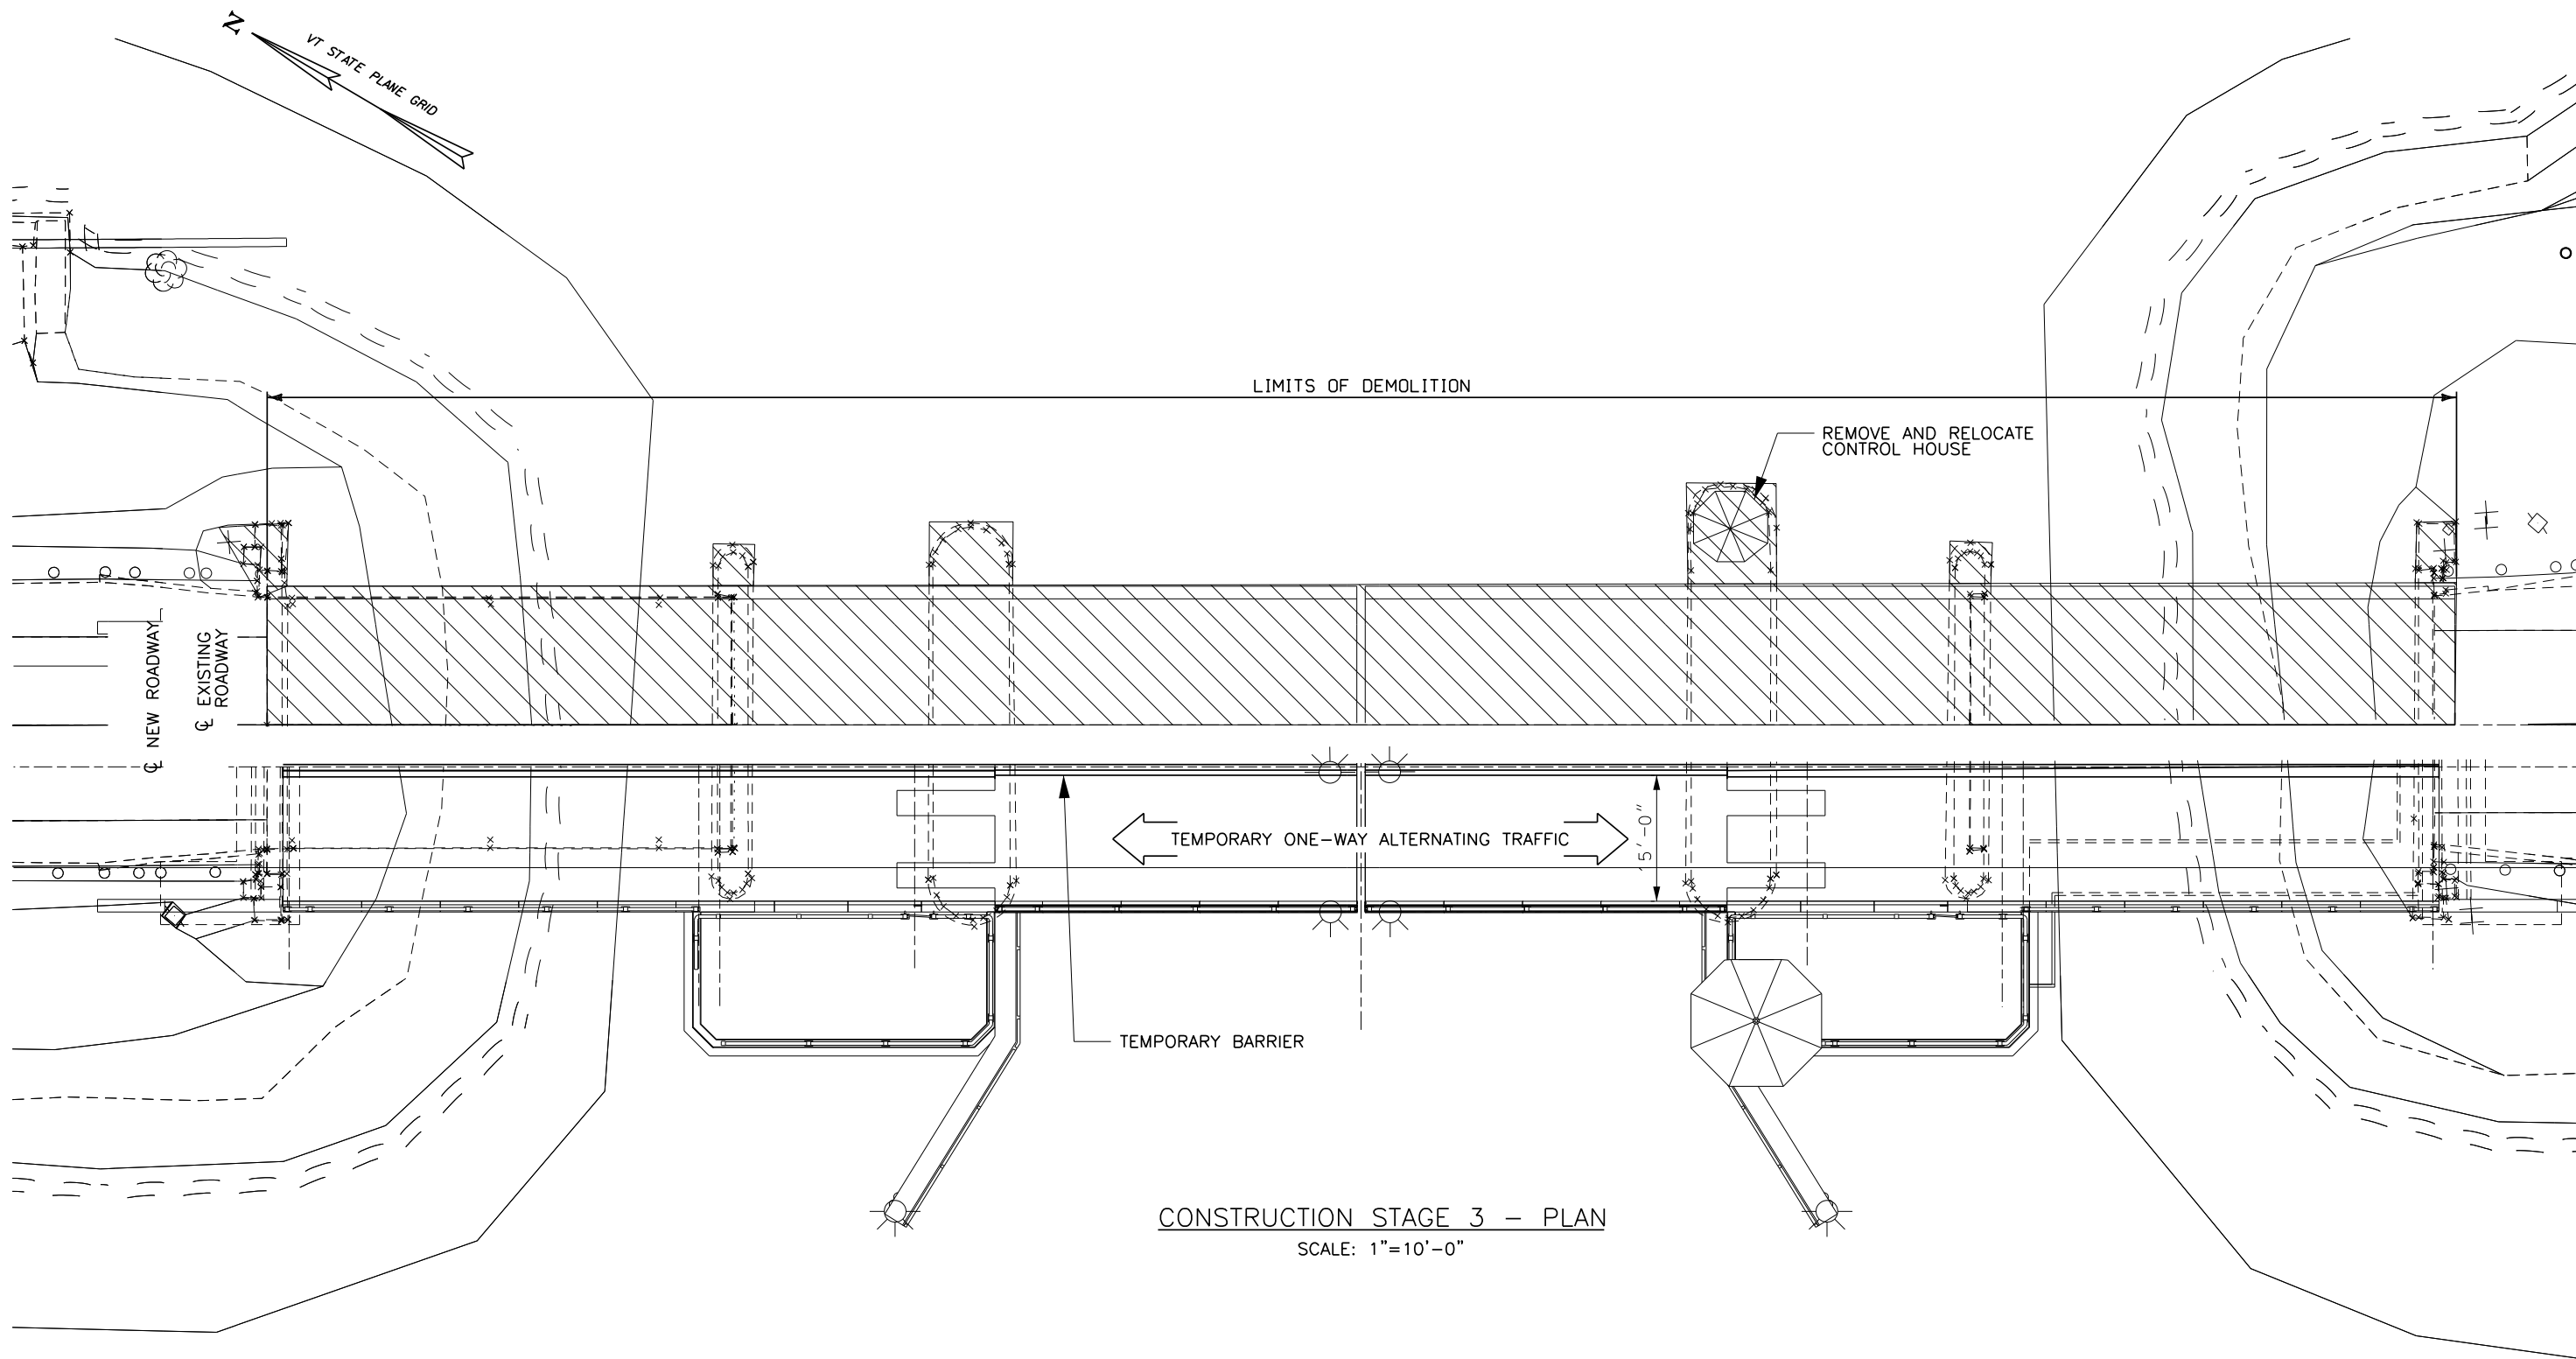


CONSTRUCTION STAGE 3 - PLAN
SCALE: 1"=10'-0"


CONCEPTUAL PLANS




PROJECT NAME: NORTH HERO GRAND ISLE BRIDGE	
PROJECT NUMBER: BHF 028-1(26)	
FILE NAME: z12b142bdr_cs3.dgn	PLOT DATE: 7/28/2015
PROJECT LEADER: C. SWANSON	DRAWN BY: P. MONTICCILO
DESIGNED BY: H. PROTIN	CHECKED BY: C. SWANSON
CONSTRUCTION STAGE 3 - PLAN	SHEET 21 OF 30

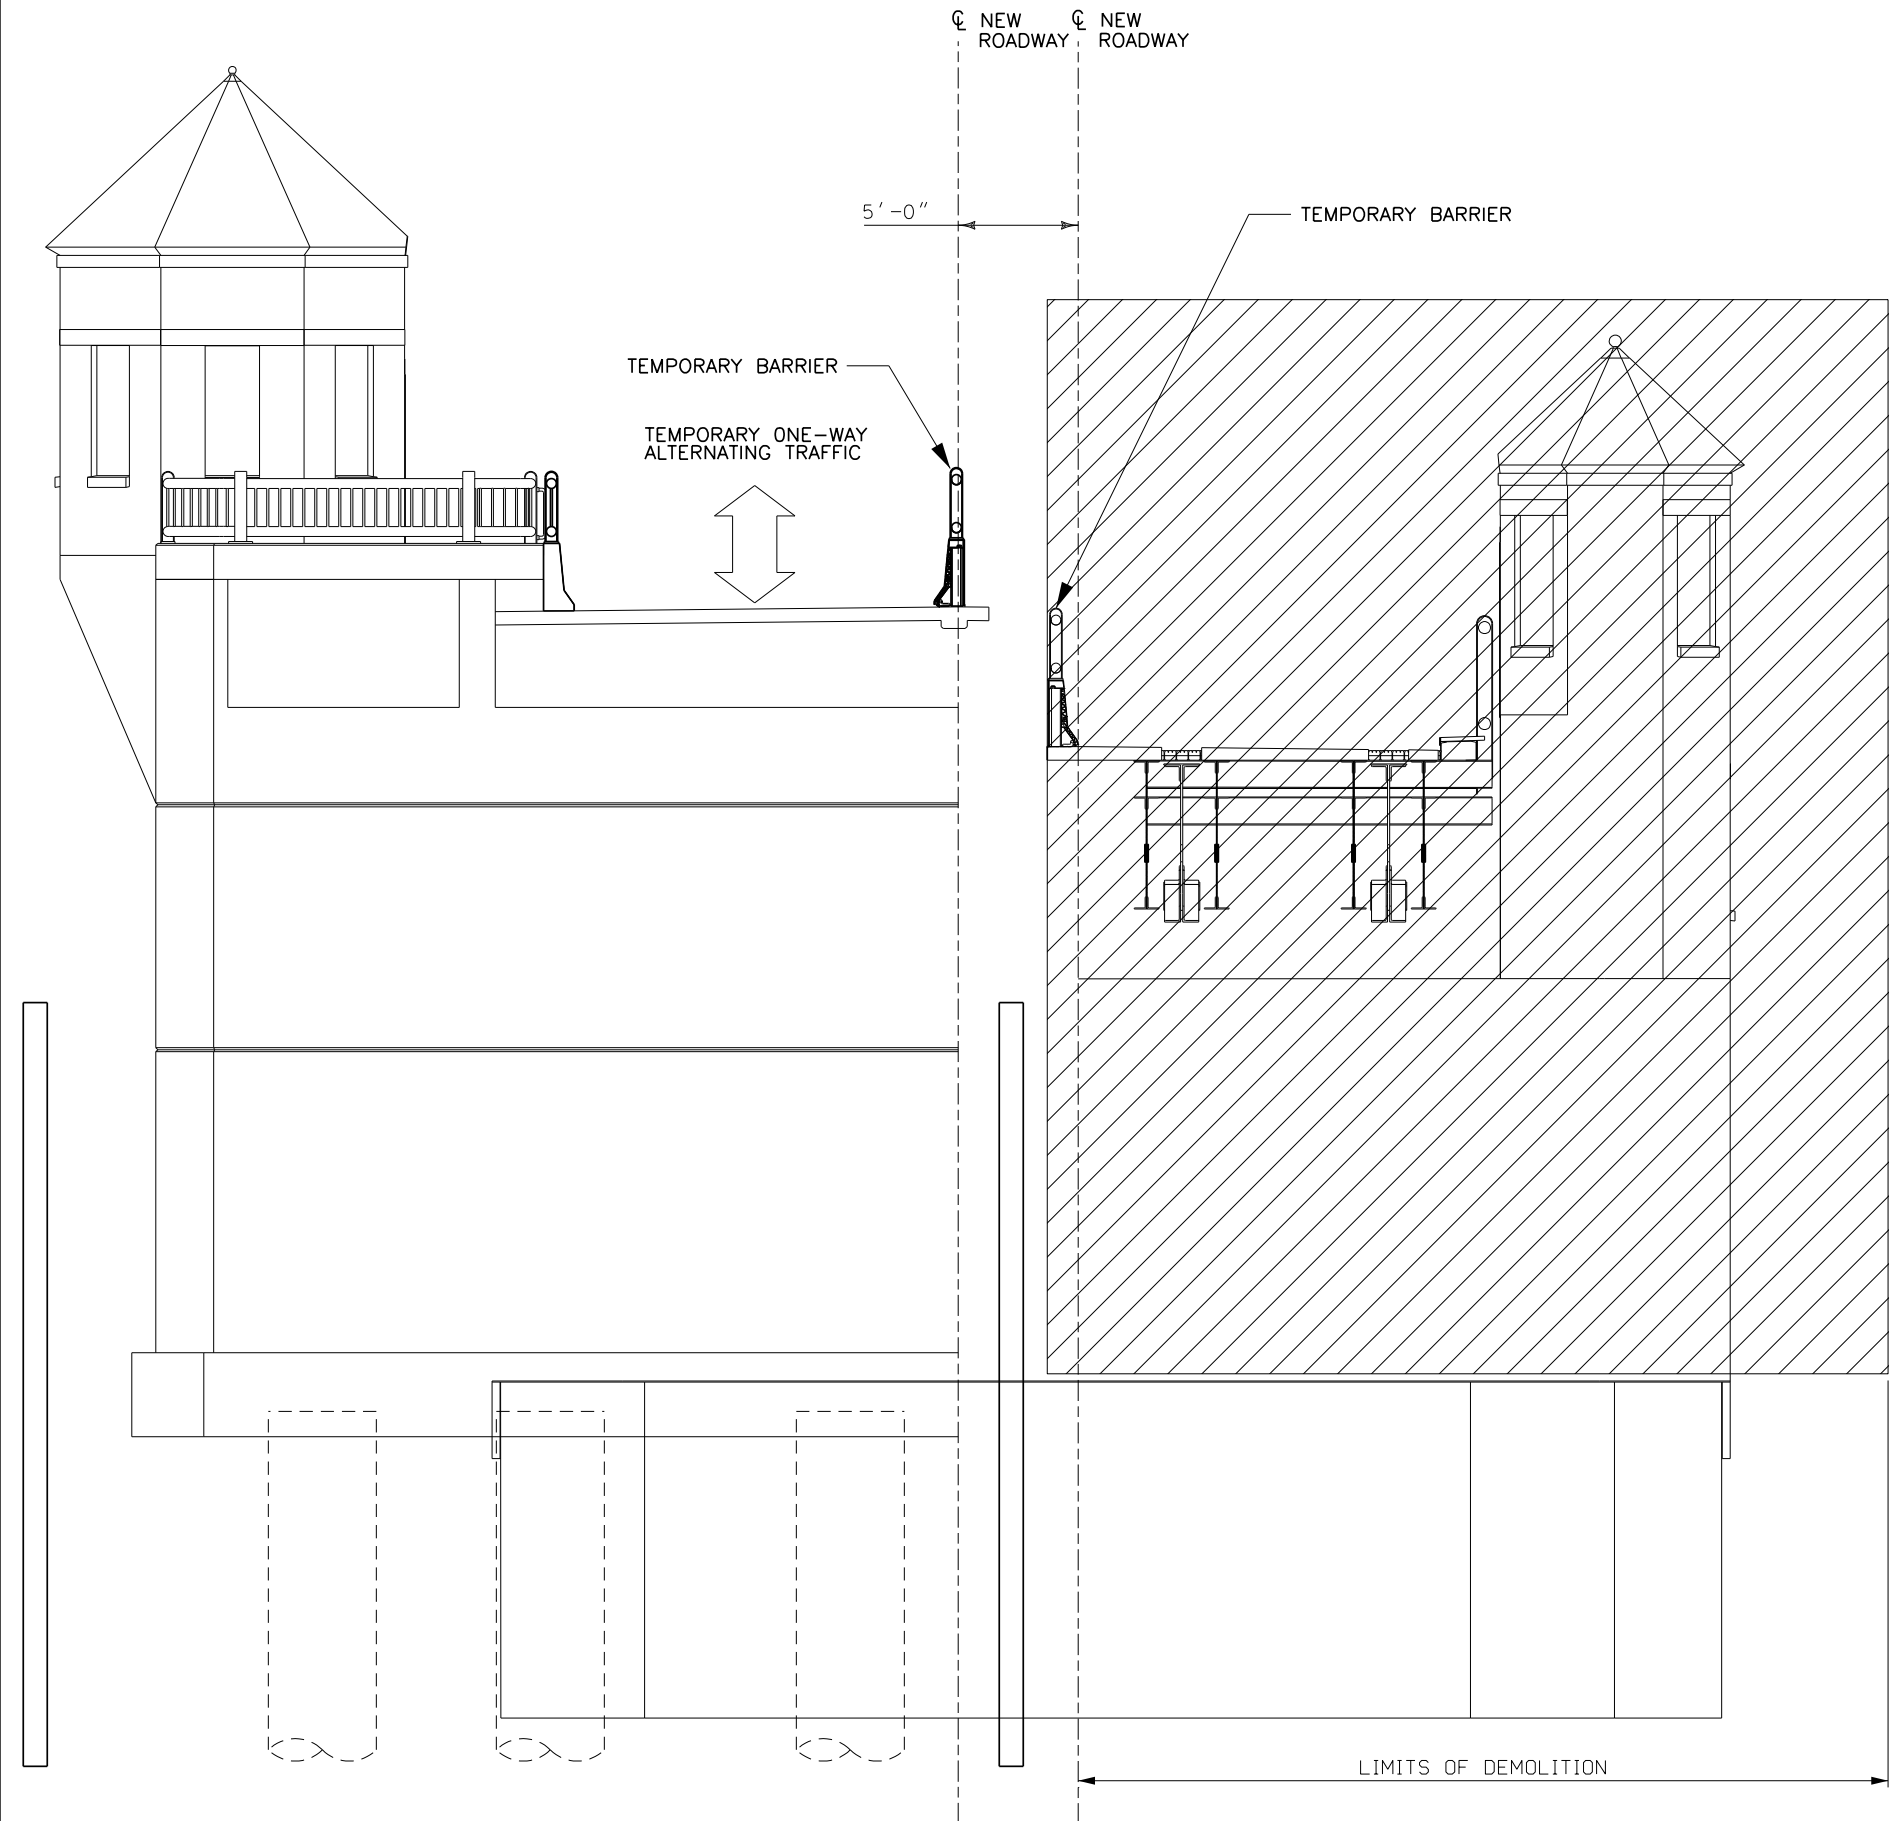

STAGE 3 - TYPICAL CONTERWEIGHT SPAN SECTION
SCALE: 1/4"=1'-0"

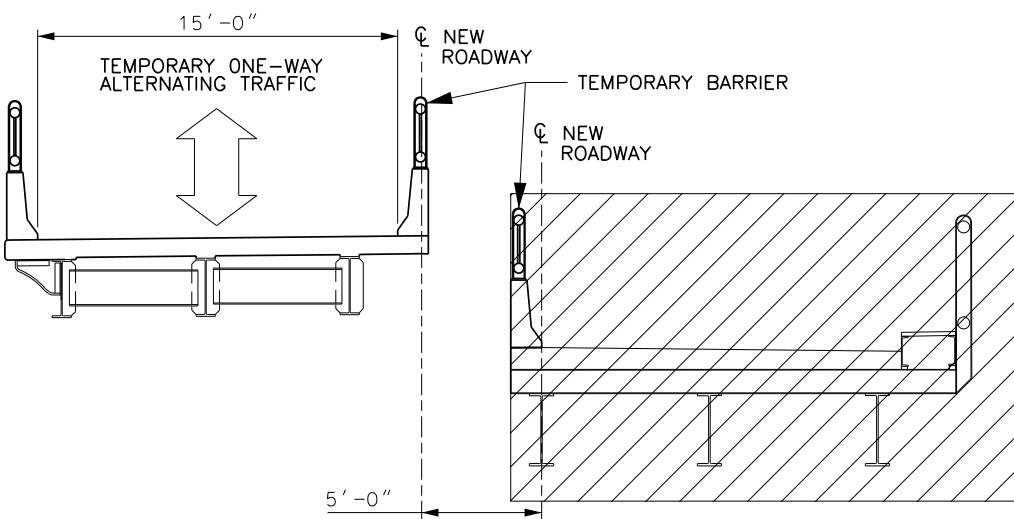

STAGE 3 - TYPICAL APPROACH SPAN SECTION
SCALE: 1/4"=1'-0"

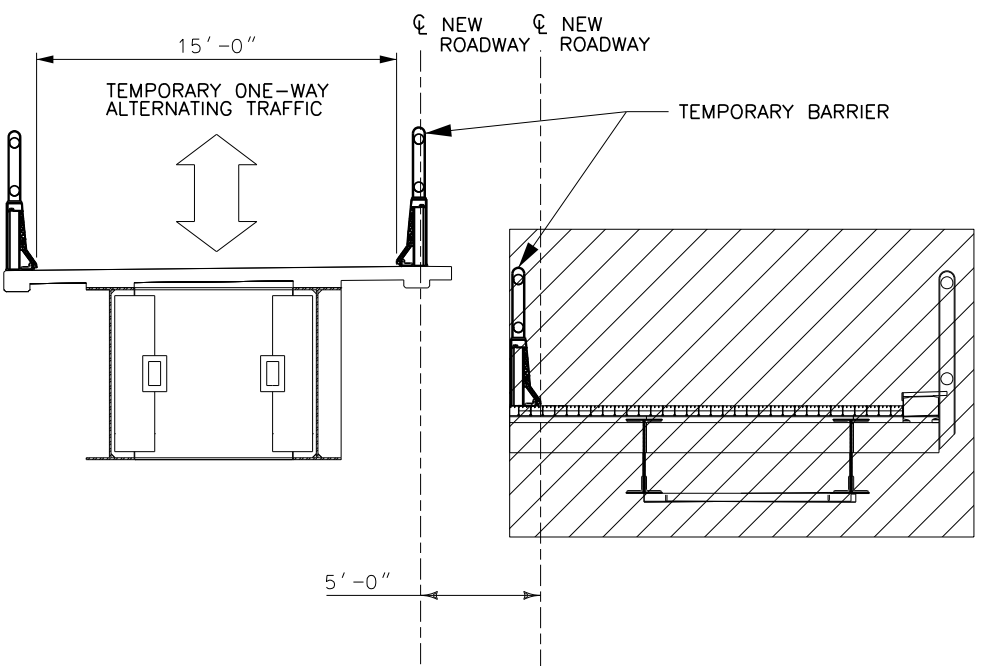


STAGE 3 - TYPICAL BASCULE SPAN SECTION
SCALE: 1/4"=1'-0"

CONCEPTUAL PLANS



PROJECT NAME: NORTH HERO GRAND ISLE BRIDGE	
PROJECT NUMBER: BHF 028-1(26)	
FILE NAME: z12b142bdr_xscs3.dgn	PLOT DATE: 7/28/2015
PROJECT LEADER: C. SWANSON	DRAWN BY: P. MONTICCILOLO
DESIGNED BY: H. PROTIN	CHECKED BY: G. NICKELS
CONSTRUCTION STAGE 3 - SECTIONS	SHEET 22 OF 30

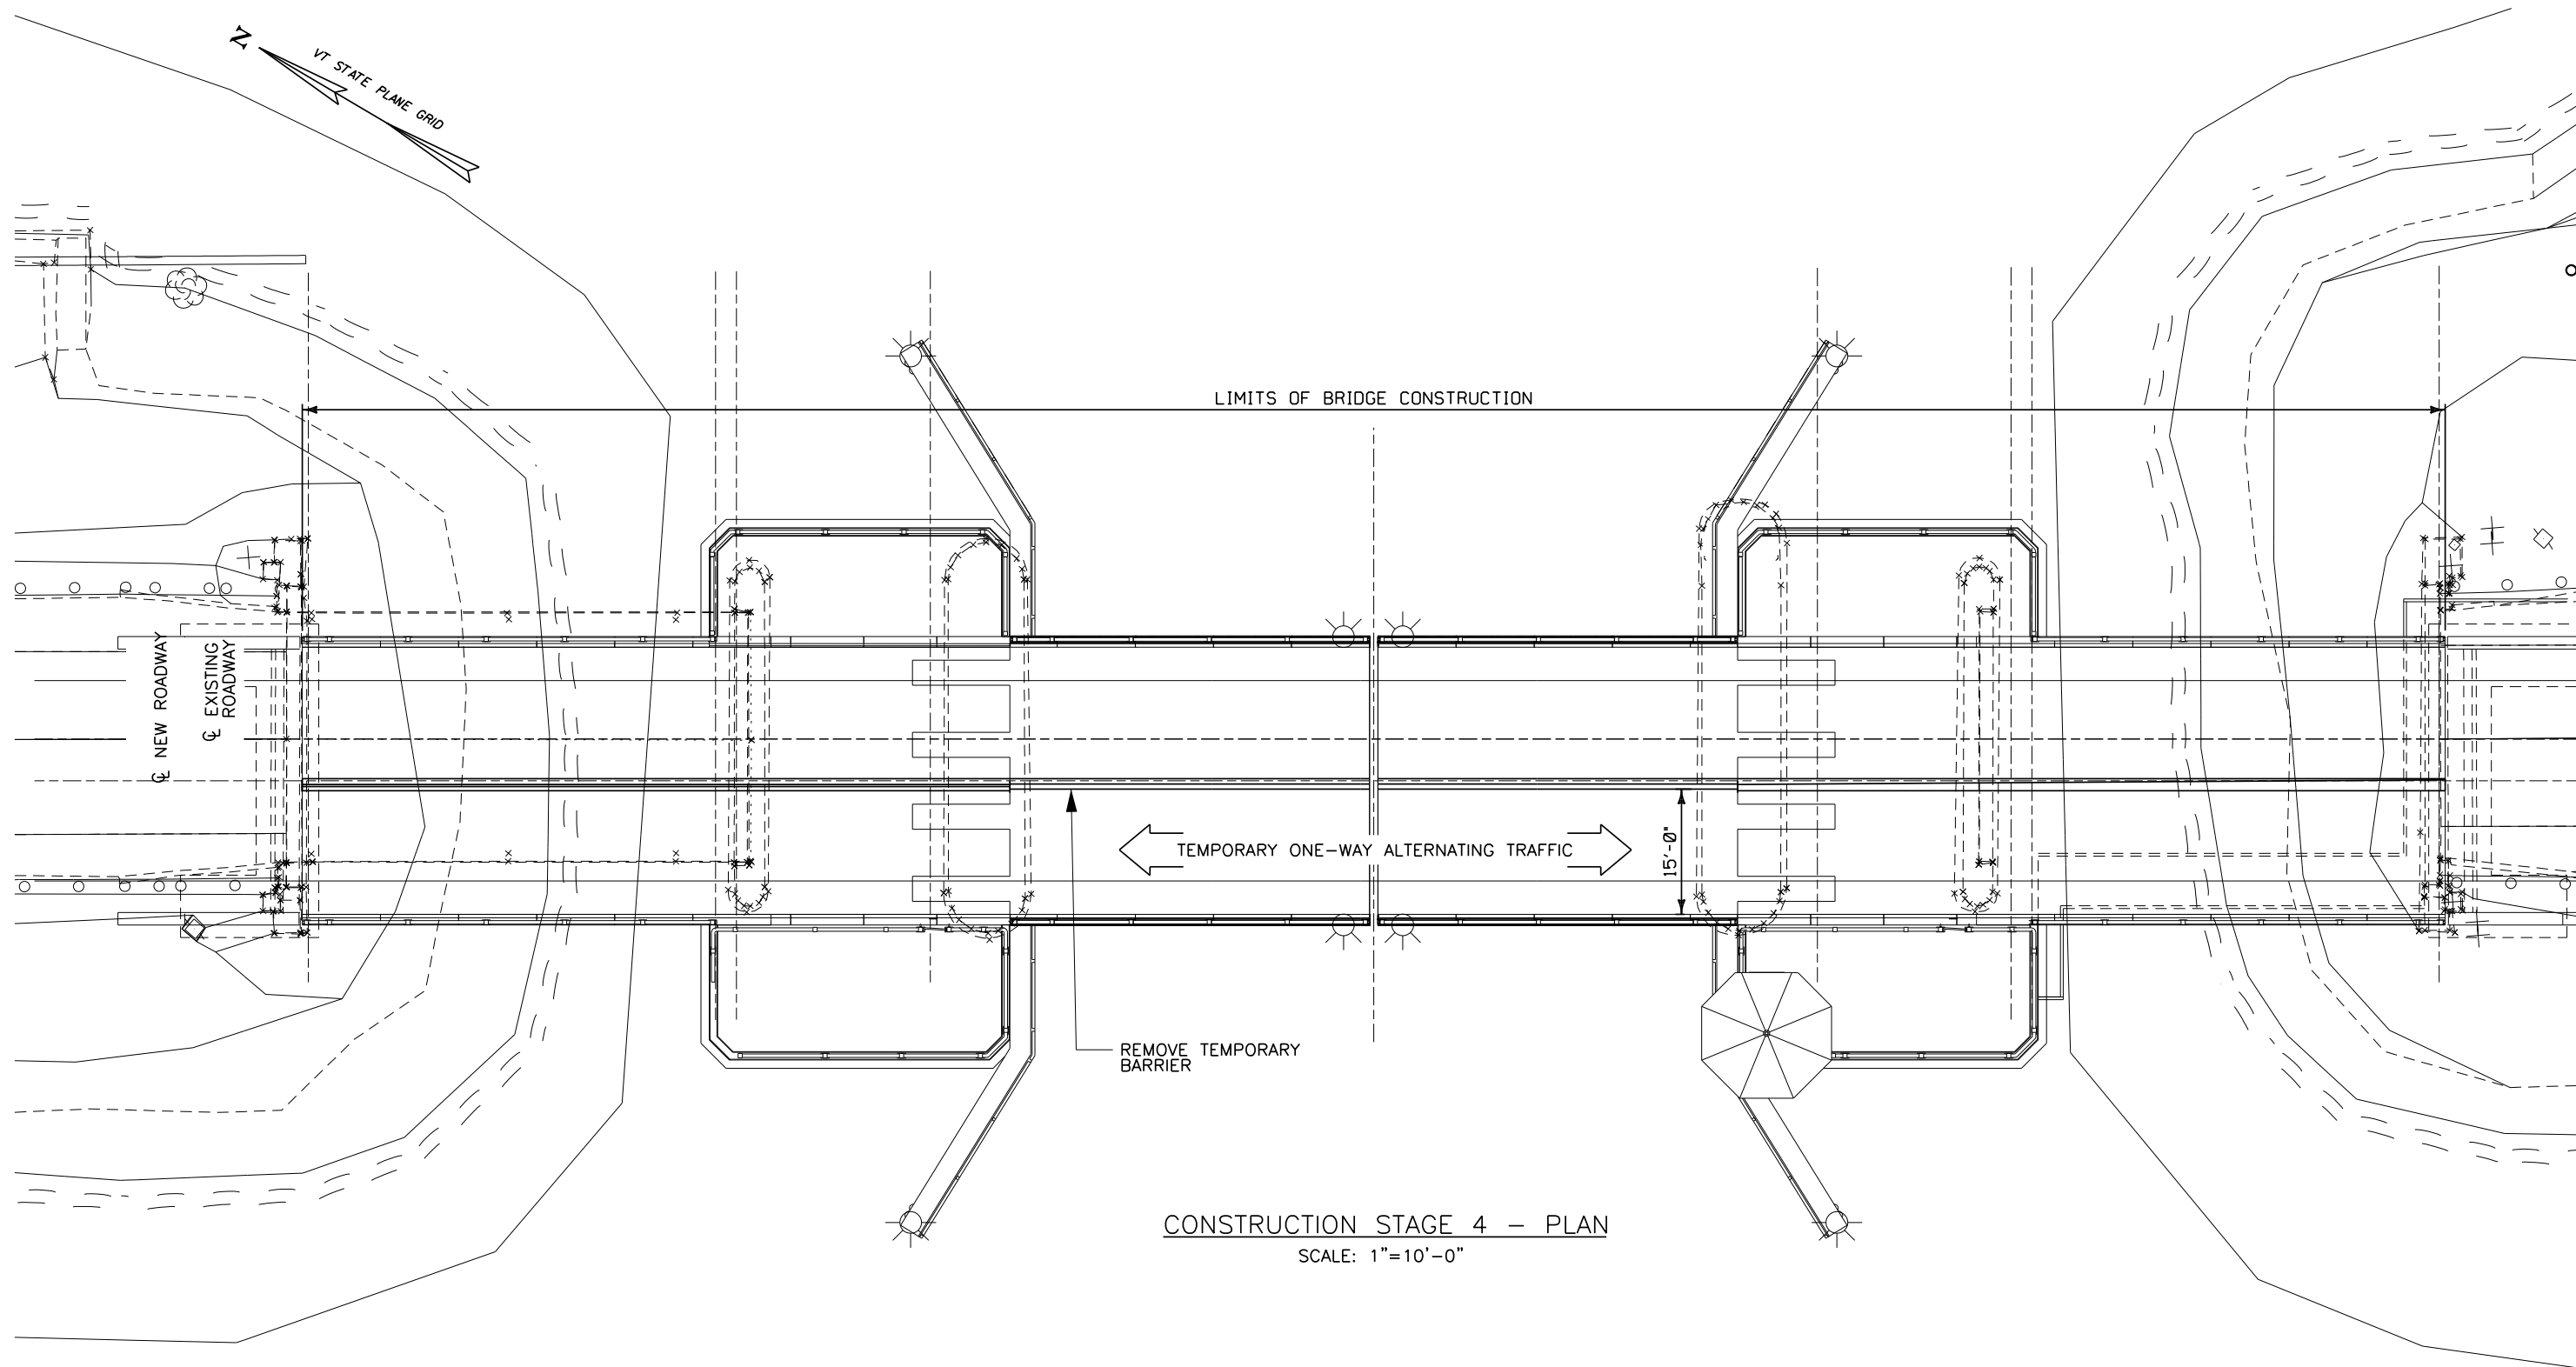


CONSTRUCTION STAGE 4 - PLAN
SCALE: 1"=10'-0"


CONCEPTUAL PLANS




PROJECT NAME: NORTH HERO GRAND ISLE BRIDGE	
PROJECT NUMBER: BHF 028-1(26)	
FILE NAME: z12b142bdr_cs4.dgn	PLOT DATE: 7/28/2015
PROJECT LEADER: C. SWANSON	DRAWN BY: P. MONTICCILO
DESIGNED BY: H. PROTIN	CHECKED BY: G. NICKELS
CONSTRUCTION STAGE 4 - PLAN	SHEET 23 OF 30

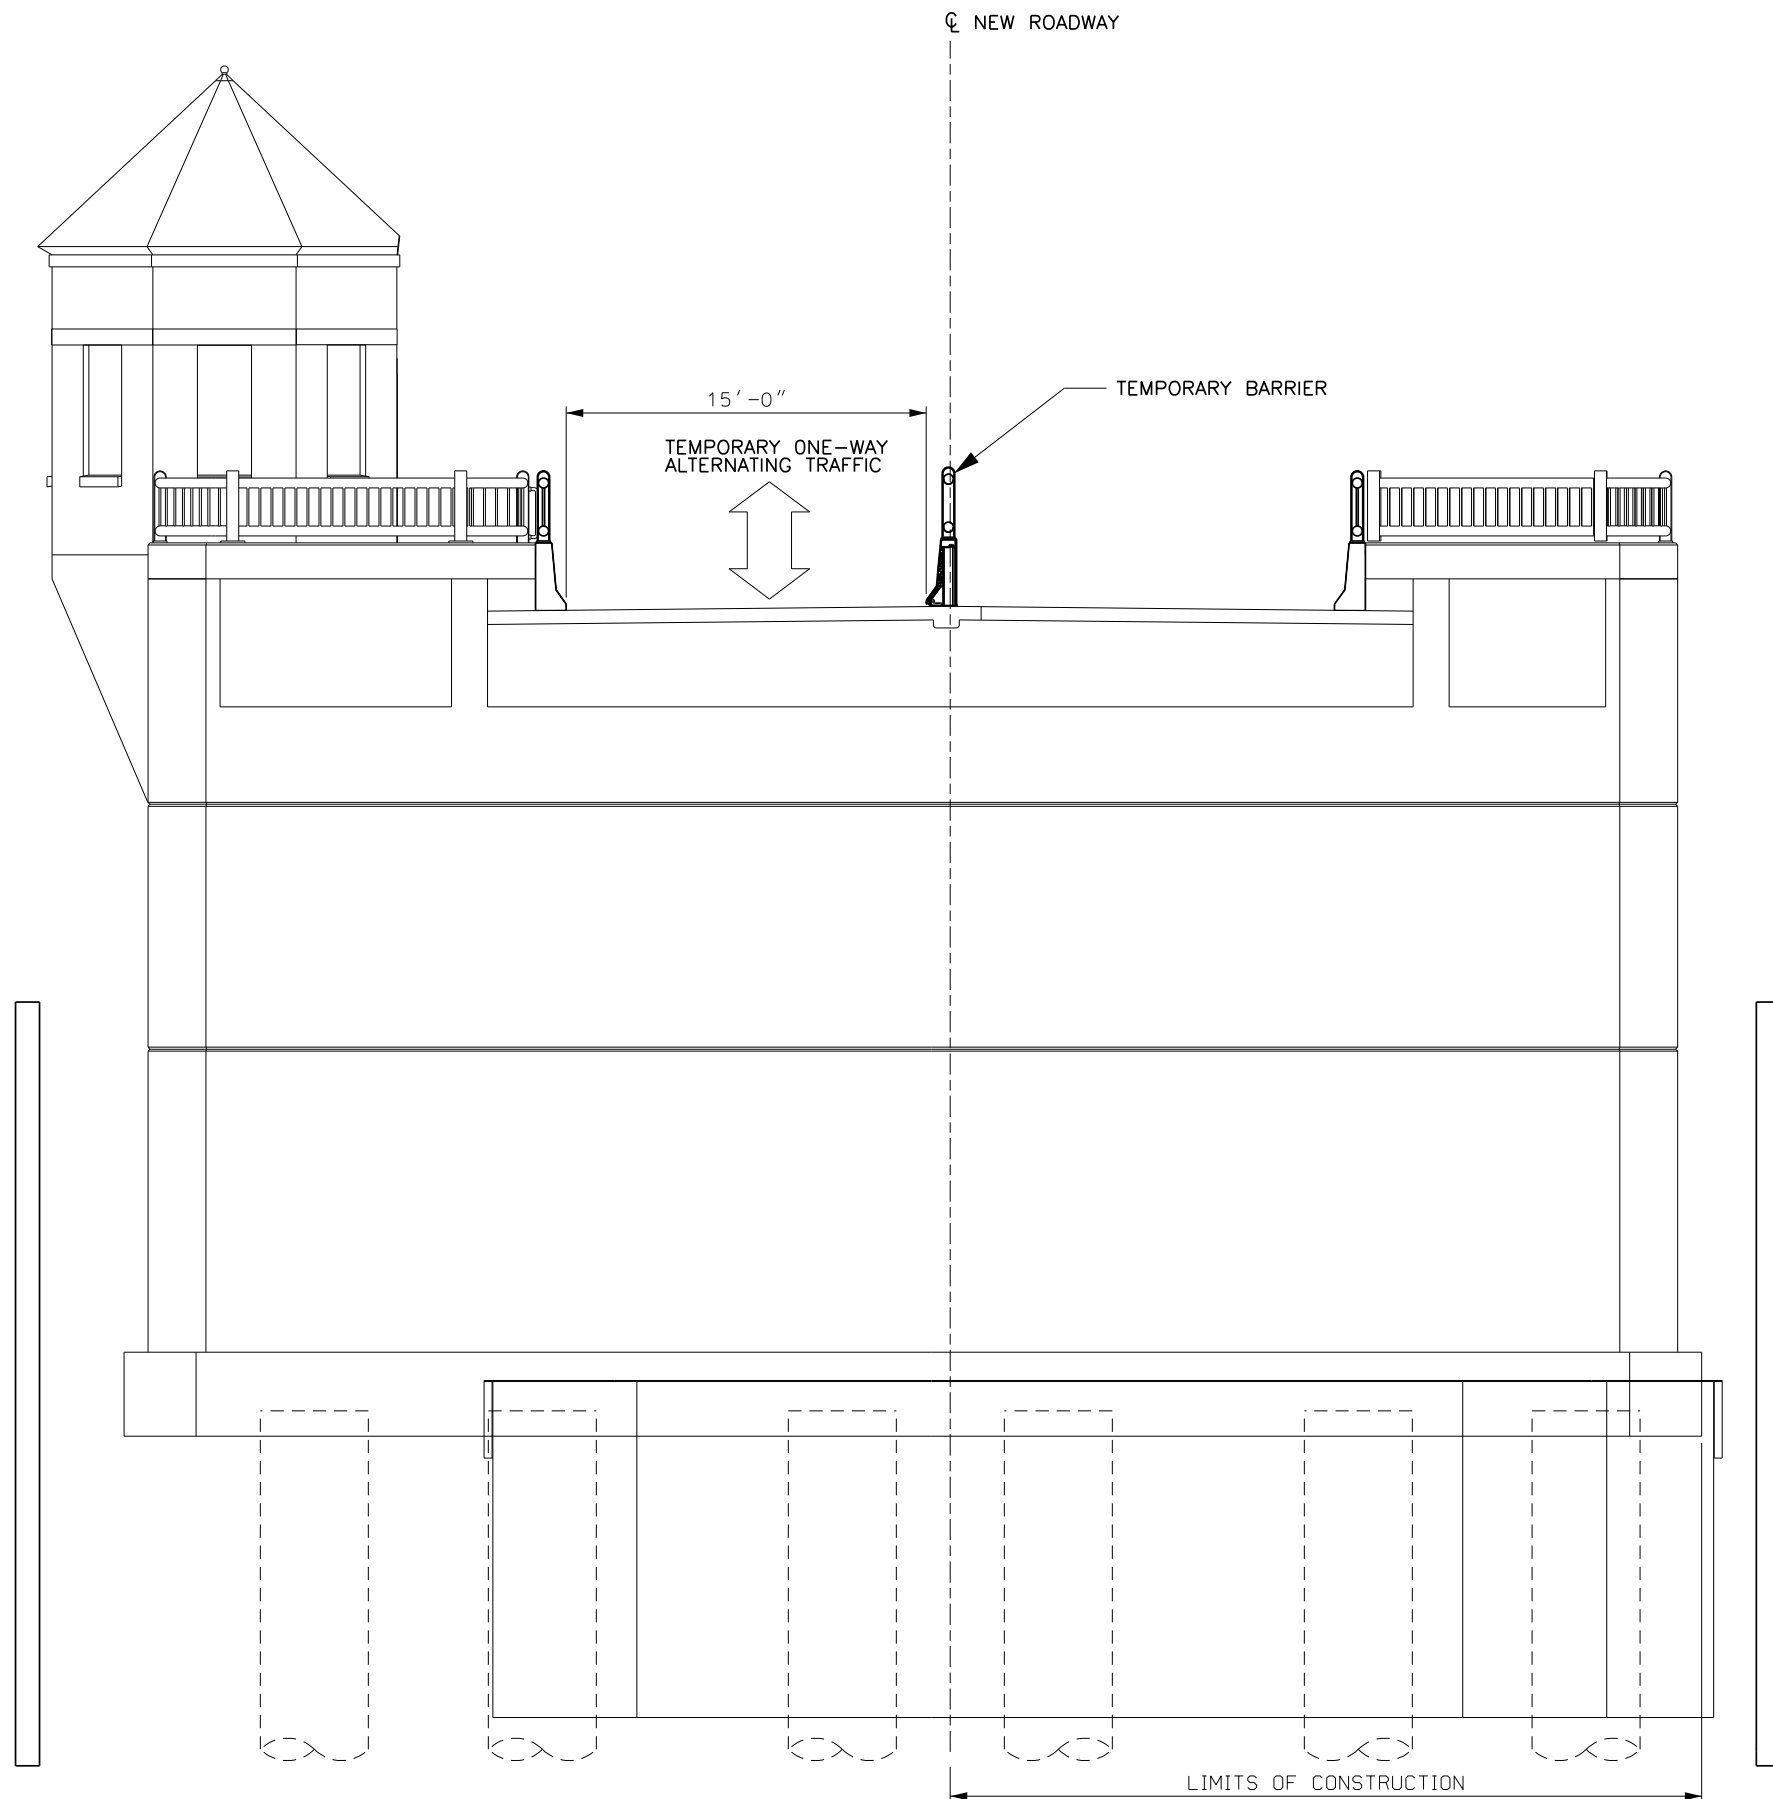

STAGE 4 – TYPICAL CONTERWEIGHT SPAN SECTION
SCALE: 1/4"=1'-0"

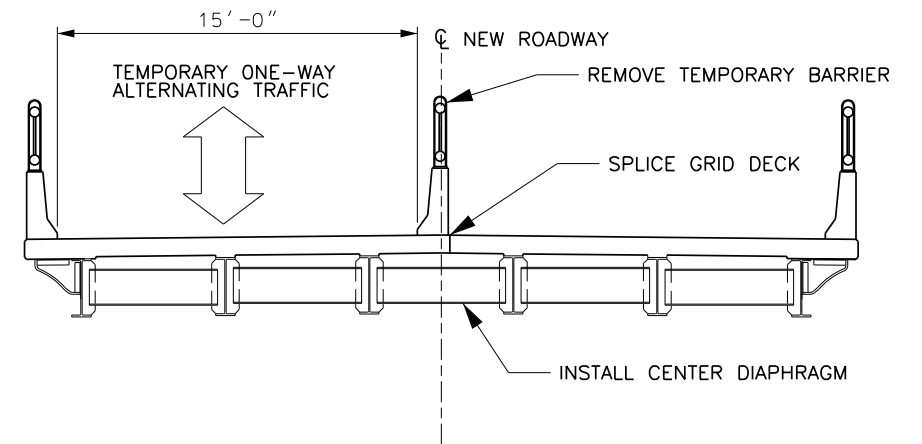

STAGE 4 – TYPICAL APPROACH SPAN SECTION
SCALE: 1/4"=1'-0"

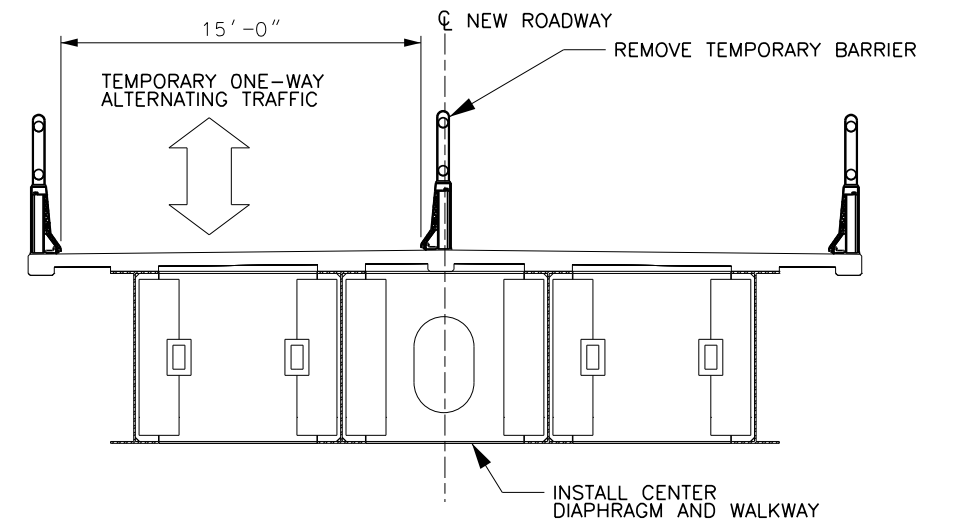


STAGE 4 – TYPICAL BASCULE SPAN SECTION
SCALE: 1/4"=1'-0"

CONCEPTUAL PLANS




PROJECT NAME: NORTH HERO GRAND ISLE BRIDGE	
PROJECT NUMBER: BHF 028-1(26)	
FILE NAME: z12b142bdr_xscs4.dgn	PLOT DATE: 7/28/2015
PROJECT LEADER: C. SWANSON	DRAWN BY: P. MONTICCILO
DESIGNED BY: H. PROTIN	CHECKED BY: G. NICKELS
CONSTRUCTION STAGE 4 - SECTIONS	SHEET 24 OF 30

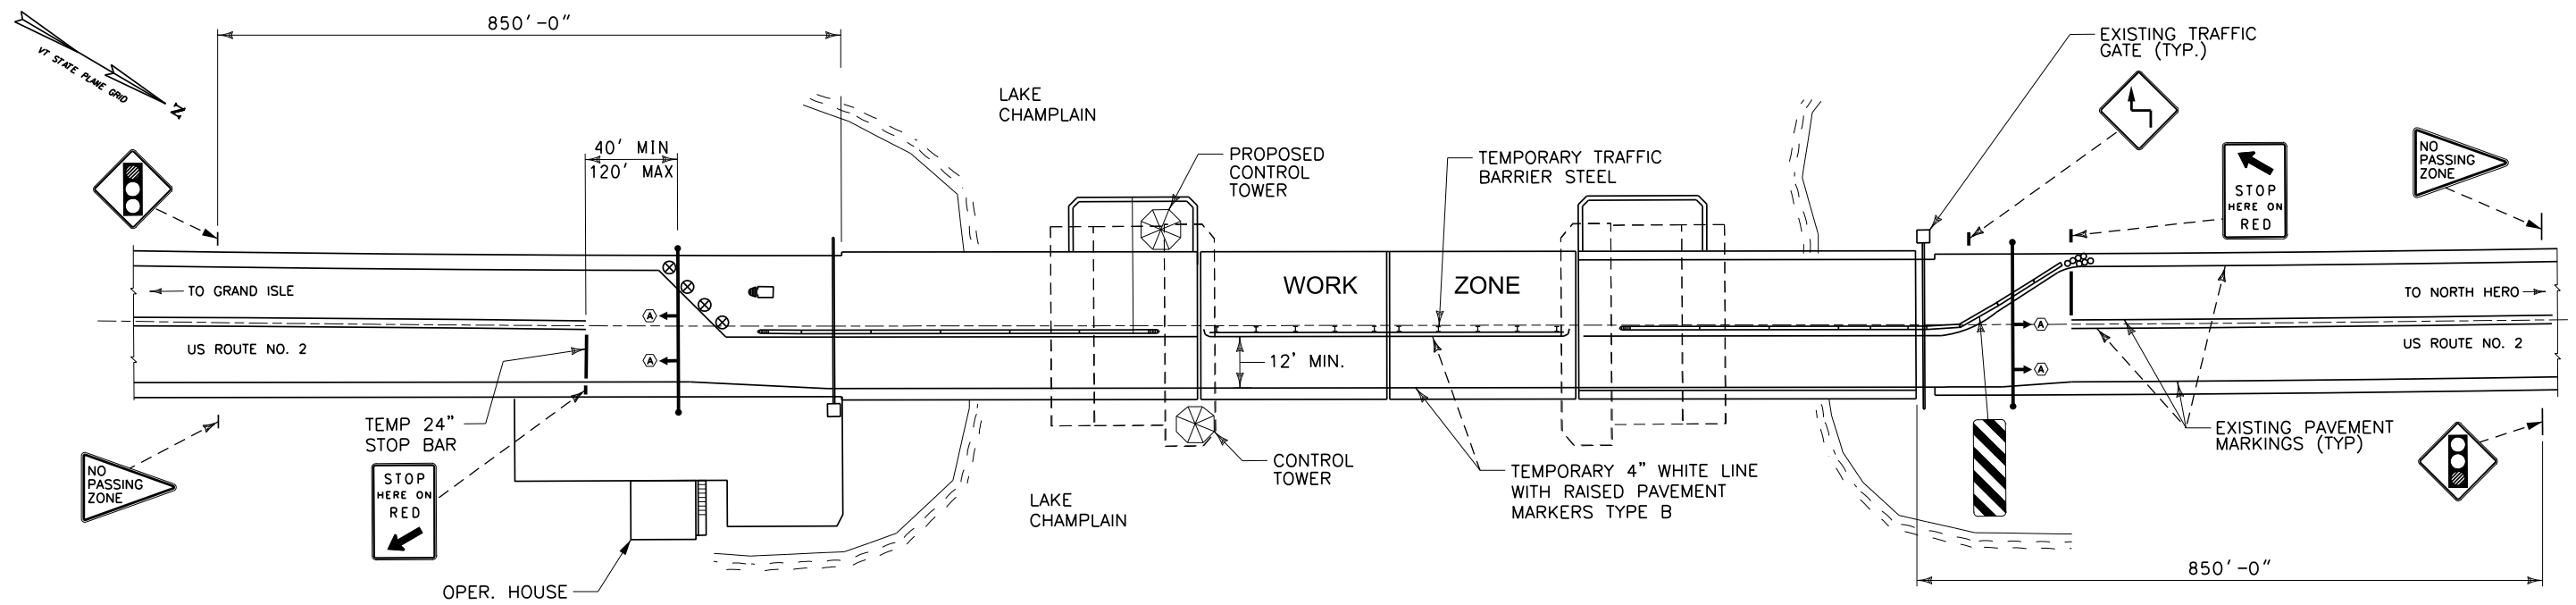


TEMPORARY TRAFFIC CONTROL - STAGE 1

SCALE: 1"=20'-0"

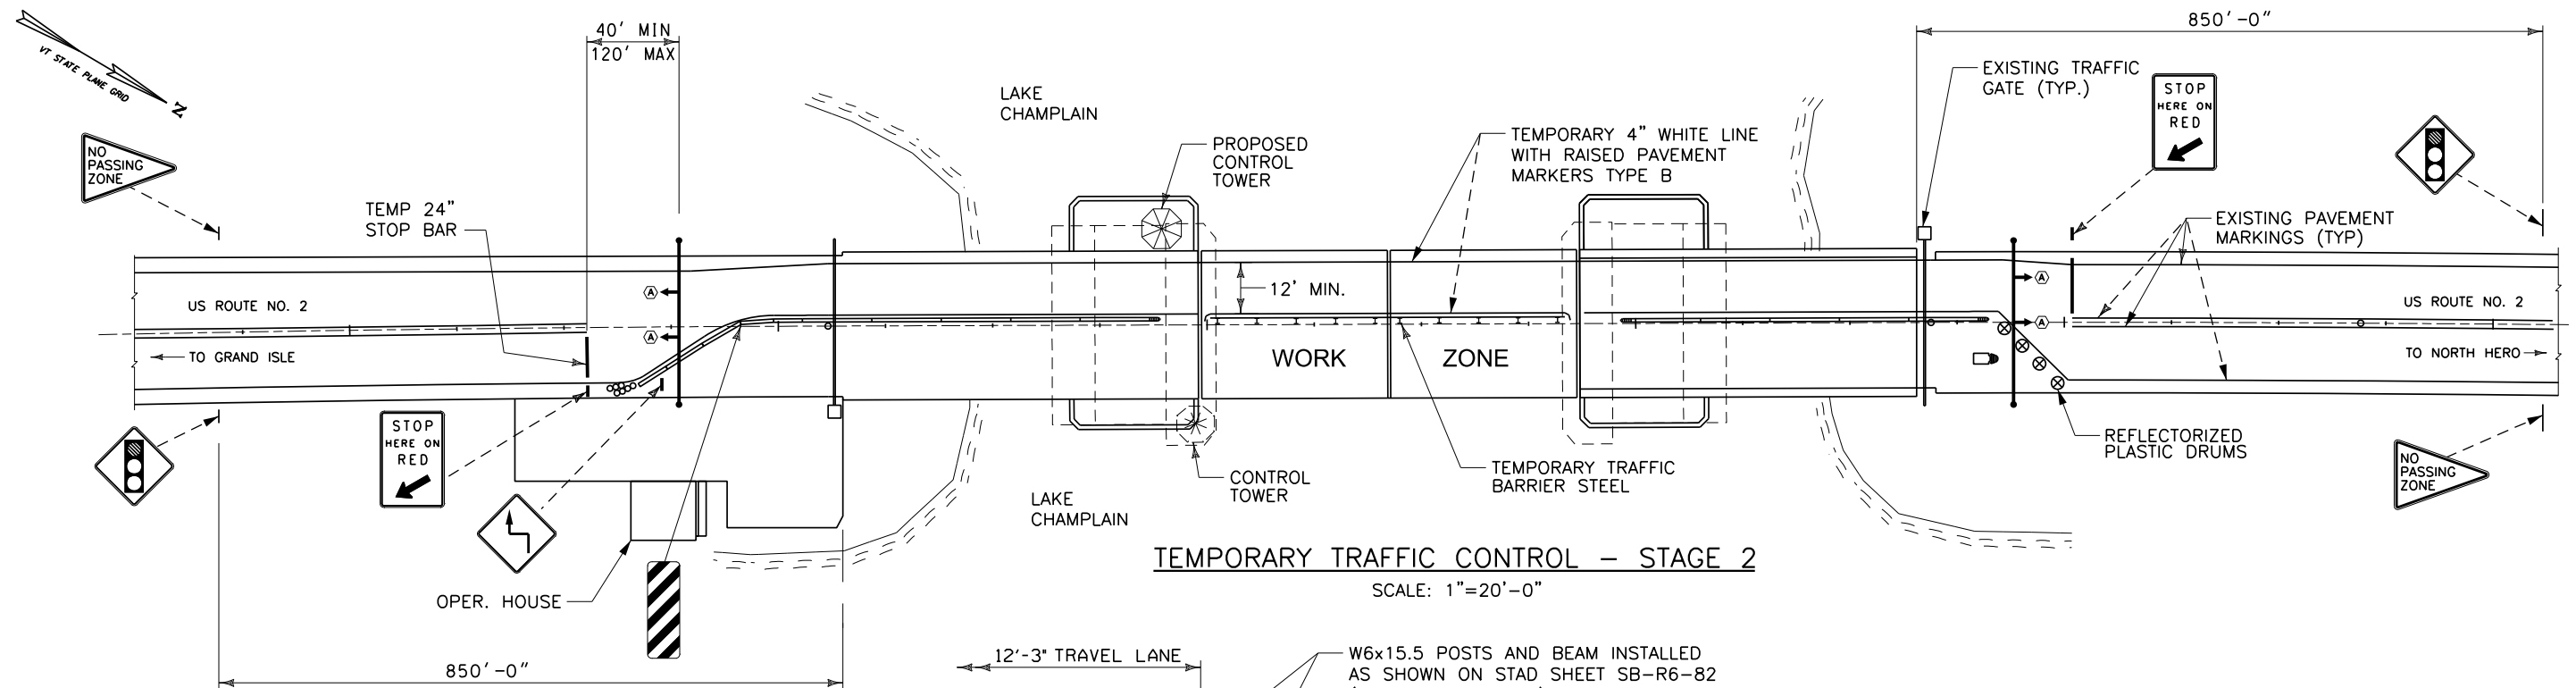

TEMPORARY TRAFFIC CONTROL - STAGE 2

SCALE: 1"=20'-0"

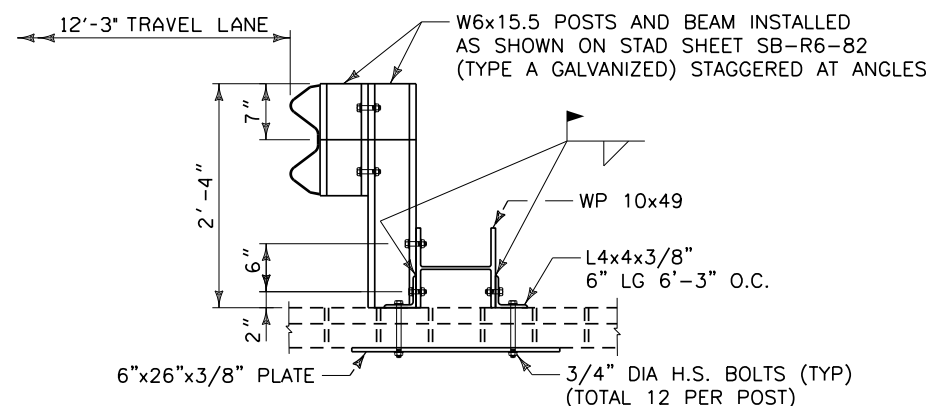

TEMPORARY TRAFFIC BARRIER STEEL


N.T.S.

CONCEPTUAL DESIGN

SCALE 1" = 20' - 0"
20 0 20

PROJECT NAME: NORTH HERO GRAND ISLE BRIDGE
PROJECT NUMBER: BHF 028-1(26)
FILE NAME: Z12b142bdr_pl4.dgn
PROJECT LEADER: C. SWANSON
DESIGNED BY: C. SWANSON
MAINTENANCE AND PROTECTION OF TRAFFIC
PLOT DATE: 10/27/2014
DRAWN BY: D. DOUGHERTY
CHECKED BY: C. SWANSON
SHEET 24 OF 30



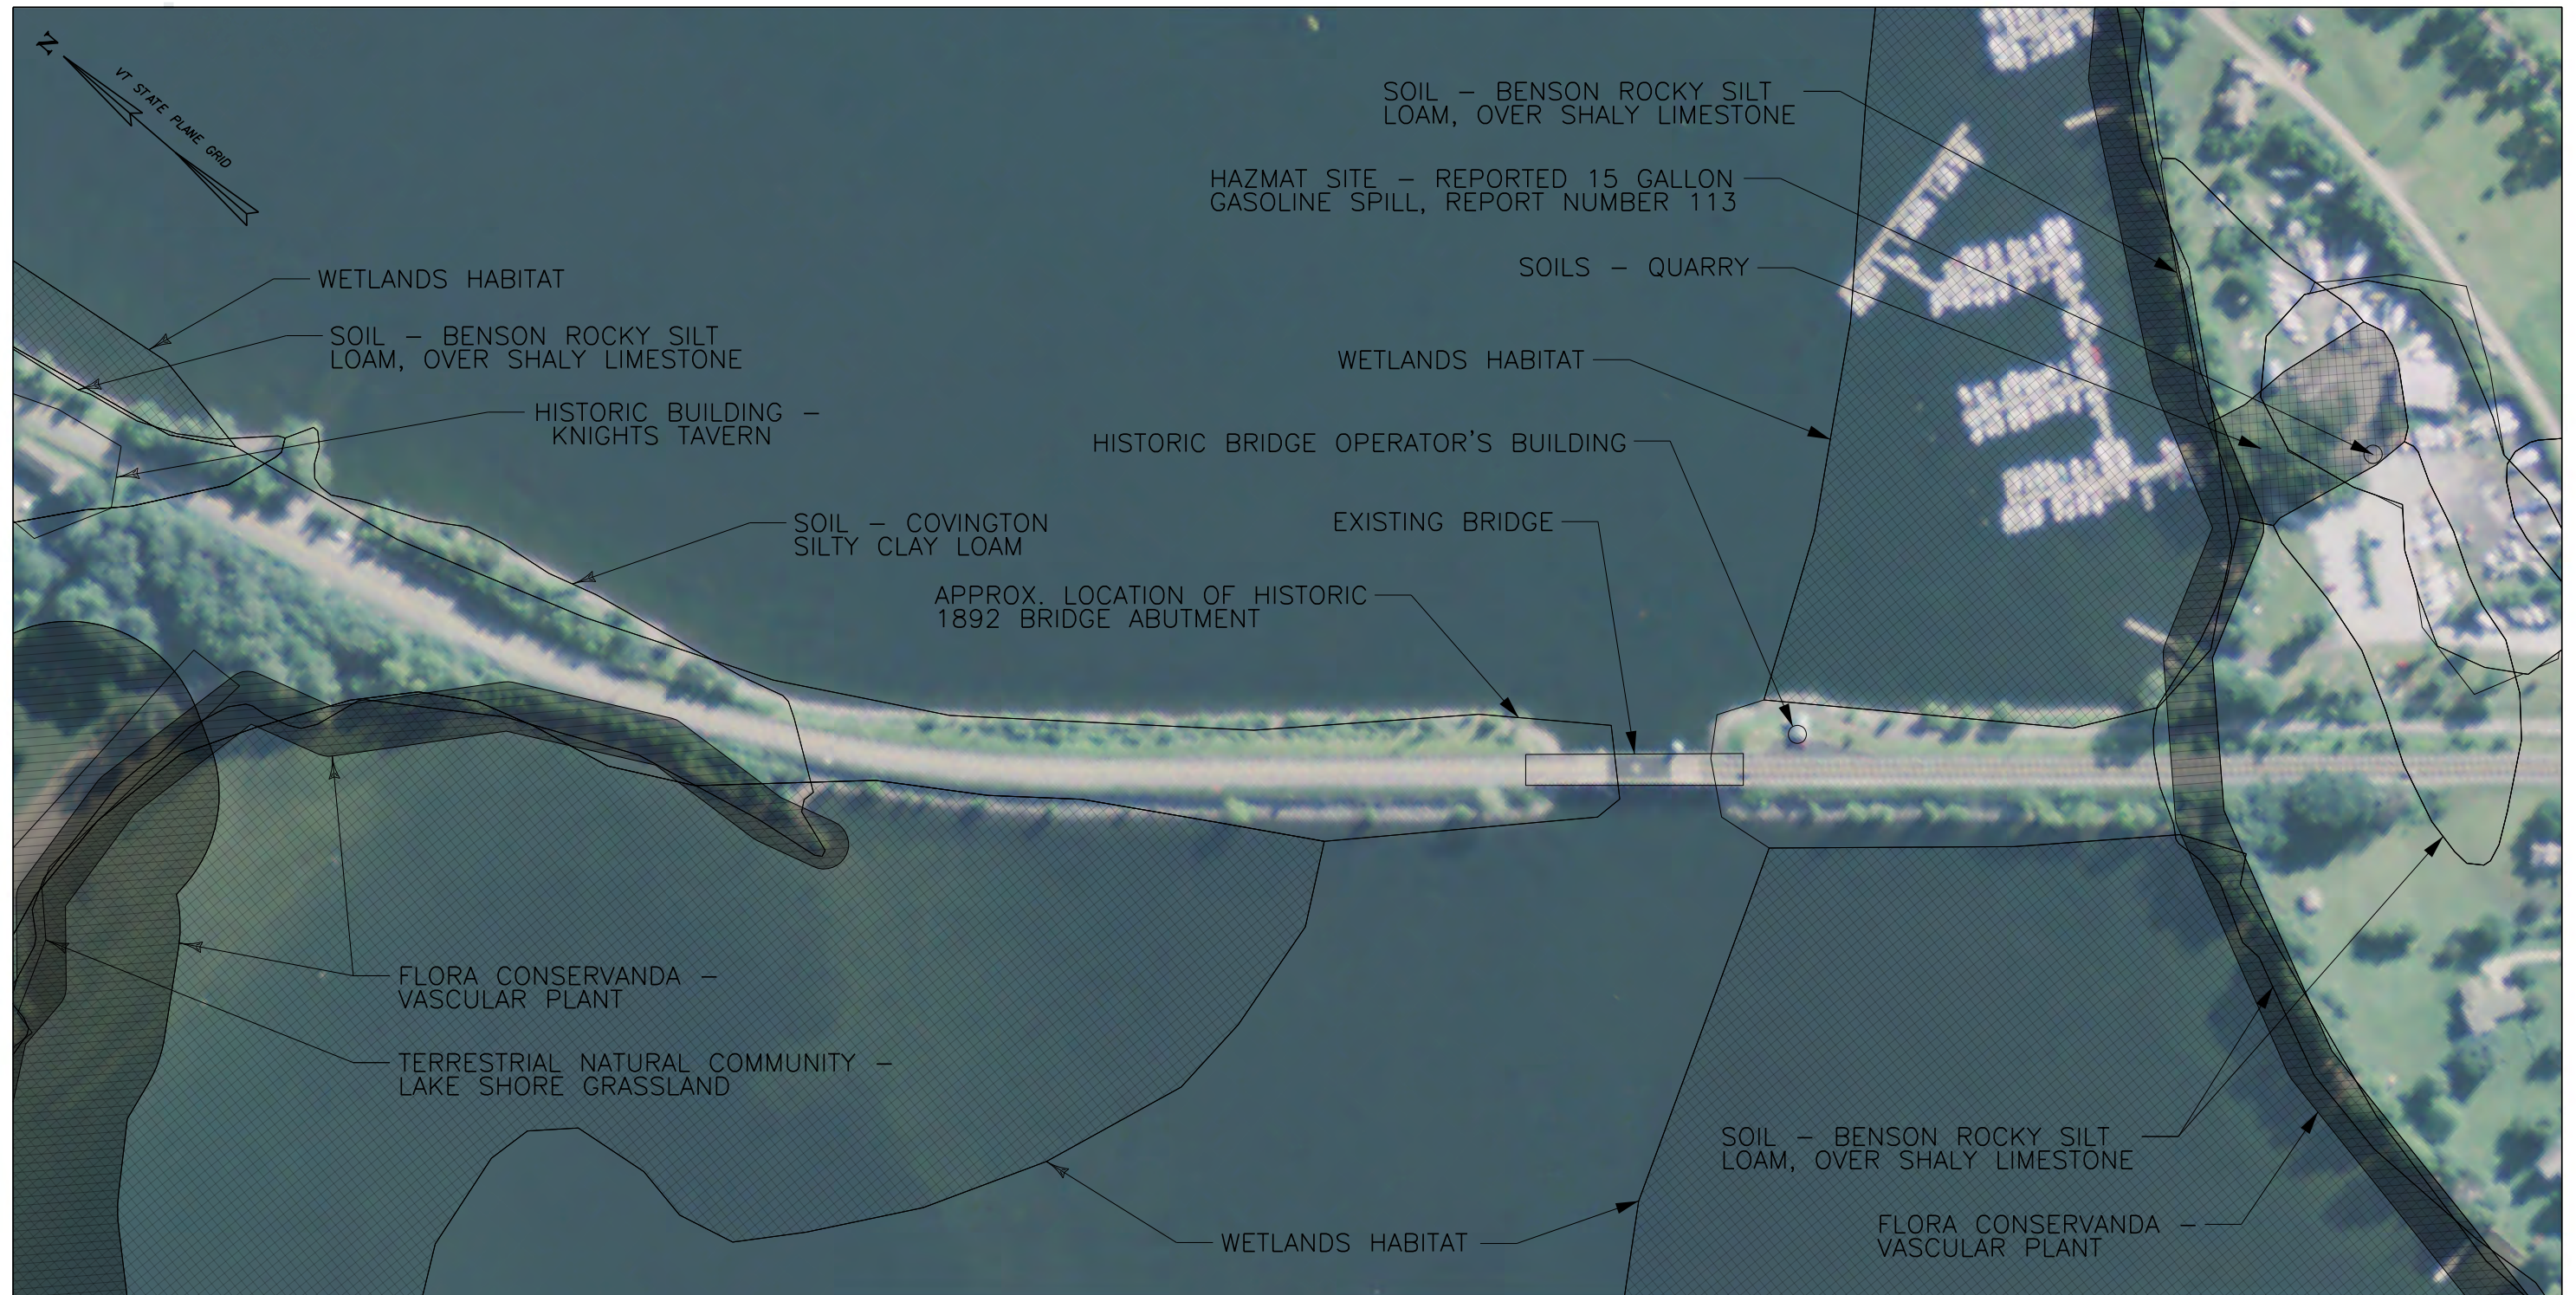



CONCEPTUAL PLANS

SCALE 1" = 100'-0"

100 0 100



PROJECT NAME:	NORTH HERO GRAND ISLE BRIDGE	PLOT DATE:	10/27/2014
PROJECT NUMBER:	BHF 028-1(26)	DRAWN BY:	K. KRETSCH
FILE NAME:	Z12b142bdr_RSP.dgn	CHECKED BY:	C. SWANSON
PROJECT LEADER:	C. SWANSON	SHEET	X OF 14
DESIGNED BY:	C. SWANSON		
RESOURCE SITE PLAN			

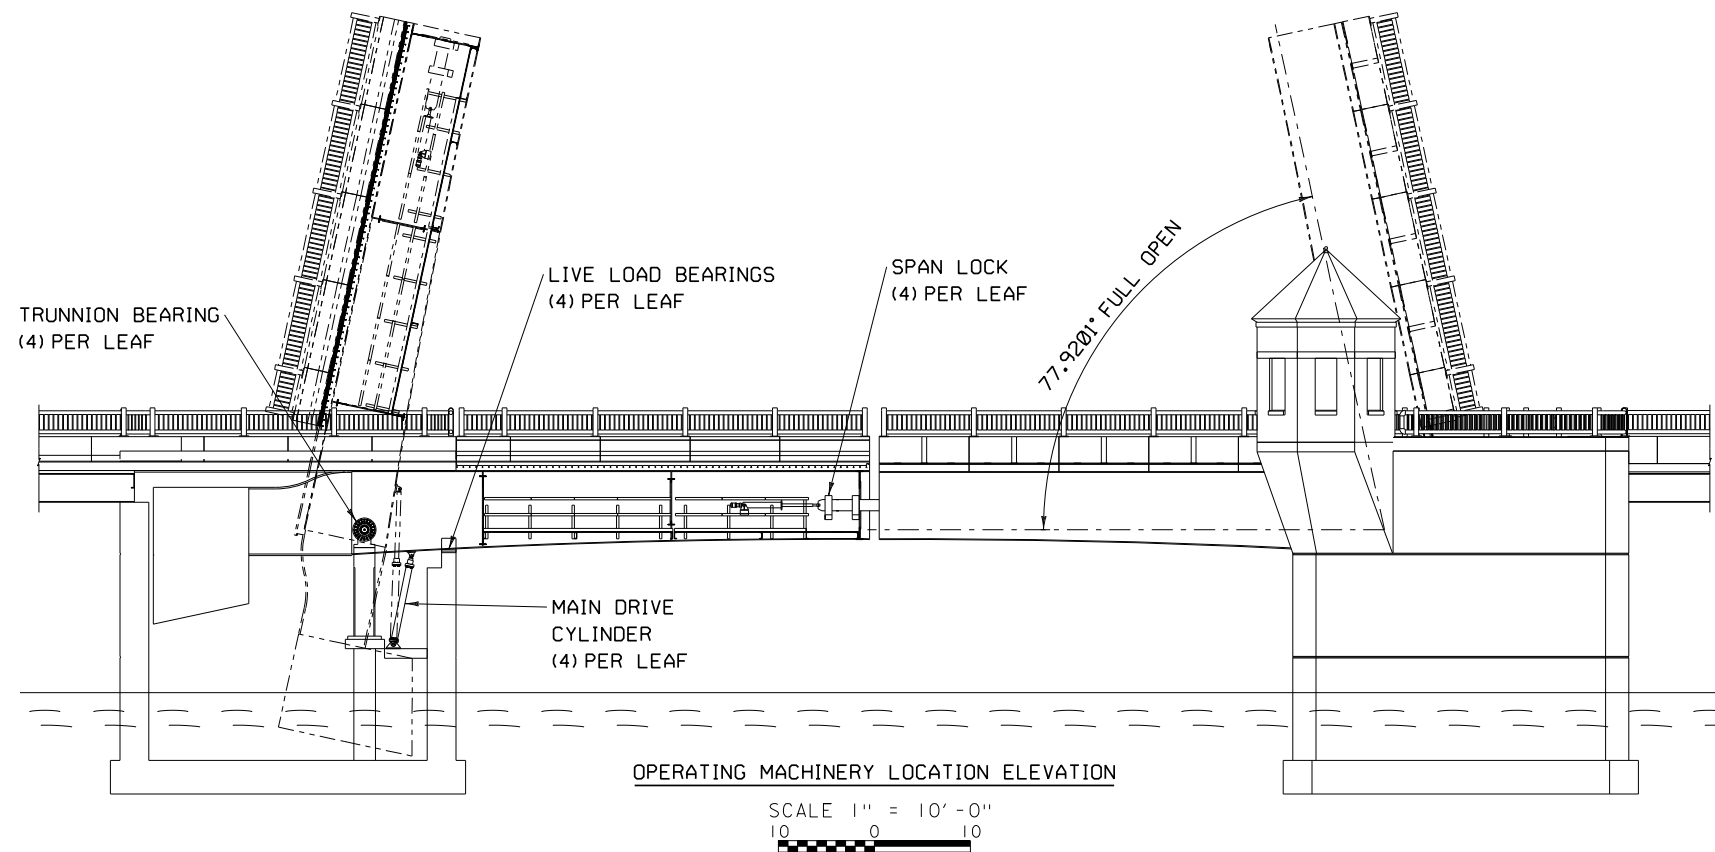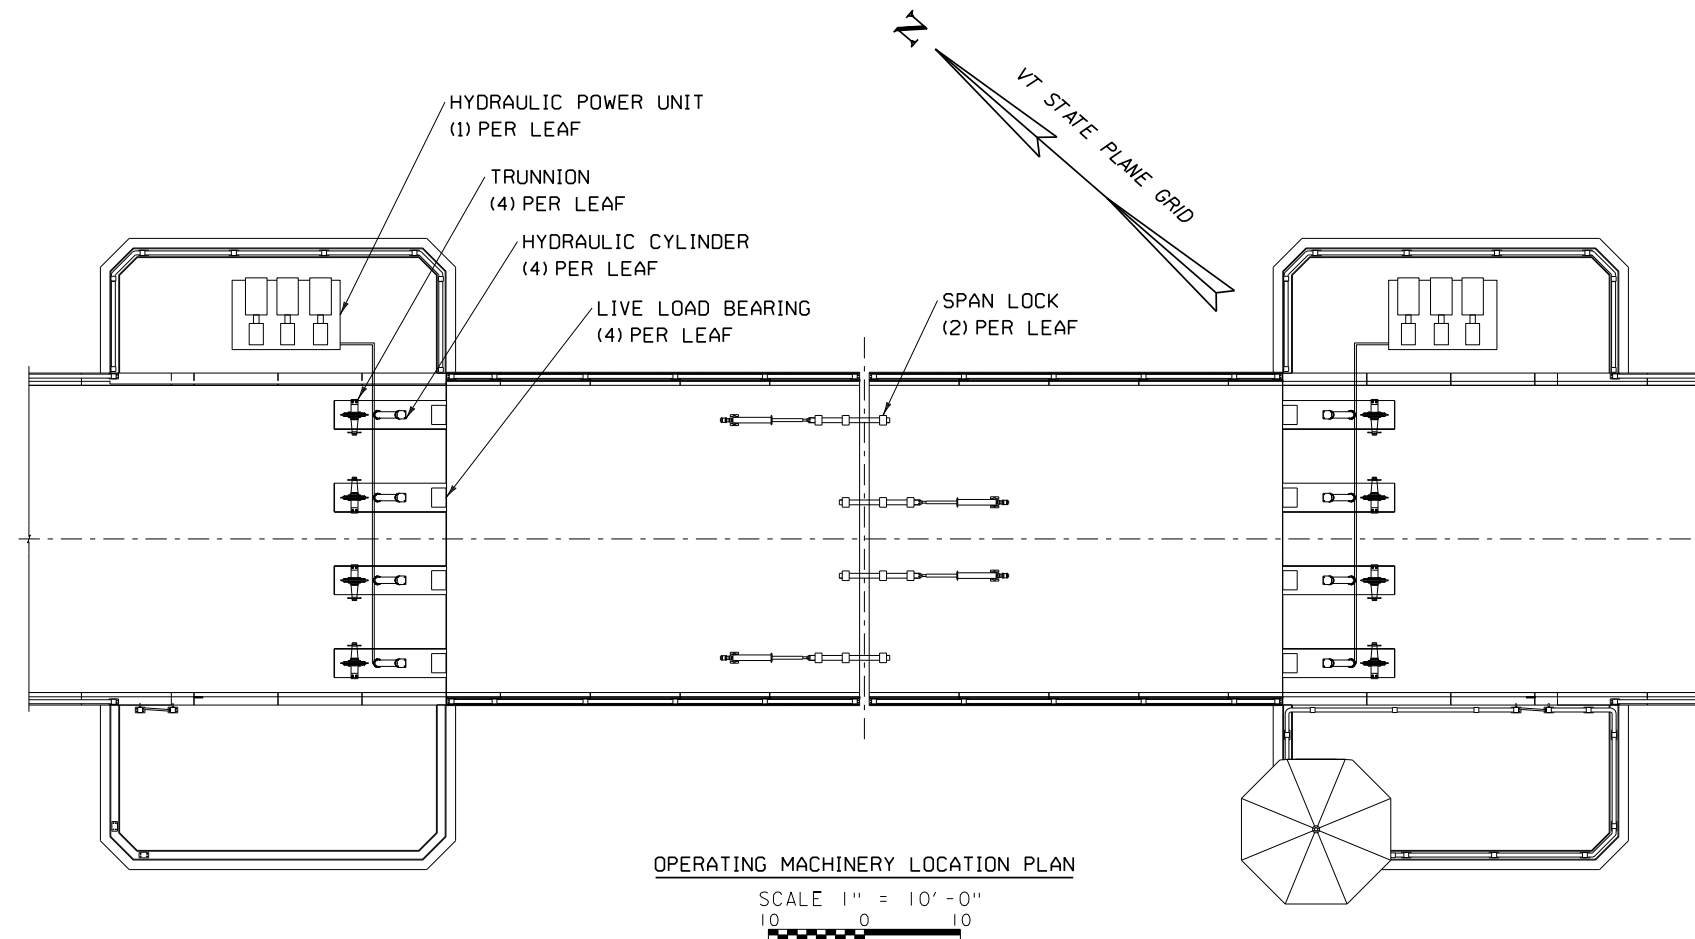

SPAN DRIVE MACHINERY


MAIN SPAN DRIVE MACHINERY WILL CONSIST OF (4) HYDRAULIC CYLINDERS PER LEAF LOCATED UNDER EACH BASCULE GIRDER. THE CYLINDERS WILL BE DESIGNED WITH ENOUGH CAPACITY SUCH THAT THE SPAN CAN BE OPERATED IN THE EVENT THAT ONE CYLINDER FAILS. CYLINDERS WILL BE DRIVEN USING A HPU LOCATED WITHIN EACH PIER. HPUS WILL BE SIZED WITH MULTIPLE PUMPS FOR REDUNDANCY. HYDRAULIC CYLINDERS WILL BE MOUNTED USING SPHERICAL BEARINGS.

SPAN SUPPORT MACHINERY

EACH LEAF WILL ROTATE ABOUT TRUNNION BEARINGS AT EACH BASCULE GIRDER (4 TOTAL PER LEAF). TRUNNIONS WILL BE INSTALLED USING SPHERICAL ROLLER BEARINGS.

IN THE SEATED POSITION THE SPAN WILL BE LOCKED USING FOUR ACTUATED BARS; ONE LOCATED AT EACH BASCULE GIRDER. THE BARS WILL BE ACTUATED USING ELECTRICALLY DRIVEN SCREW TYPE ACTUATORS.



LIVE LOAD BEARINGS WILL BE INSTALLED UNDER EACH GIRDER.

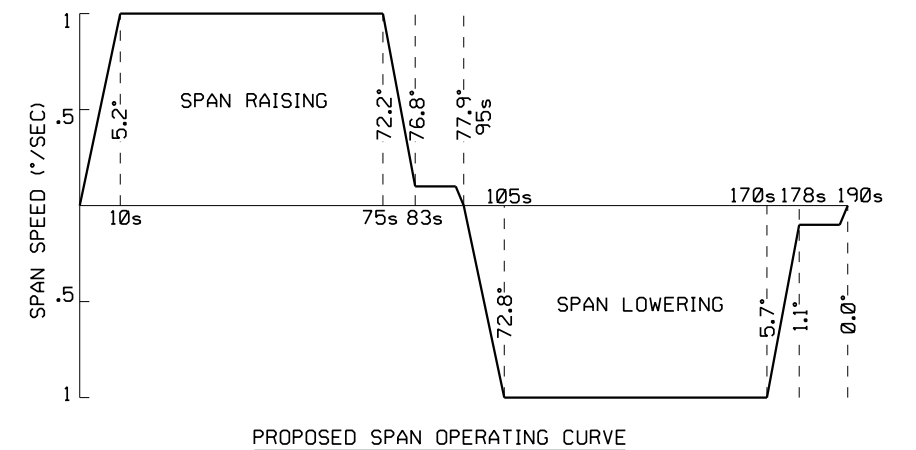

DESIGN CONCEPT

**DOUBLE LEAF
BASCULE
ON-LINE
ALTERNATIVE**




PROJECT NAME: NORTH HERO GRAND ISLE BRIDGE	
PROJECT NUMBER: BHF 028-1(26)	
FILE NAME: Z12b142bdr_ pl1.dgn	PLOT DATE: 10/27/2014
PROJECT LEADER: C. SWANSON	DRAWN BY: C. MADDEN
DESIGNED BY: C. SWANSON	CHECKED BY: C. SWANSON
PROPOSED OPERATING MACHINERY	SHEET 26 OF 28

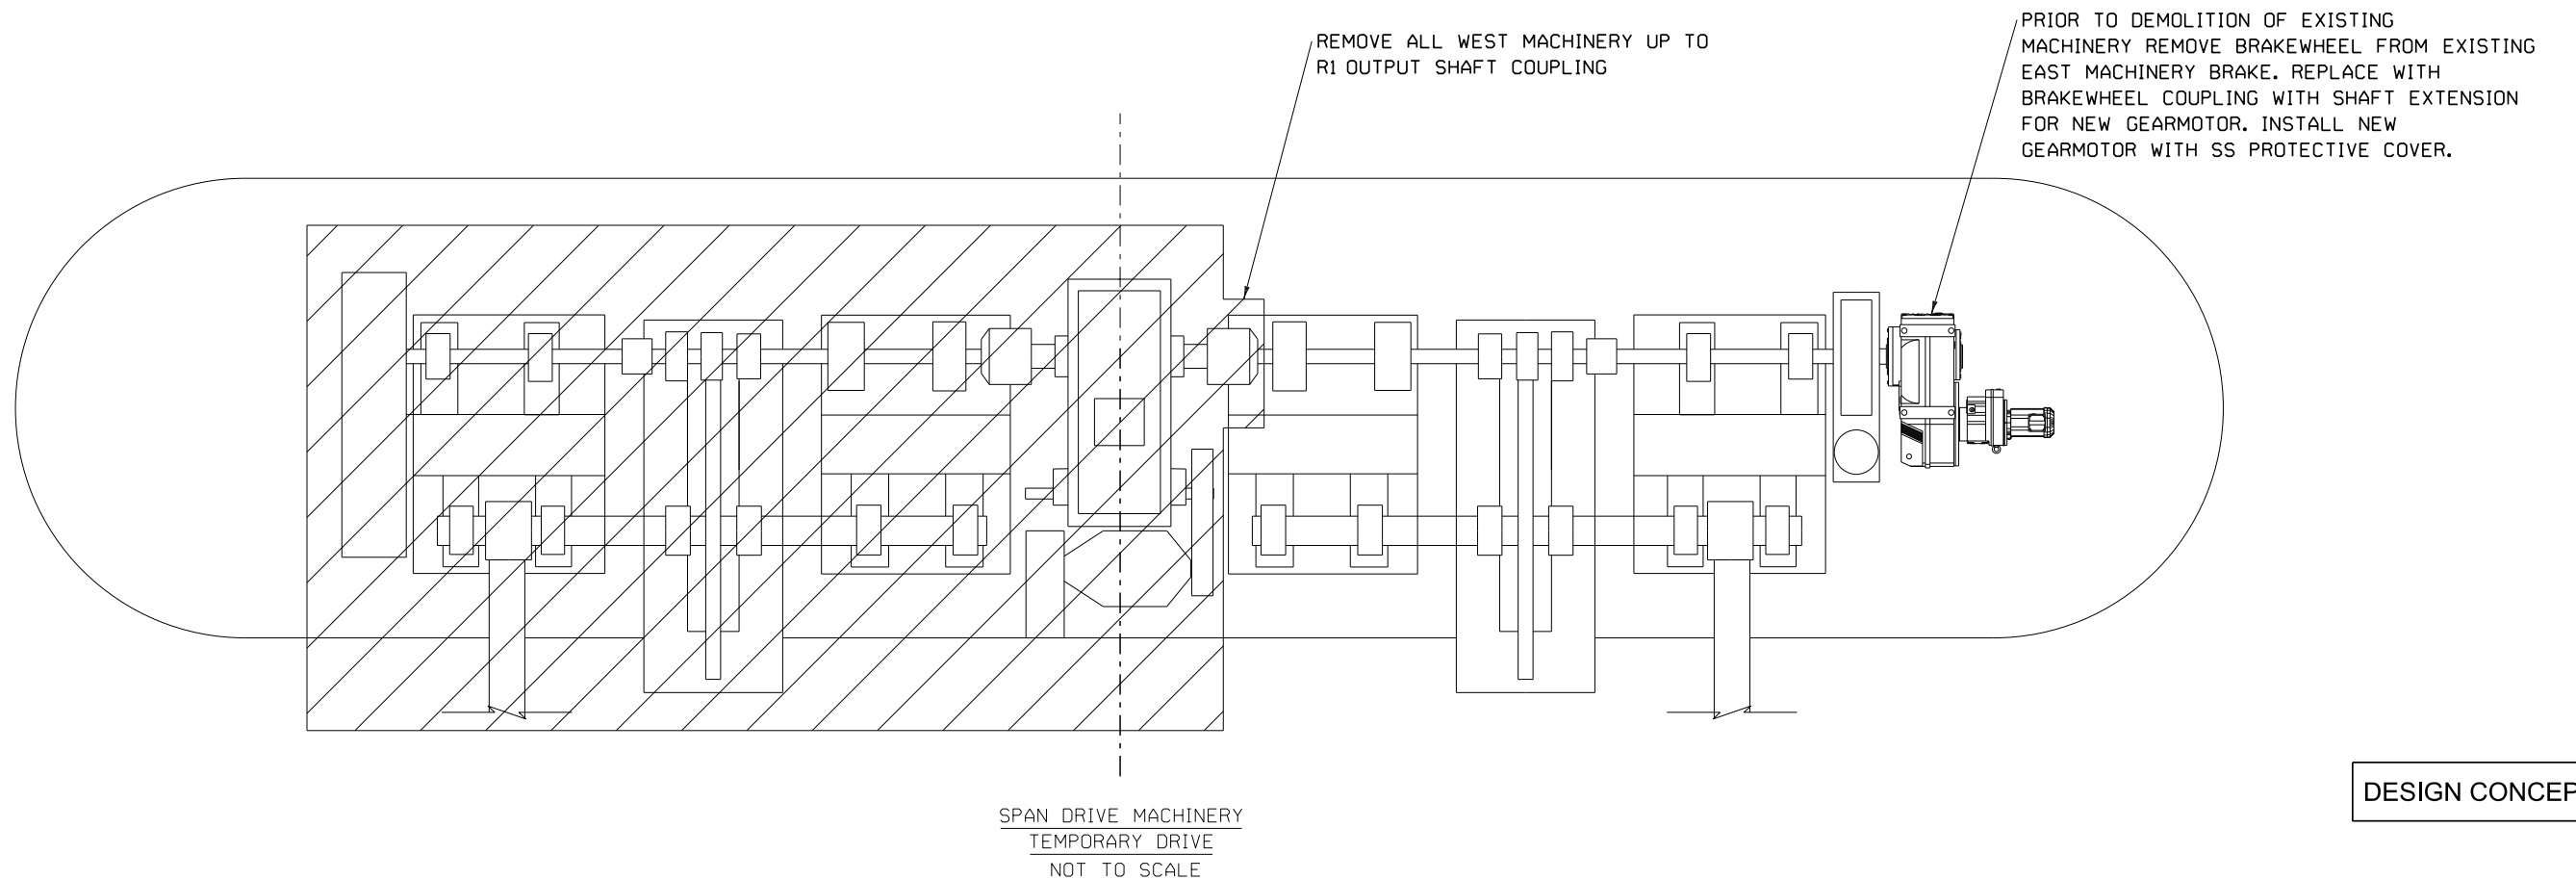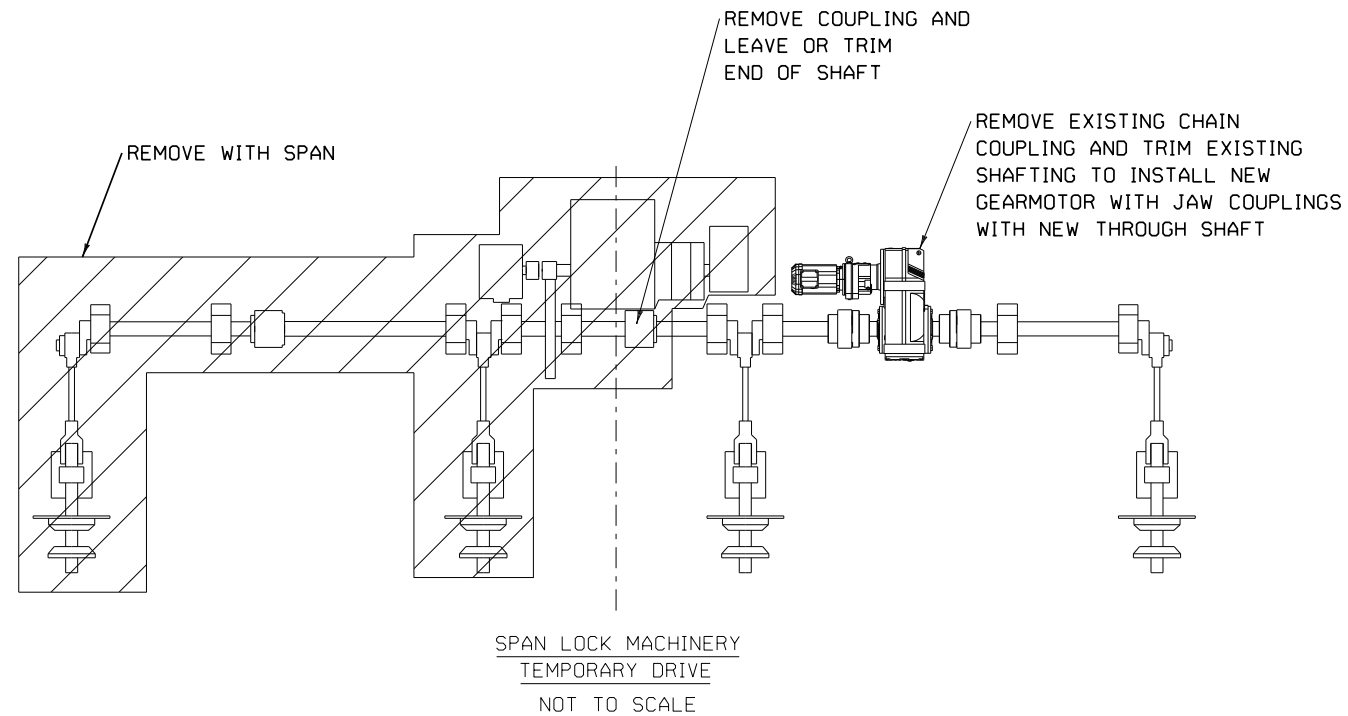


DESIGN CONCEPT

**DOUBLE LEAF
BASCULE
ON-LINE
ALTERNATIVE**


PROJECT NAME: NORTH HERO GRAND ISLE BRIDGE	
PROJECT NUMBER: BHF 028-1(26)	
FILE NAME: Z12b142bdr_ pl1.dgn	PLOT DATE: 10/27/2014
PROJECT LEADER: C. SWANSON	DRAWN BY: C. MADDEN
DESIGNED BY: C. SWANSON	CHECKED BY: C. SWANSON
TEMPORARY MACHINERY	SHEET 27 OF 30

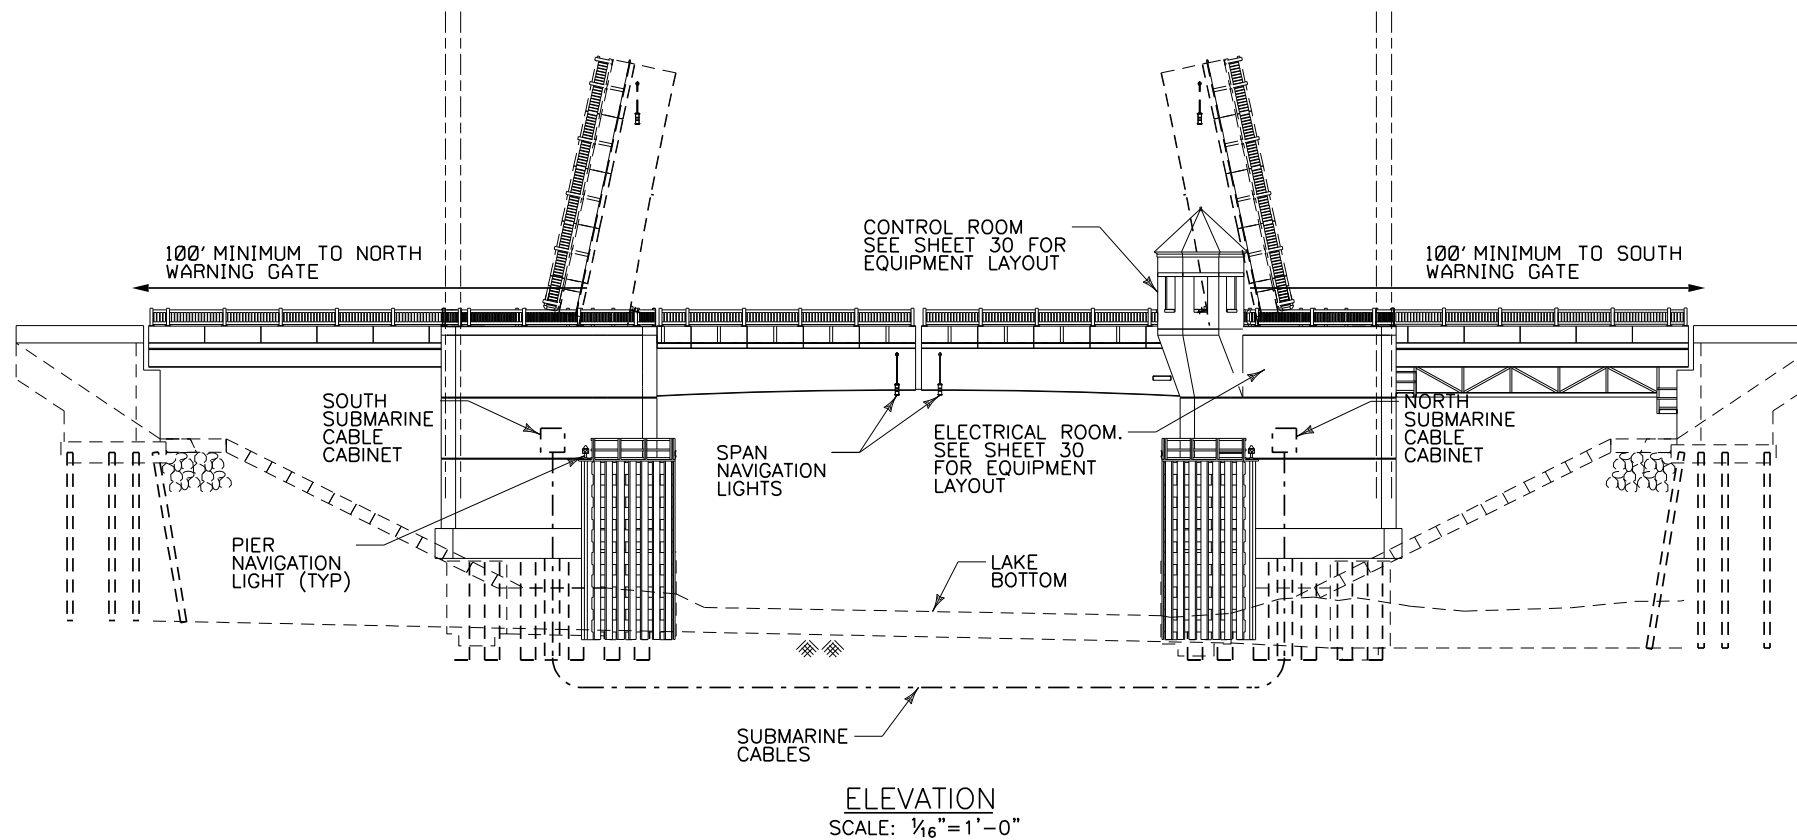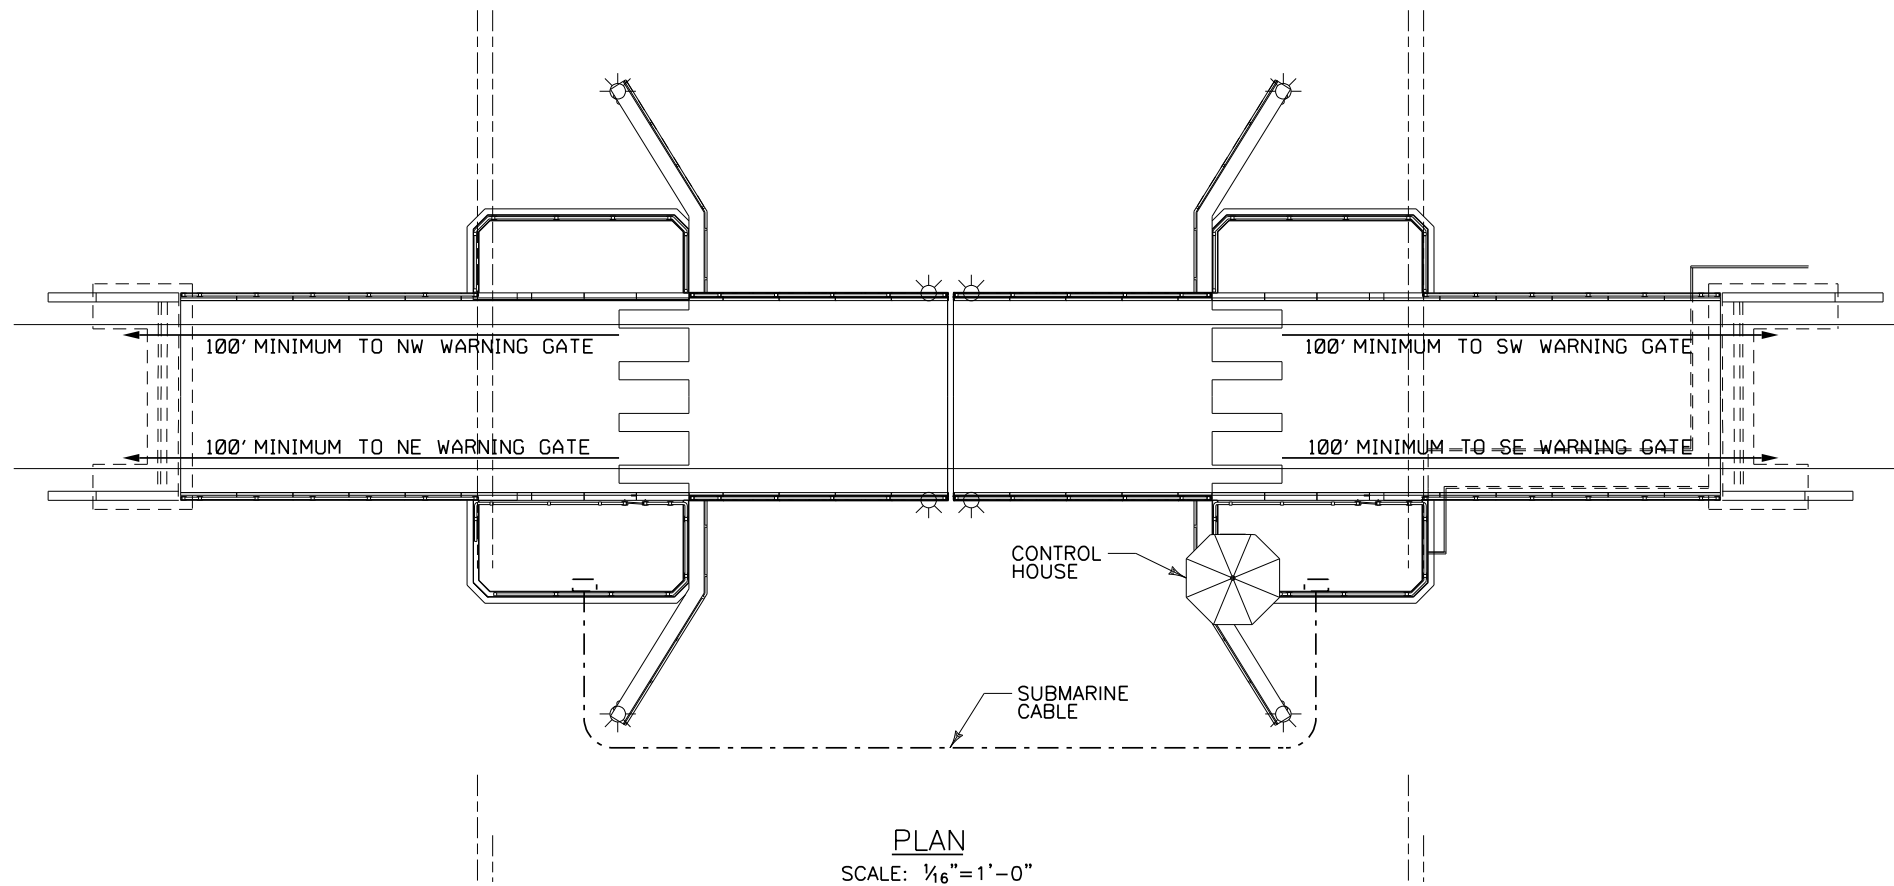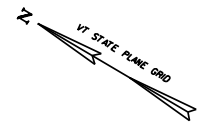


DESIGN CONCEPT

 

PROJECT NAME: NORTH HERO GRAND ISLE BRIDGE	
PROJECT NUMBER: BHF 028-1(26)	
FILE NAME: Z12b142bdr_elecgpe.dgn	PLOT DATE: 7/24/2015
PROJECT LEADER: C. SWANSON	DRAWN BY: Y. ADELEKAN
DESIGNED BY: Y. ADELEKAN	CHECKED BY: H. PROTIN
ELECTRICAL PLAN AND ELEVATION	SHEET 29 OF 30

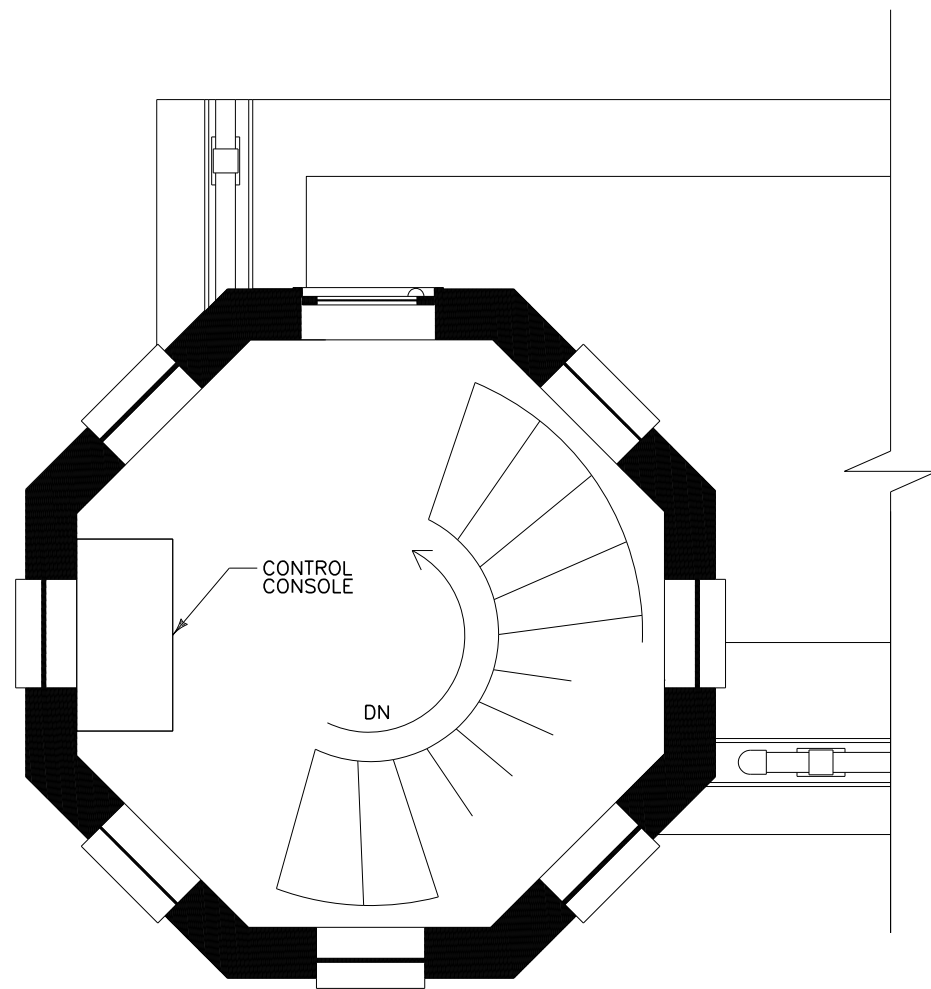

CONTROL ROOM ROADWAY LEVEL
SCALE: 1/2"=1'-0"

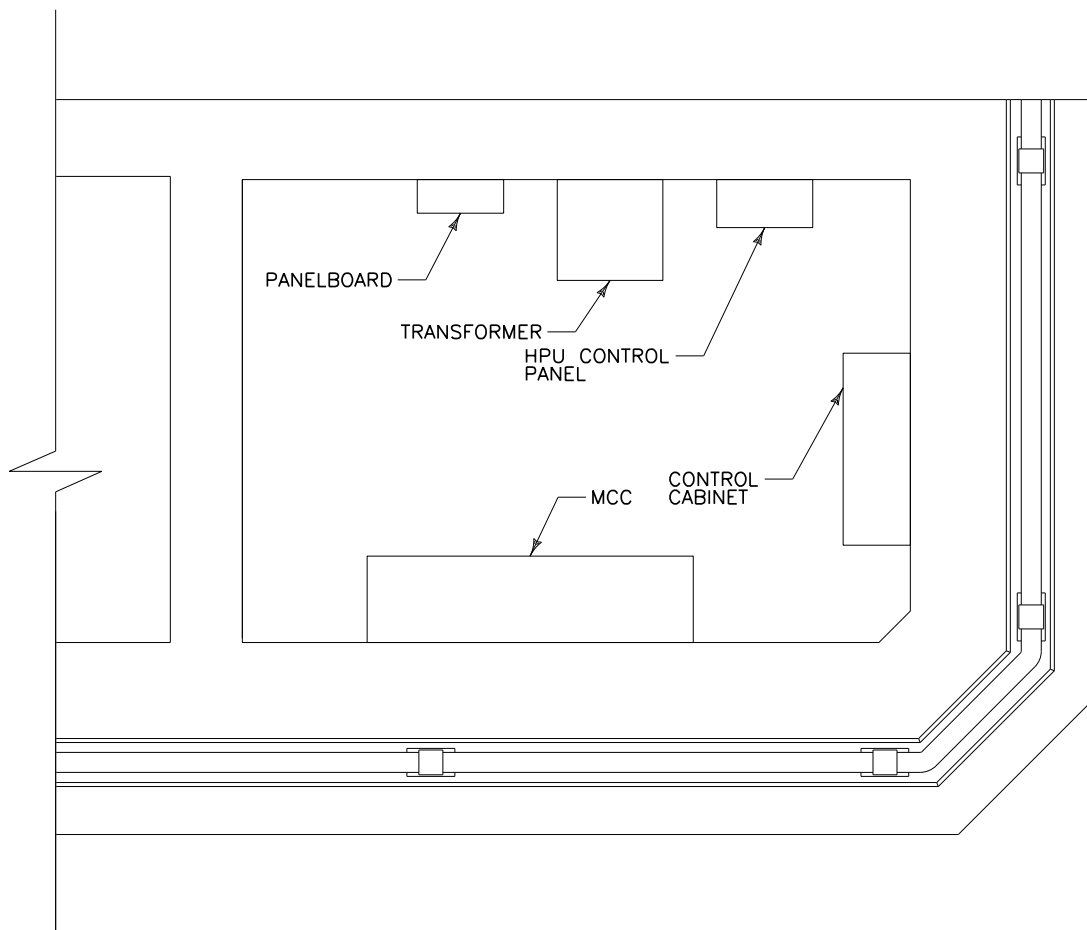

ELECTRICAL ROOM LOWER LEVEL
SCALE: 1/2"=1'-0"

DESIGN CONCEPT



PROJECT NAME: NORTH HERO GRAND ISLE BRIDGE	
PROJECT NUMBER: BHF 028-1(26)	
FILE NAME: Z12b142bdr_ctrlhouse.dgn	PLOT DATE: 7/24/2015
PROJECT LEADER: C. SWANSON	DRAWN BY: Y. ADELEKAN
DESIGNED BY: Y. ADELEKAN	CHECKED BY: H. PROTIN
ELECTRICAL EQUIPMENT LAYOUT	SHEET 30 OF 30